


MATCH LINE STA. 24+00

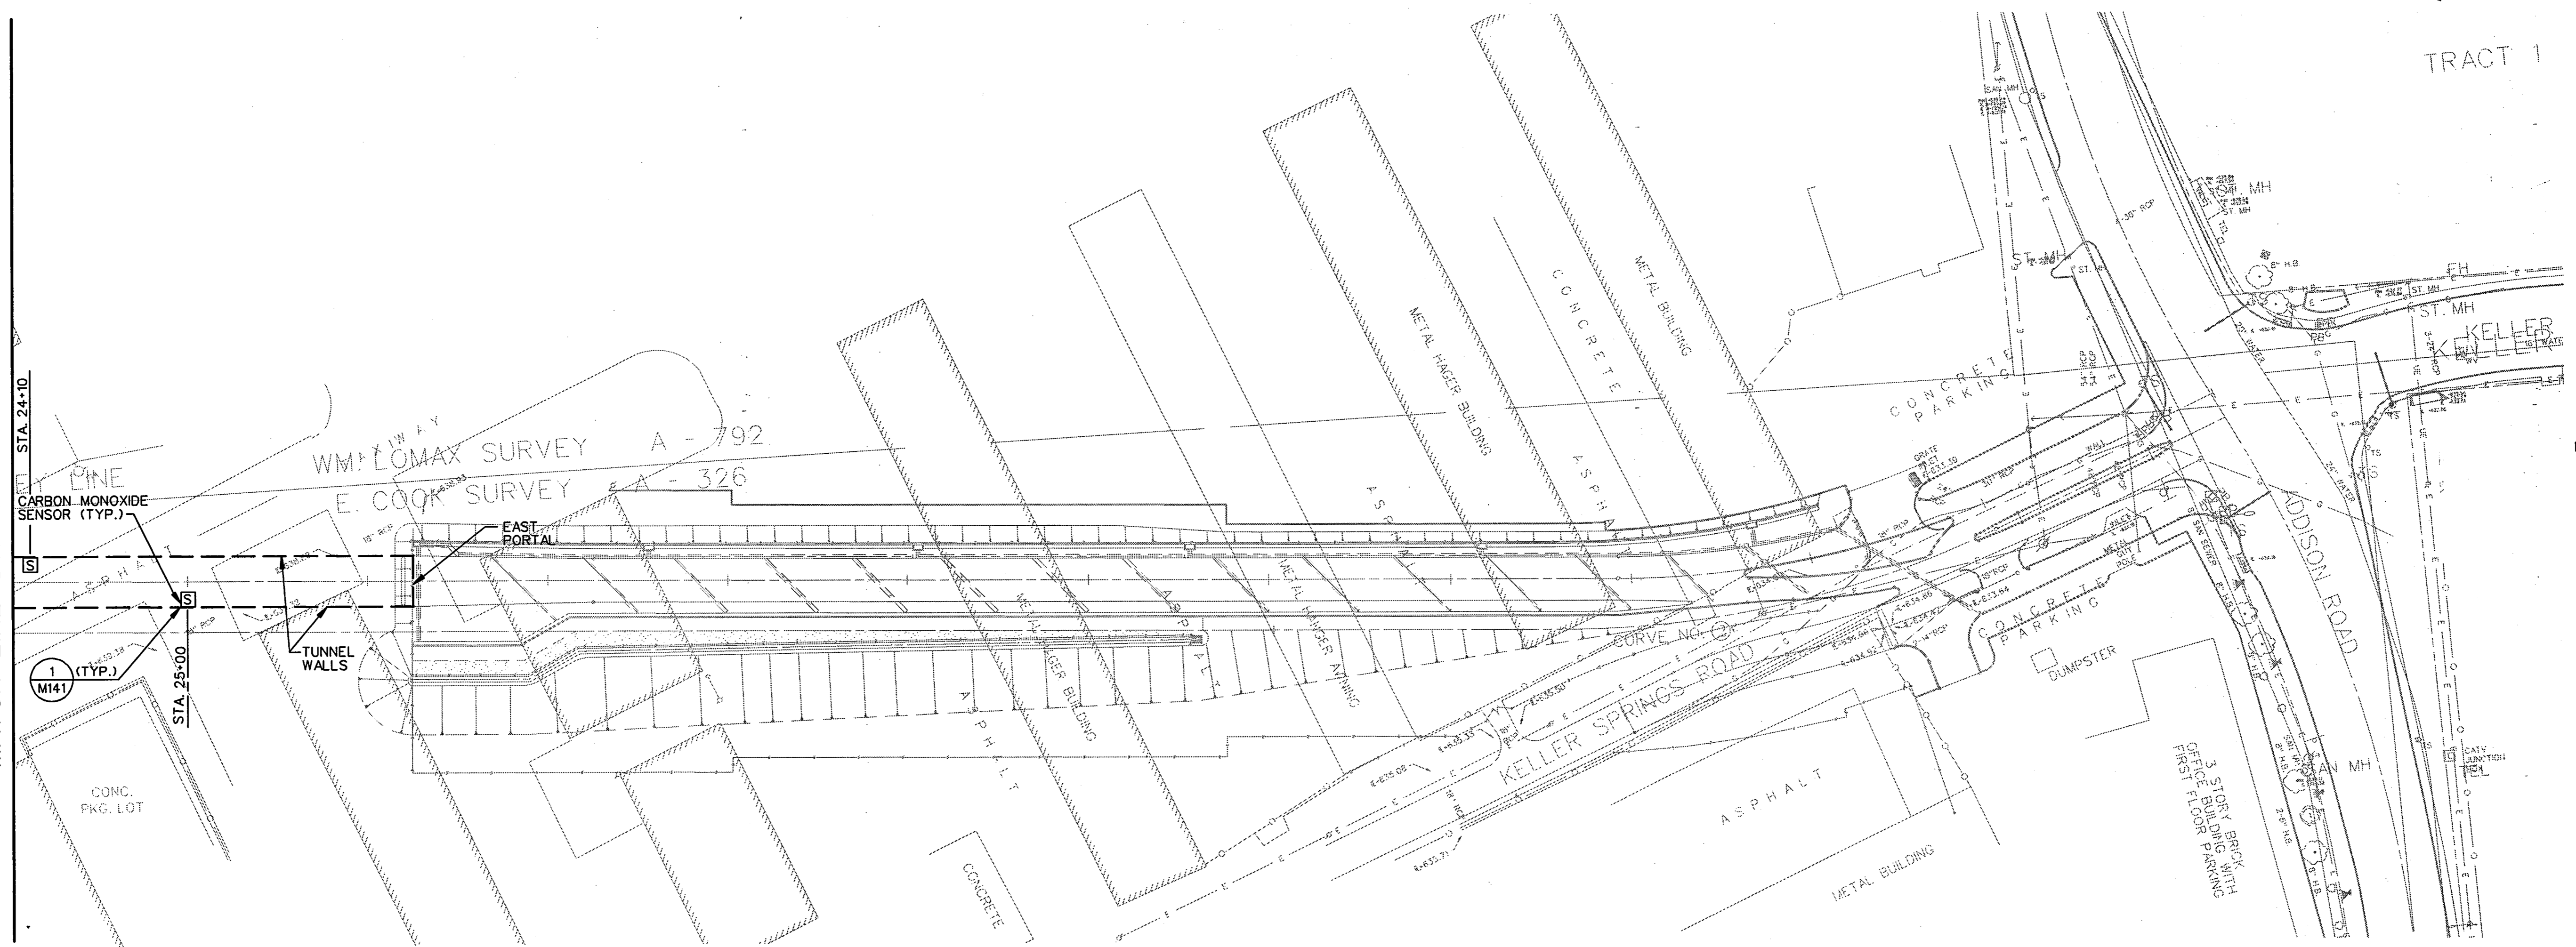

1 VENTILATION PLAN
SCALE: 1" = 50'



THE SEAL APPEARING ON THIS DOCUMENT WAS AUTHORIZED BY MIKE L. ASHCRAFT, P.E., 56590 ON SEPTEMBER 9, 1996

FINAL RECORD
DRAWING
Date: 12/25/99

No.	REVISION	BY	DATE
TEXAS TURNPIKE AUTHORITY ADDISON AIRPORT TUNNEL			
TUNNEL VENTILATION PLANS			
HDR HDR Engineering, Inc.			SECTION XIII
DRAWN: WTD	DATE: 12/05/96	DESIGNED: M.L.A.	DATE: 08/28/96
CHECKED: KG	DATE: 08/28/96	SCALE: 1" = 50'	
CONTRACT No. DNT-260 SHEET. M139 OF 166			