


1 TYPICAL TUNNEL LIGHTING PLAN
E165 NO SCALE



2 TYPICAL CONDUIT ROUTING - SECTION AT ELECTRICAL ROOM
E165 NO SCALE

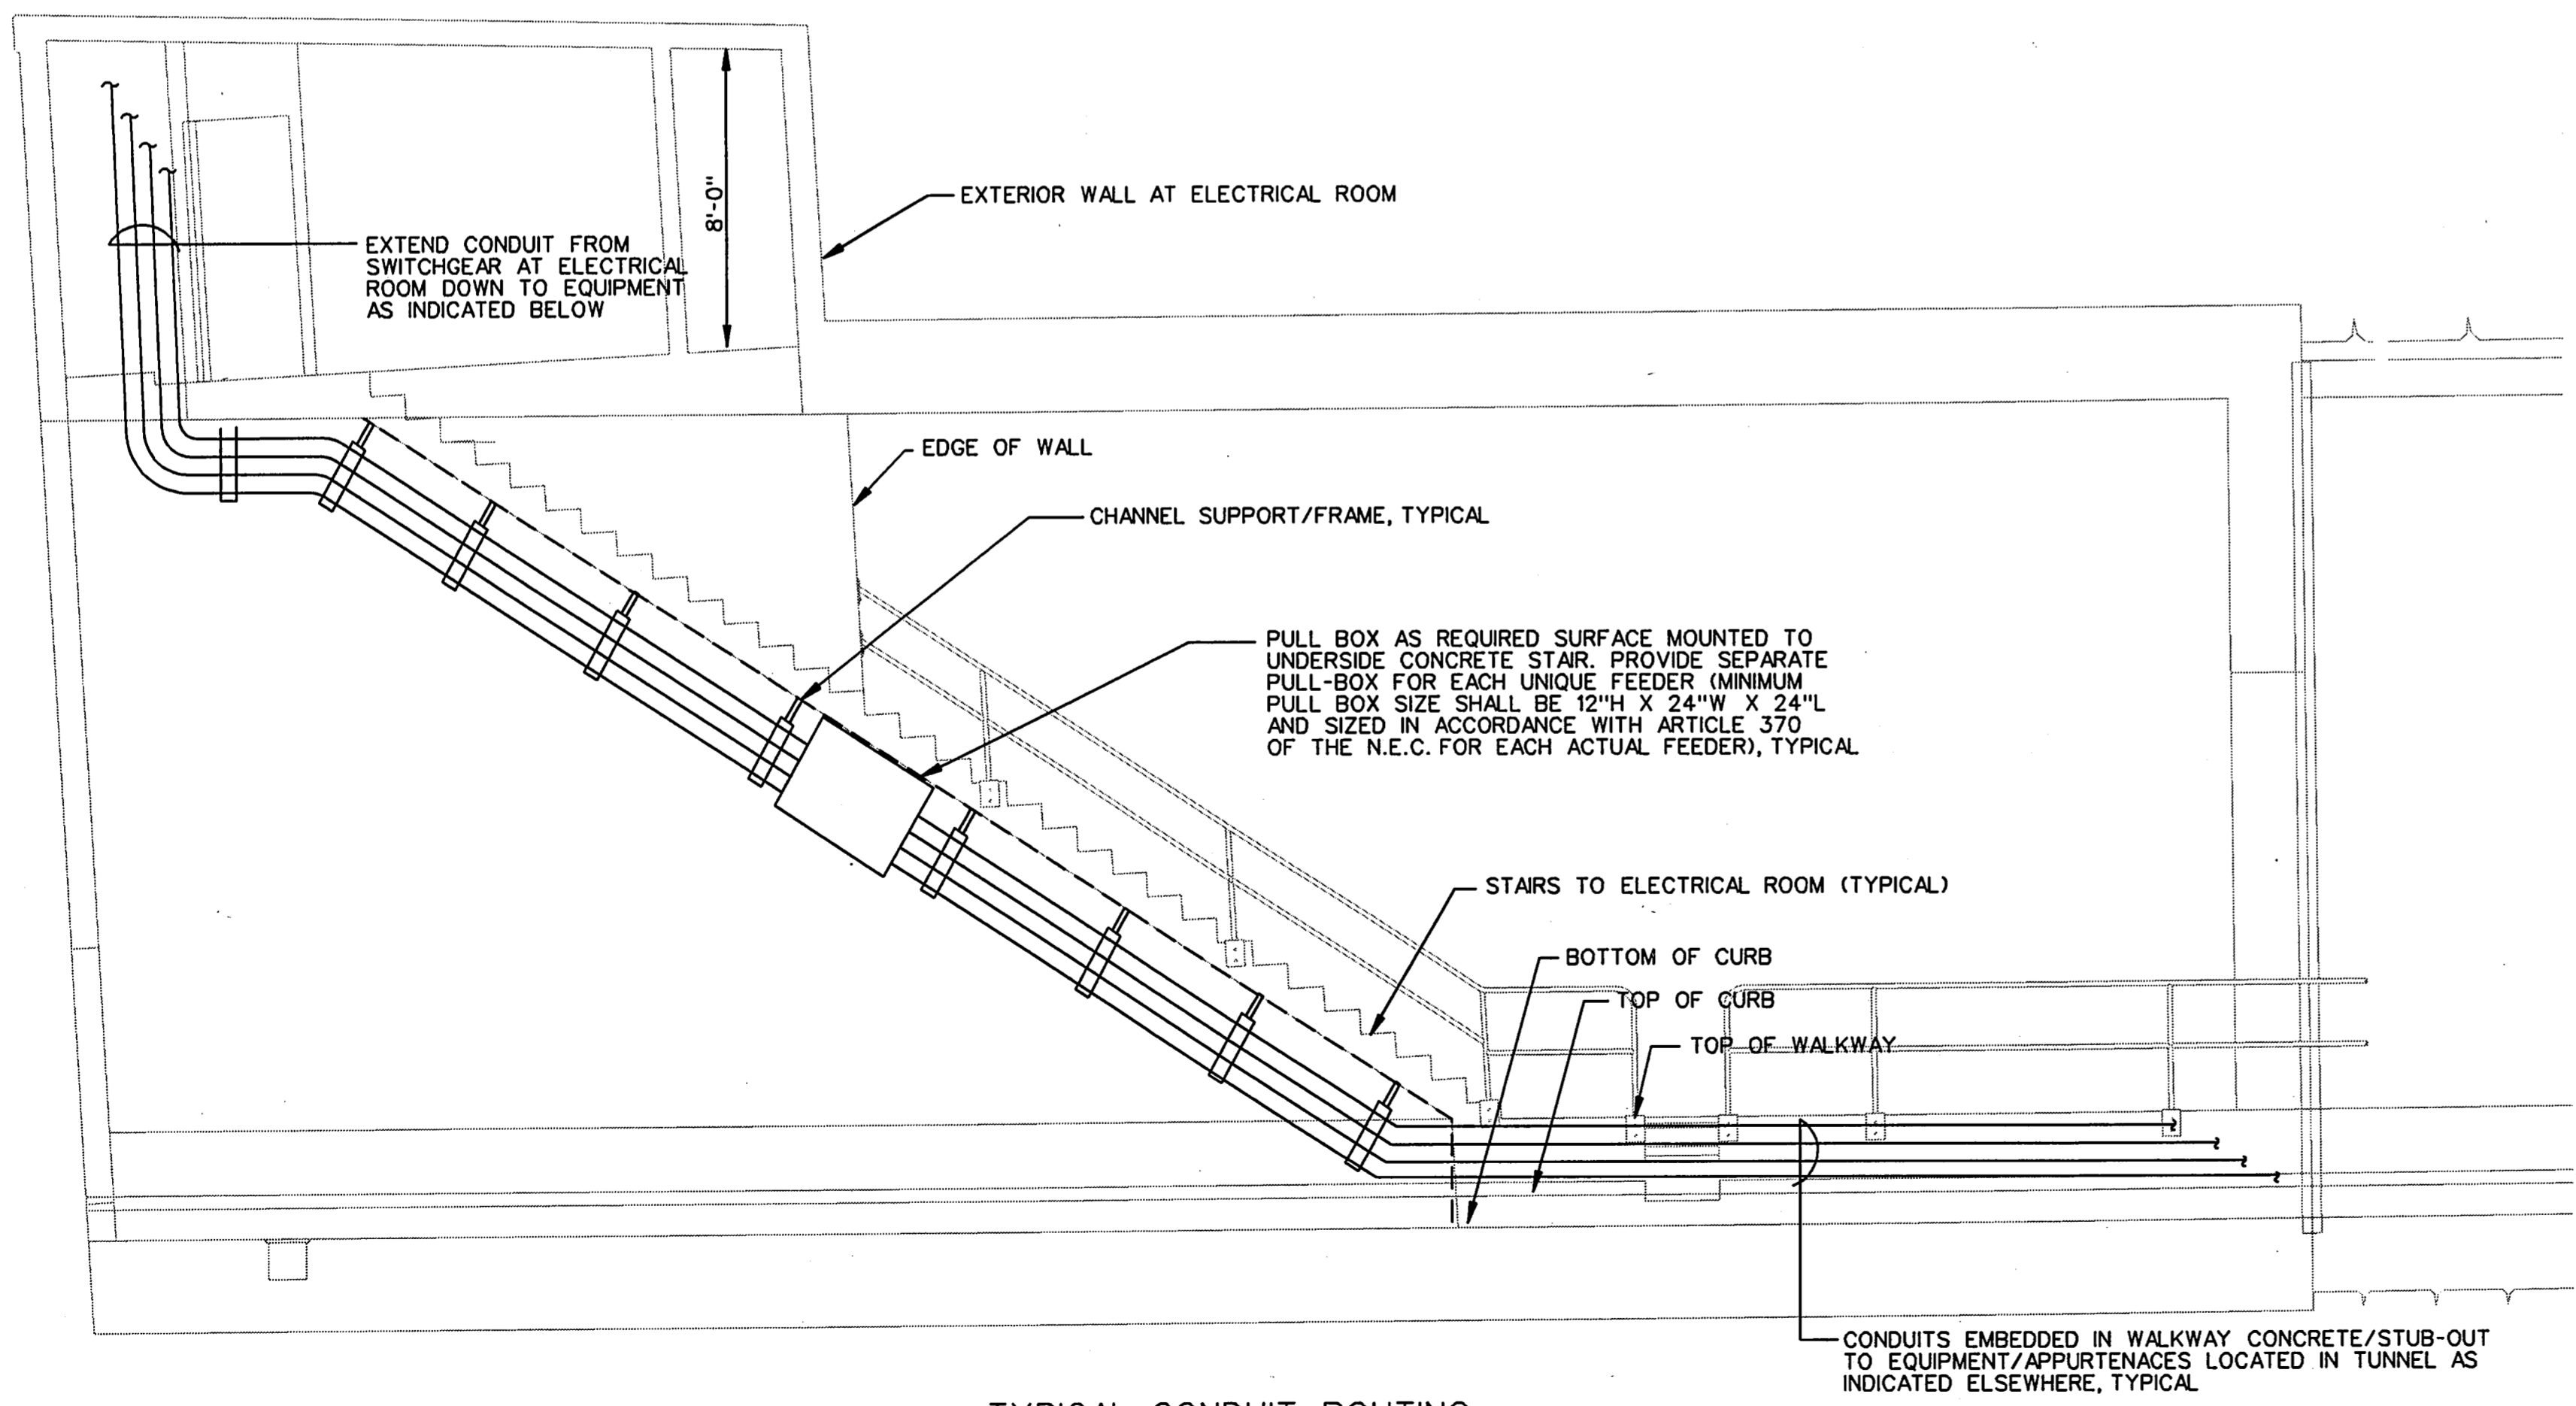

THE SEAL APPEARING ON THIS DOCUMENT WAS AUTHORIZED BY LEOPOLDO F. RIOS, P.E., 58272 ON SEPTEMBER 9, 1996

FINAL RECORD
DRAWING
Date: 12/25/99

No.	REVISION	BY	DATE
TEXAS TURNPIKE AUTHORITY ADDISON AIRPORT TUNNEL			
PARTIAL PLANS/DETAILS			
HDR Engineering, Inc.			SECTION XIII
DRAWN: WTD	DATE: 12/05/96	DESIGNED: LR	DATE: 08/28/96
CHECKED: BL	DATE: 08/28/96	SCALE: NONE	
CONTRACT No. DNT-260 SHEET E165 OF 166			

FILE: p:\additum\dgn\adttue113.dgn
DATE: 23-Apr-96 20:01