



INSTALLATION DETAIL OF ALTERNATING RED FLASHING LIGHTS ON WEST PORTAL SIGN

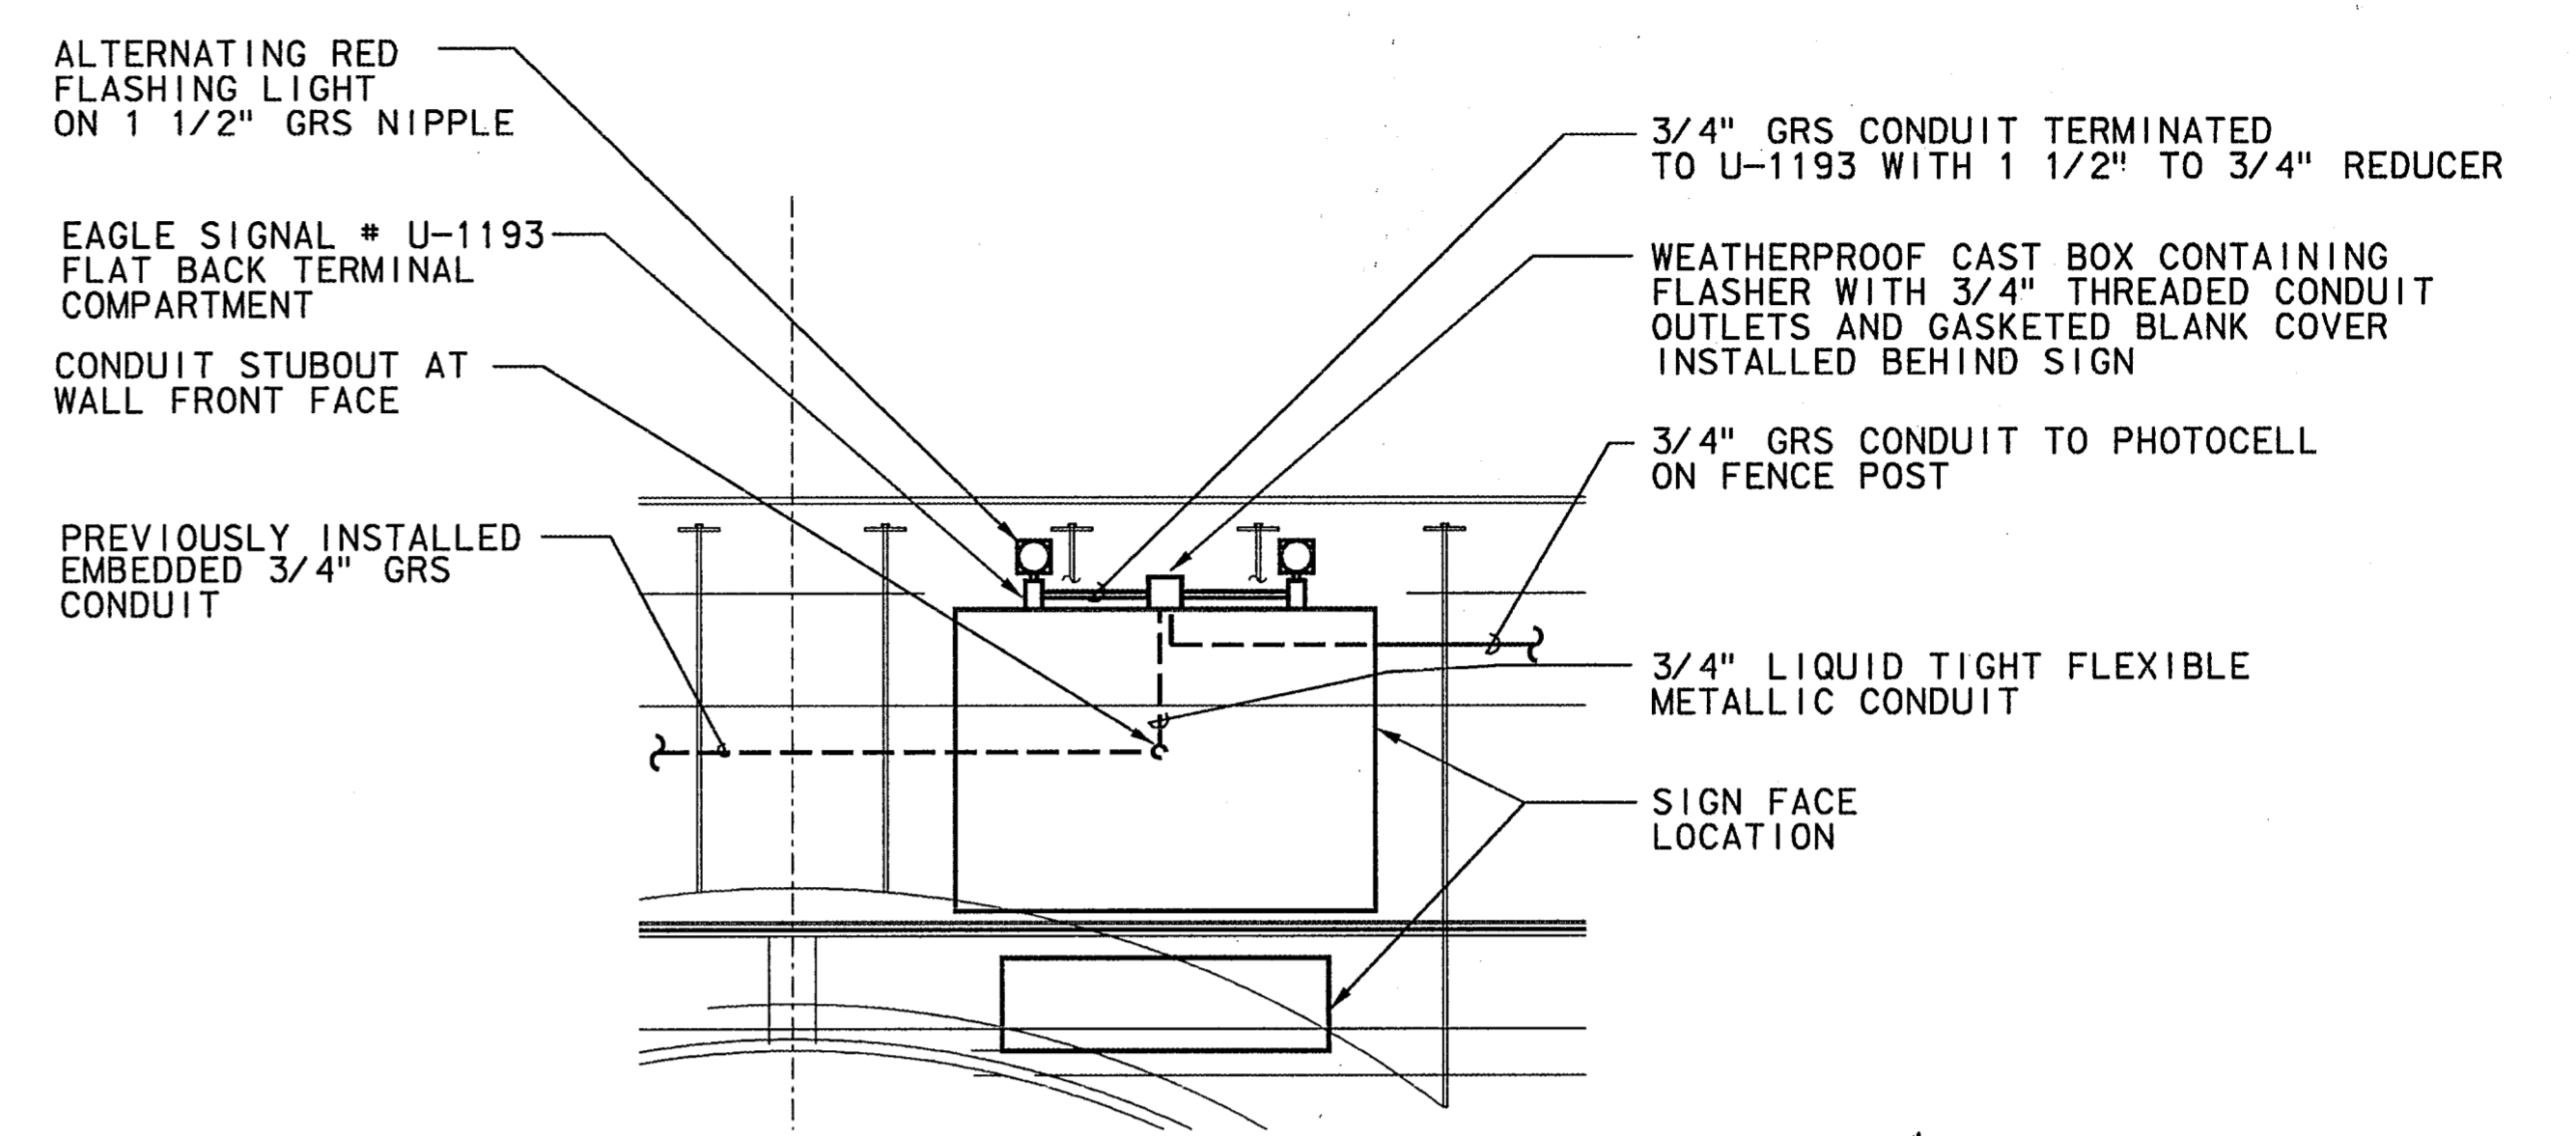

INSTALLATION DETAIL OF ALTERNATING RED FLASHING LIGHTS ON EAST PORTAL SIGN  
NOT TO SCALE

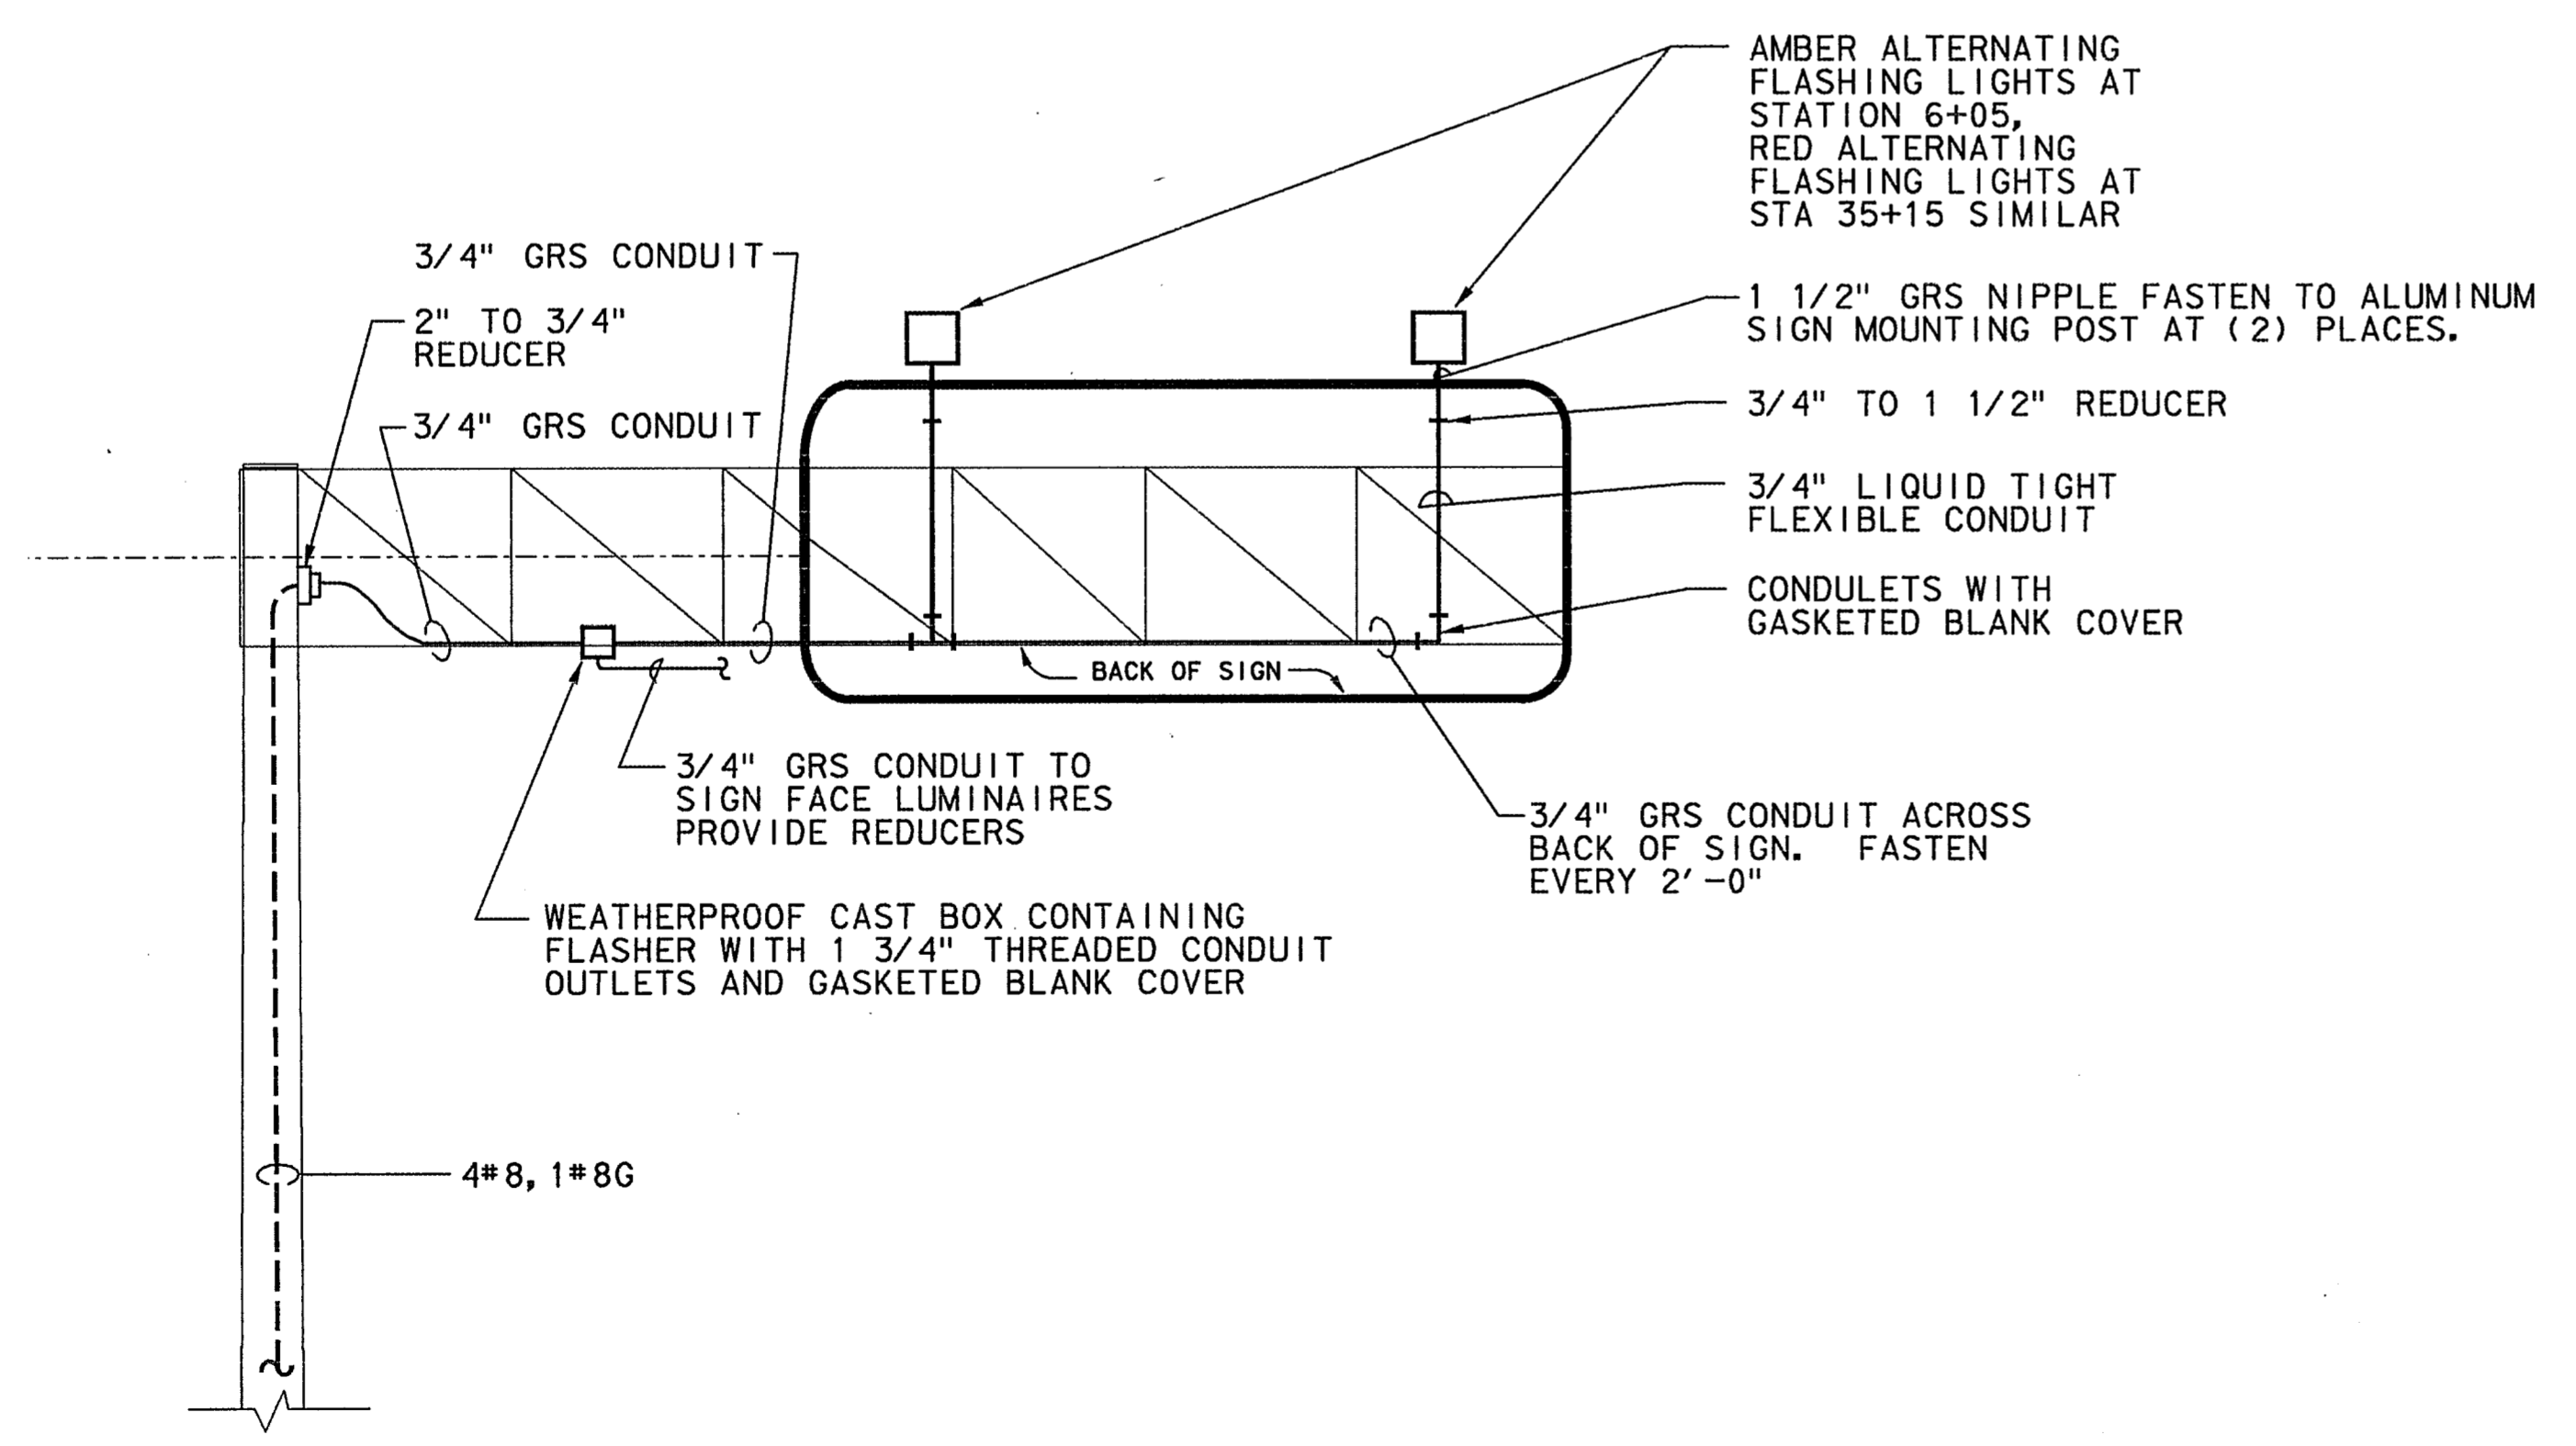

INSTALLATION DETAIL OF ALTERNATING FLASHING LIGHT AT SIGN STRUCTURE ON STEEL POLE  
NOT TO SCALE

**NOTES:**

1. INSTALL FLASHING LIGHTS, FLASHER AND SIGNS FURNISHED BY THE AUTHORITY.
2. FASTEN ALL CONDUIT RUNS.

THE SEAL APPEARING ON THIS DOCUMENT WAS AUTHORIZED BY RICHARD J. MILLER, P.E. NO. 42812 ON JANUARY 12, 1999. ALTERATION OF A SEALED DOCUMENT WITHOUT PRIOR NOTIFICATION TO THE RESPONSIBLE ENGINEER IS AN OFFENSE UNDER THE TEXAS ENGINEERING PRACTICE ACT.



No.	REVISION	BY	DATE
NORTH TEXAS TOLLWAY AUTHORITY ADDISON AIRPORT TUNNEL			
MISCELLANEOUS ELECTRICAL DETAILS			
MATED CONSULTING ENGINEERS, INC. 5580 PETERSON LANE SUITE 225 DALLAS, TEXAS 75240 (972) 235-6700			SECTION XIII
DRAWN: SAA	DATE: 5/97	DESIGNED: DR	DATE: 5/97
CHECKED: RJM	DATE: 5/97	SCALE: AS SHOWN	
CONTRACT No. DNT-260 SHEET 26 OF 52			

**FINAL RECORD  
DRAWING**  
Date: 12/25/99