



COPYRIGHT © URS Greiner Woodward Clyde Inc., 2000 ALL RIGHTS RESERVED

XREF: AIRTBK.DWG

PROJECTS/E70107/SICAUD

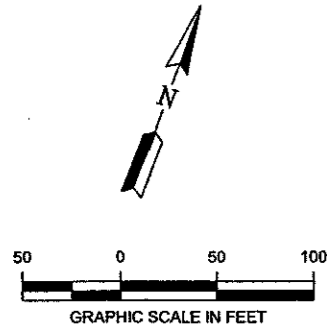

- NOTES:**
1. ALL MATERIALS NOT SALVAGED SHALL BECOME THE PROPERTY OF THE CONTRACTOR AND SHALL BE REMOVED FROM THE AIRPORT. SALVAGED MATERIALS SHALL BE INCORPORATED INTO THE PROJECT OR RETURNED TO THE OWNER.
 2. REMOVED PAVEMENT TO GRAVEL MAY BE INCORPORATED INTO THE EMBANKMENT AS ALLOWED BY THE SPECIFICATIONS.
 3. SEE ELECTRICAL PLANS FOR ADDITIONAL ITEMS TO BE REMOVED.

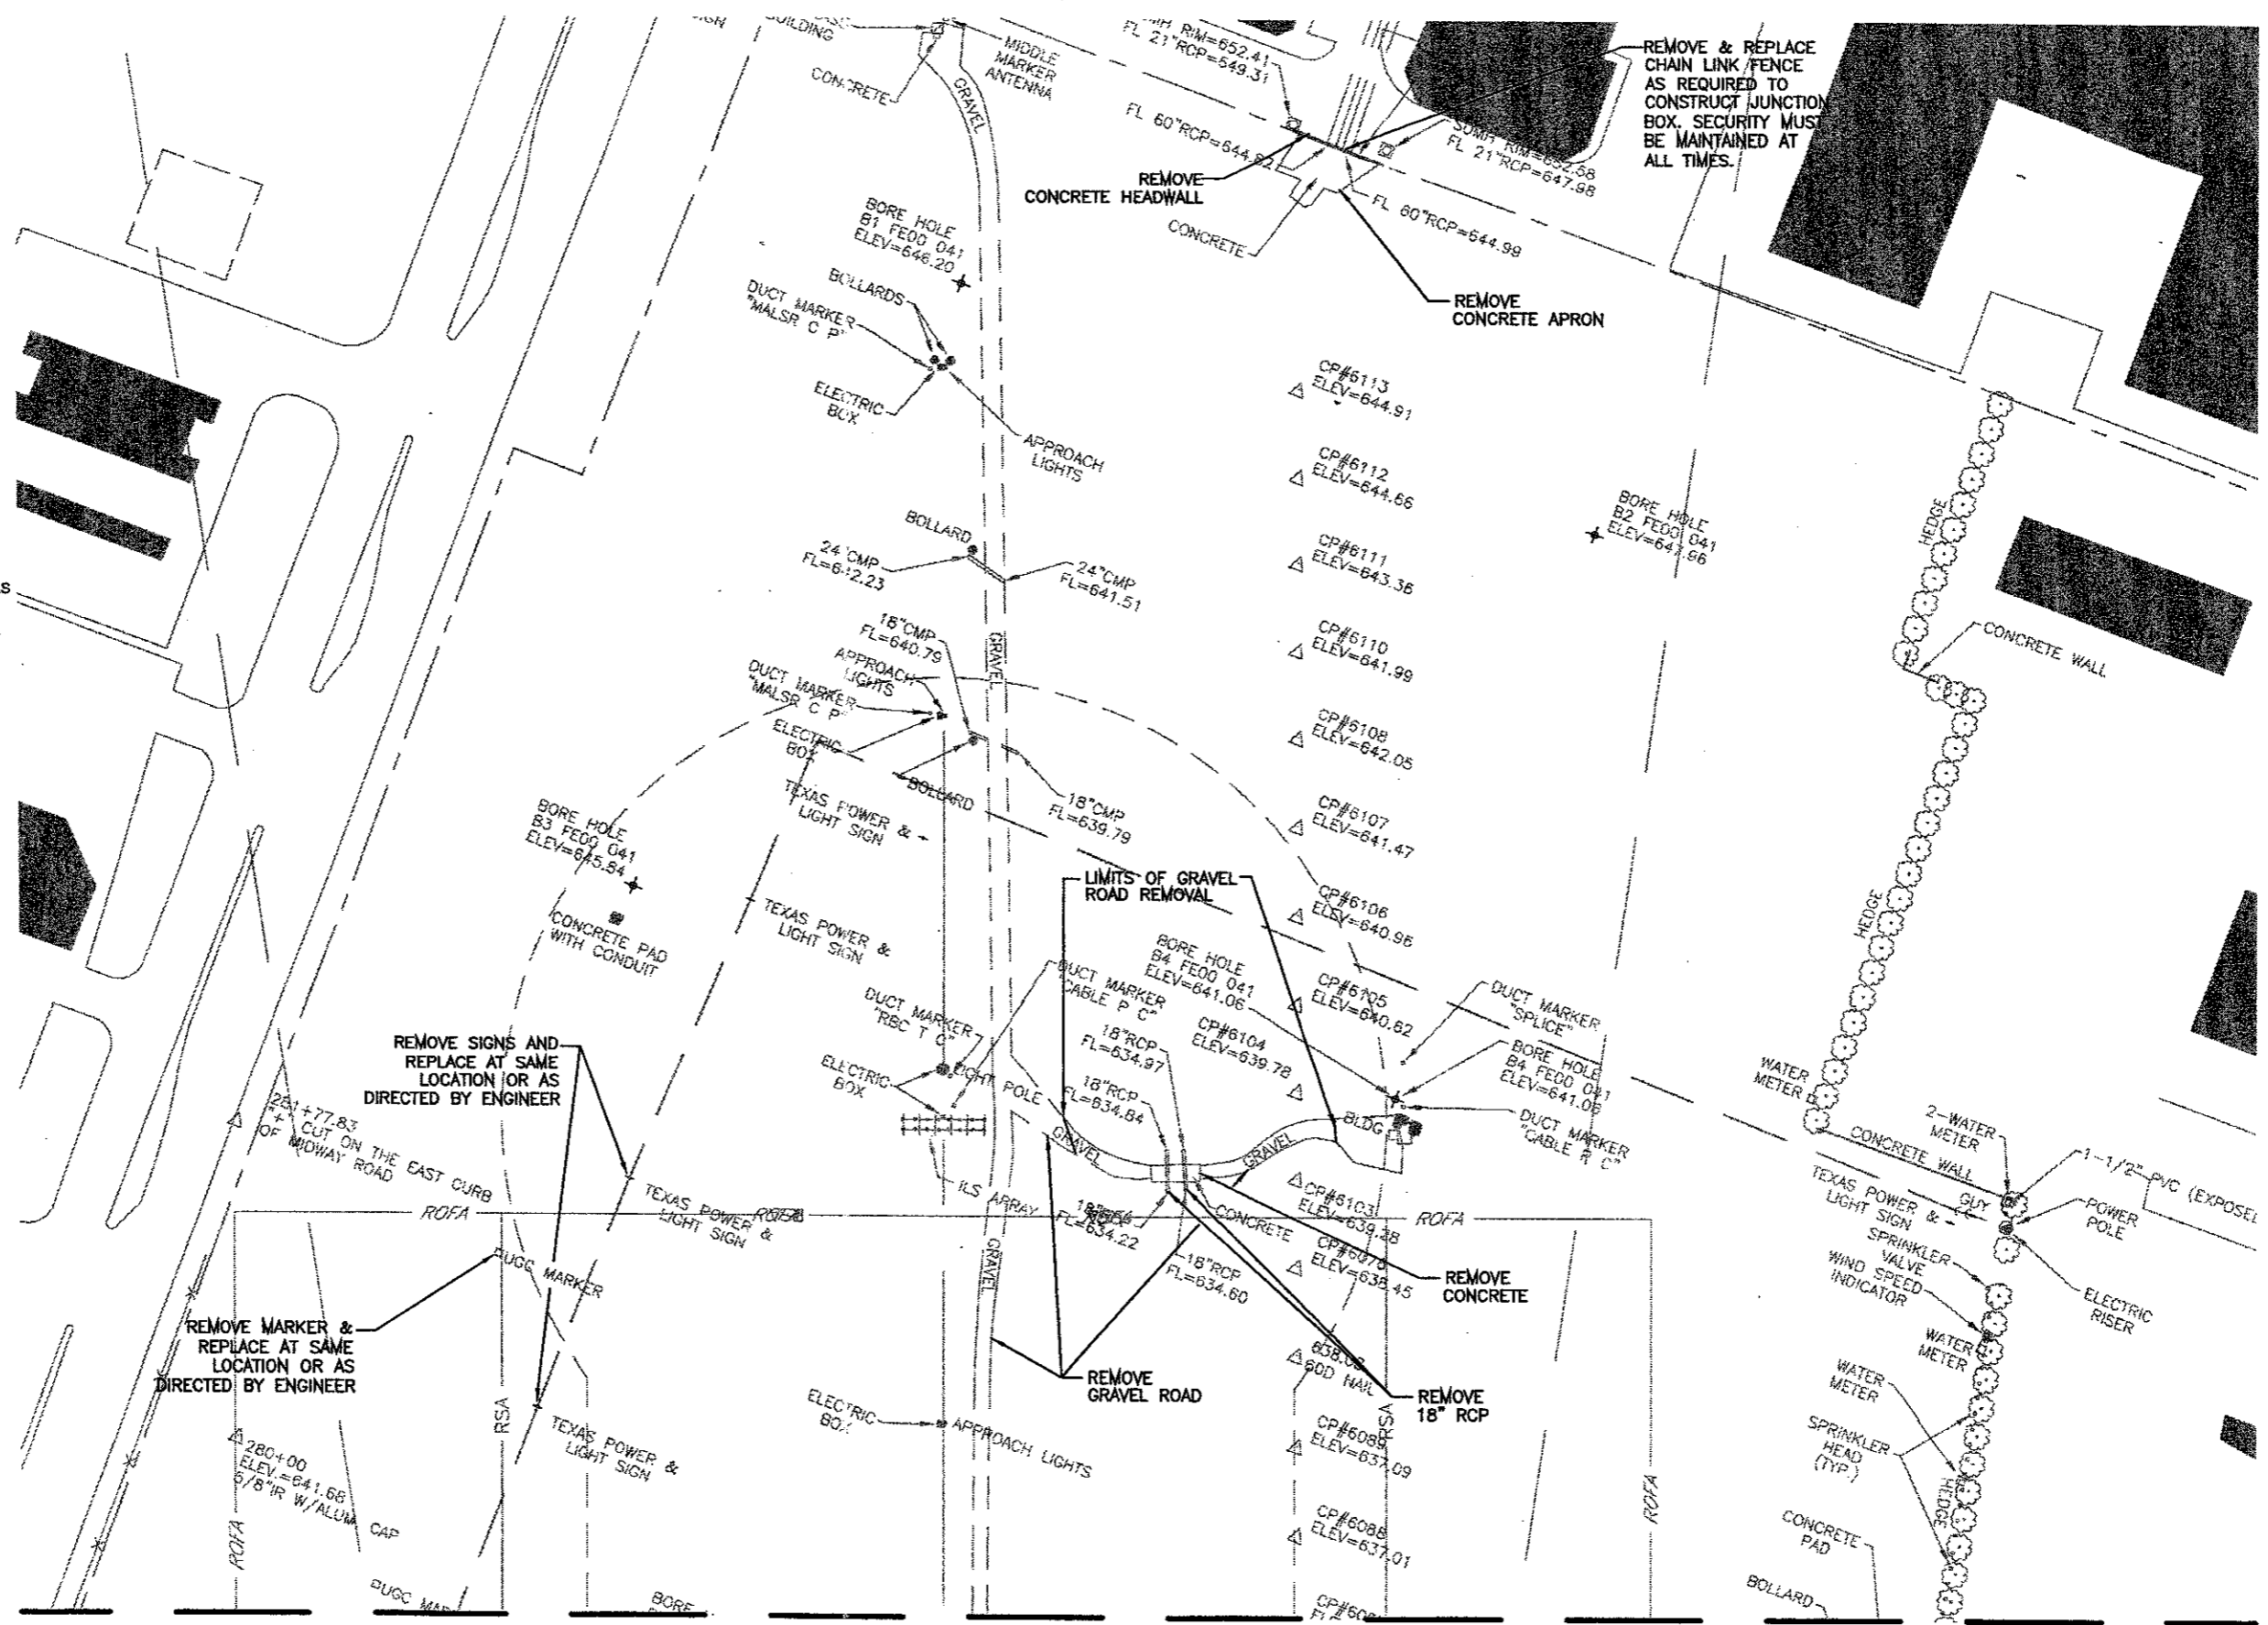

MATCHLINE AT STA. 79+00

PROJECT NAME	ADDISON AIRPORT
DRAWING TITLE	DEMOLITION PLAN
DRAWING NO.	D1.2
DATE	12/8/00
PROJECT NO.	E70107/SICAUD
BID NO.	E70107/S.00
URS NO.	K.H.I.T.S.
DESIGN	KH
DRAWN	KH
CHECKED	IS
SCALE	1"=50'