



MATCH LINE SHEET ES

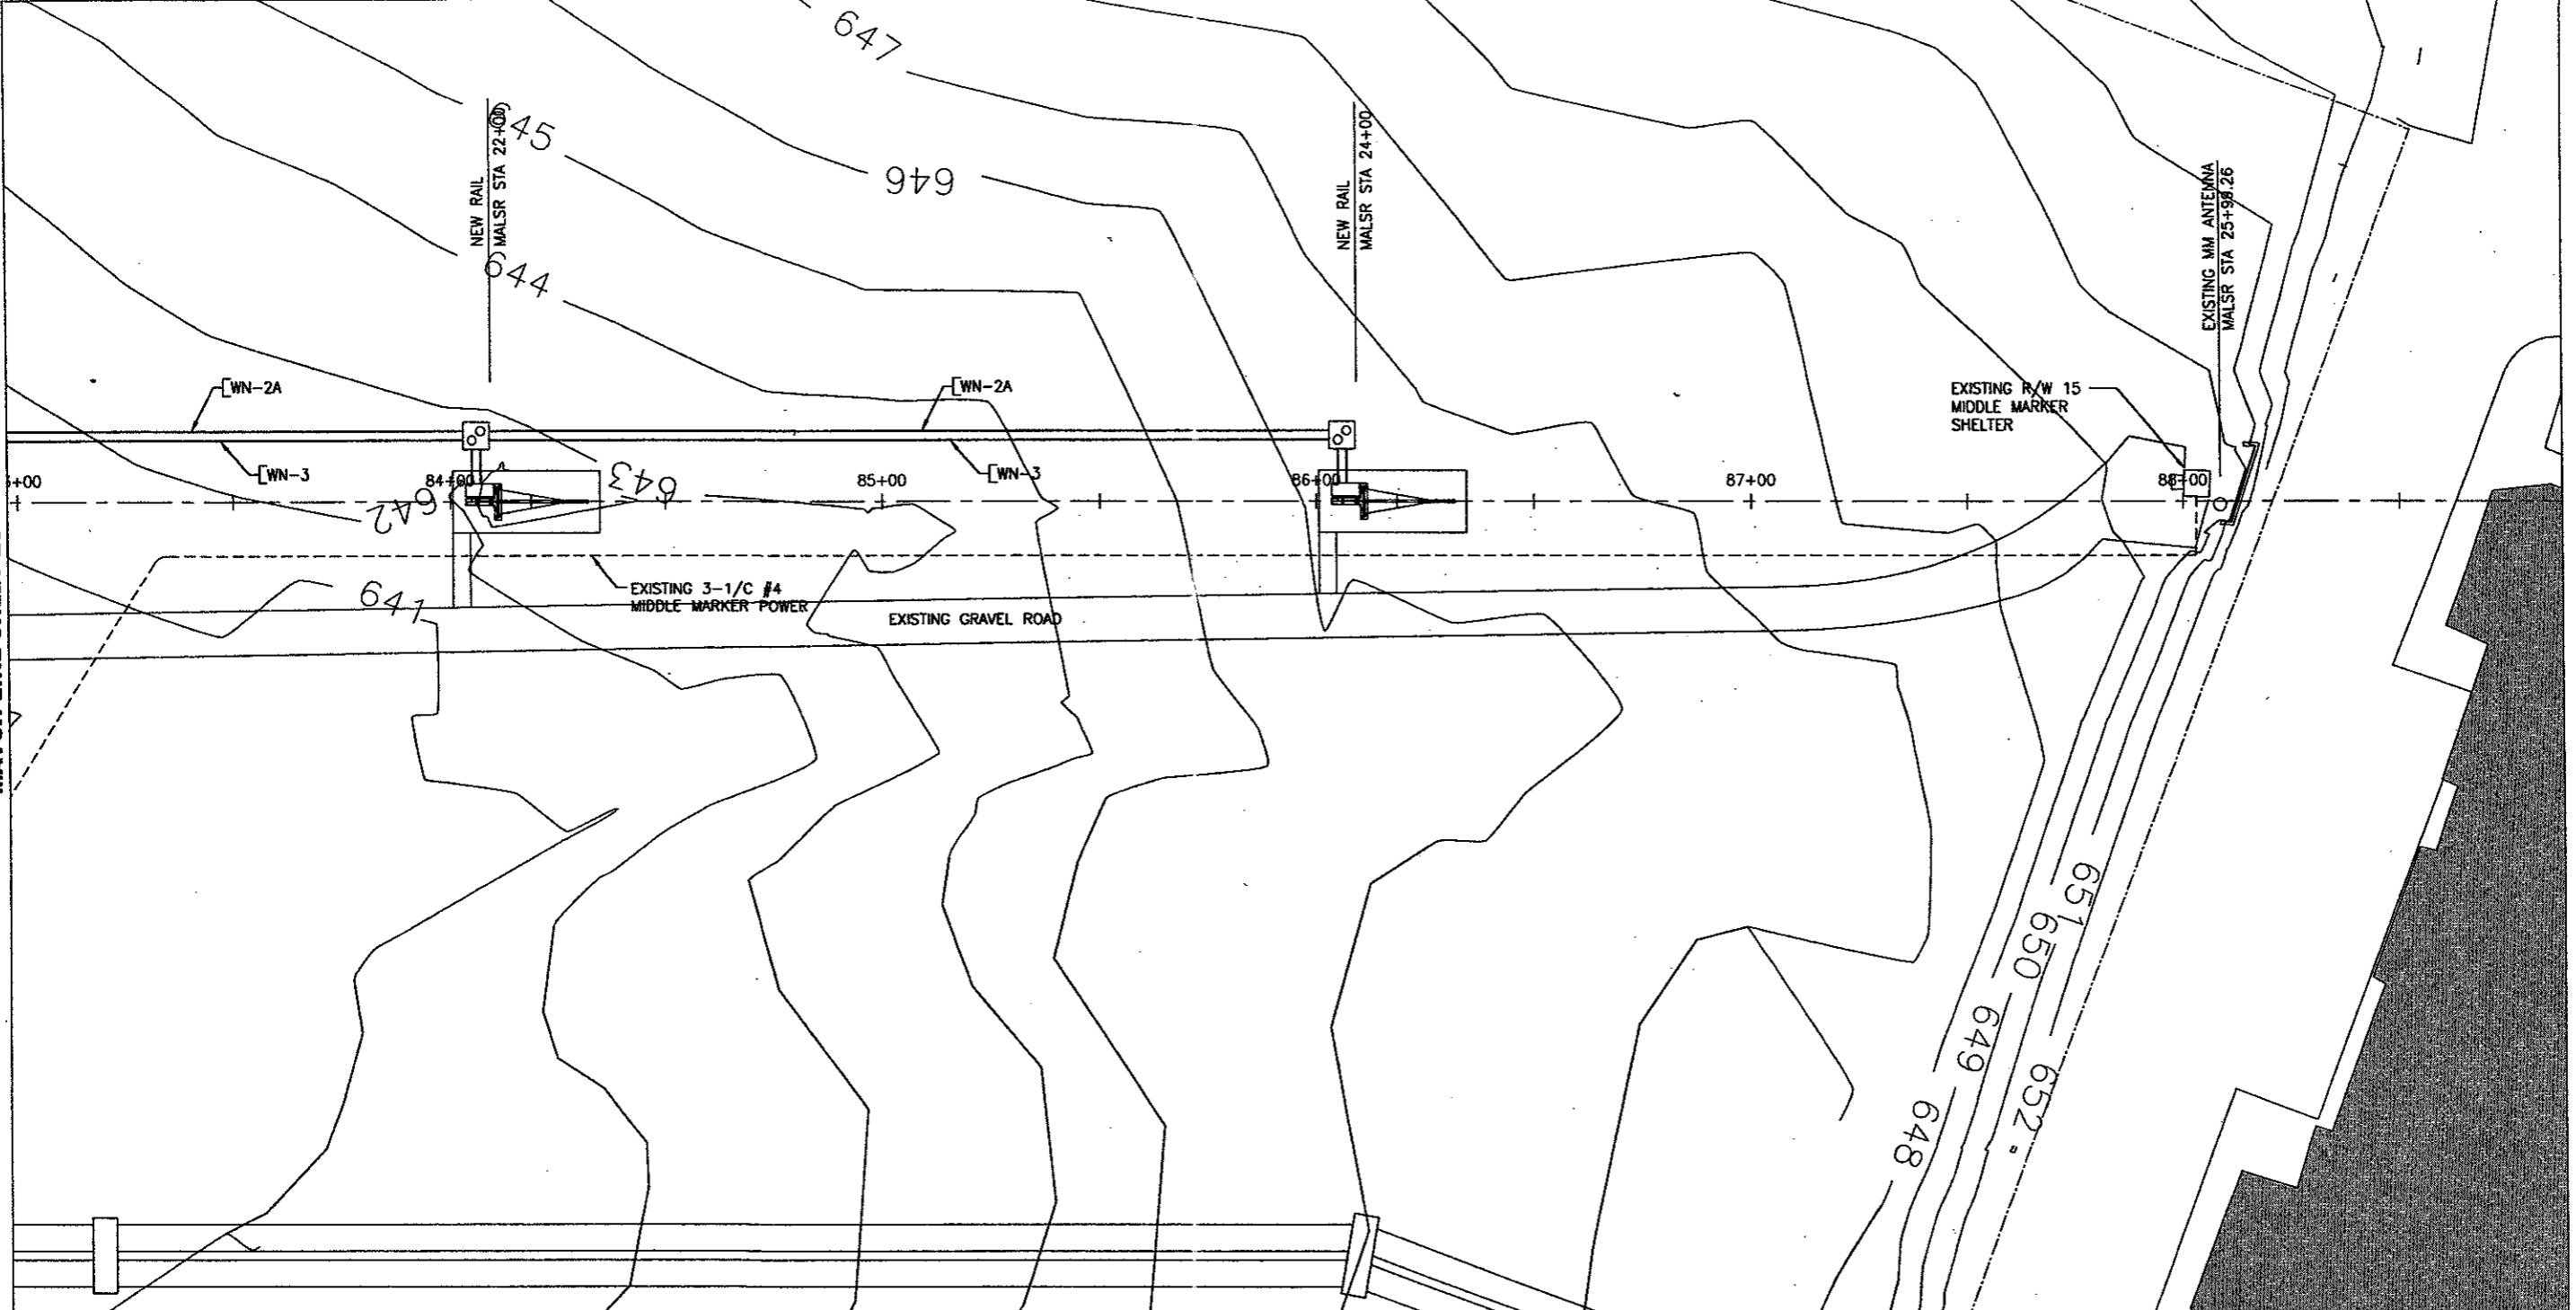

- SHEET NOTES (SN-#):**
1. CONTROL CABLE AND POWER CABLE SHALL NOT BE INSTALLED IN THE SAME CONDUIT.
 2. SEE DETAIL SHEETS FOR CONDUIT DETAILS AT EACH STATION.
 3. SEE MALSRS ELECTRICAL DETAILS SHEET 1 OF 2.

LEGEND	
	JUNCTION CAN
	2" SCH 40 PVC CONDUIT (DEB)
	JUNCTION CAN PLAZA
	CONCRETE ENCASED DUCT

- WIRE NOTES (WN-#):**
1. RESERVED.
 2. 3-1/C #2 AWG 600V (RAIL POWER).
 - 2A. 3-1/C #4 AWG 600V (RAIL POWER).
 3. 6 PAIR #19 AWG 600V (RAIL CONTROL). SEE SN-1.

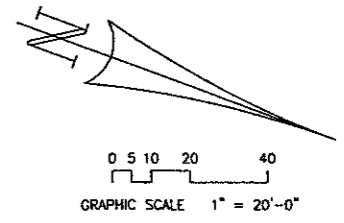

PROJECT NAME RUNWAY 15 ESA GRADING	DRAWING TITLE R/W 15 PROPOSED MALSRS LAYOUT - SHEET 3 OF 4	DRAWING NO. E6	DATE 2/8/01	REVISIONS	BY	DATE	
				TBDOT NO.	BID NO.	URRG NO.	E701044.00
PRELIMINARY NOT FOR CONSTRUCTION WORKING FOR THE USE OF:				AVATION ALLIANCE, INC. 4100 Arvon Carter Boulevard, Suite 108 Fort Worth, TX 76155 www.utsacorp.com			
ADDISON AIRPORT				AVATION ALLIANCE, INC. Consulting Engineers 			