


TOWN OF  
ADDISON

DALLAS COUNTY  
STATE OF TEXAS

### VICINITY MAP

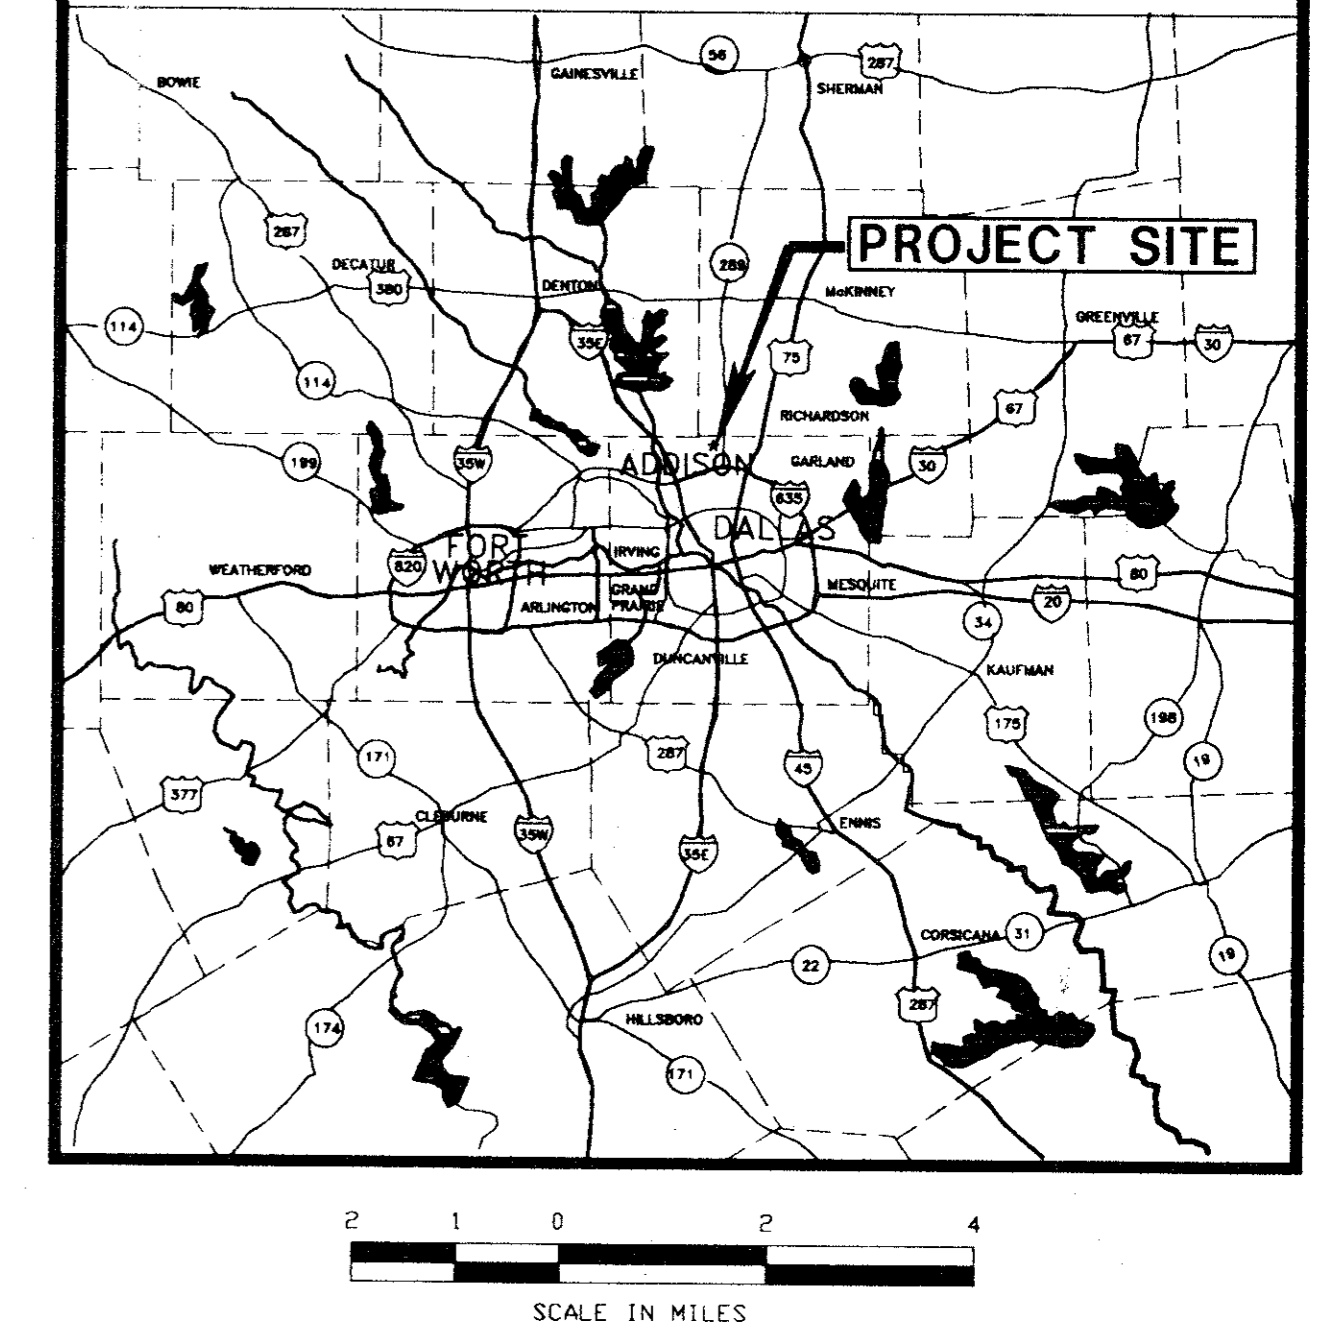

### INDEX OF DRAWINGS

SHEET NO.	DESCRIPTION
1	TITLE SHEET AND LOCATION MAP
2	SUMMARY OF QUANTITIES
3	EXISTING AIRPORT LAYOUT PLAN
4	PHASING PLAN
5	TYPICAL SECTIONS
6-8	PLAN AND PROFILE SHEETS
9-10	TAXIWAY PROFILES
11-15	*PAVING DETAILS
16-18	MARKING PLAN AND DETAILS
19	GROOVING PLAN AND DETAILS
20-25	R/W LIGHTING LAYOUT/CIRCUIT PLAN
26	A.T.C. TOWER CONTROL PANEL
27	ELECTRIC VAULT PLAN/LAYOUT
28	CABLE AND CONDUIT DETAILS
29	AIRFIELD LIGHTING INSTALLATION DETAILS
30	AIRFIELD GUIDANCE SIGN DETAILS
31	MANHOLE & HANDHOLE DETAILS
32	ELECTRIC VAULT ELEVATIONS
33	ELECTRIC VAULT SECTIONS
34-38	* PROPOSED RUNWAY CROSS SECTIONS
39-42	* PROPOSED TAXIWAY CROSS SECTIONS

\* OMITTED-NOT APPLICABLE TO AS-BUILTS

# RUNWAY REHABILITATION AND INSTALL MEDIUM INTENSITY RUNWAY LIGHTING (M.I.R.L.)

## ADDISON AIRPORT


BID NUMBER 92-29

A.I.P. PROJECT NO. 3-48-0063-04-92

JUNE, 1992


**Greiner, Inc.**  
FORT WORTH, TEXAS  
ENGINEERS ARCHITECTS PLANNERS

IN ASSOCIATION WITH:  
PSA ENGINEERING, INC.

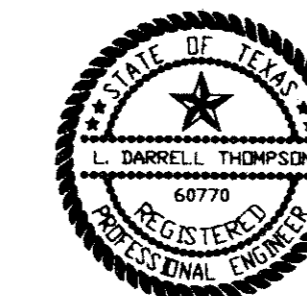

THE SEAL APPEARING ON THIS DOCUMENT WAS AUTHORIZED BY L. DARRELL THOMPSON, P.E. 60770, ON JUNE, 1992.

### LOCATION MAP

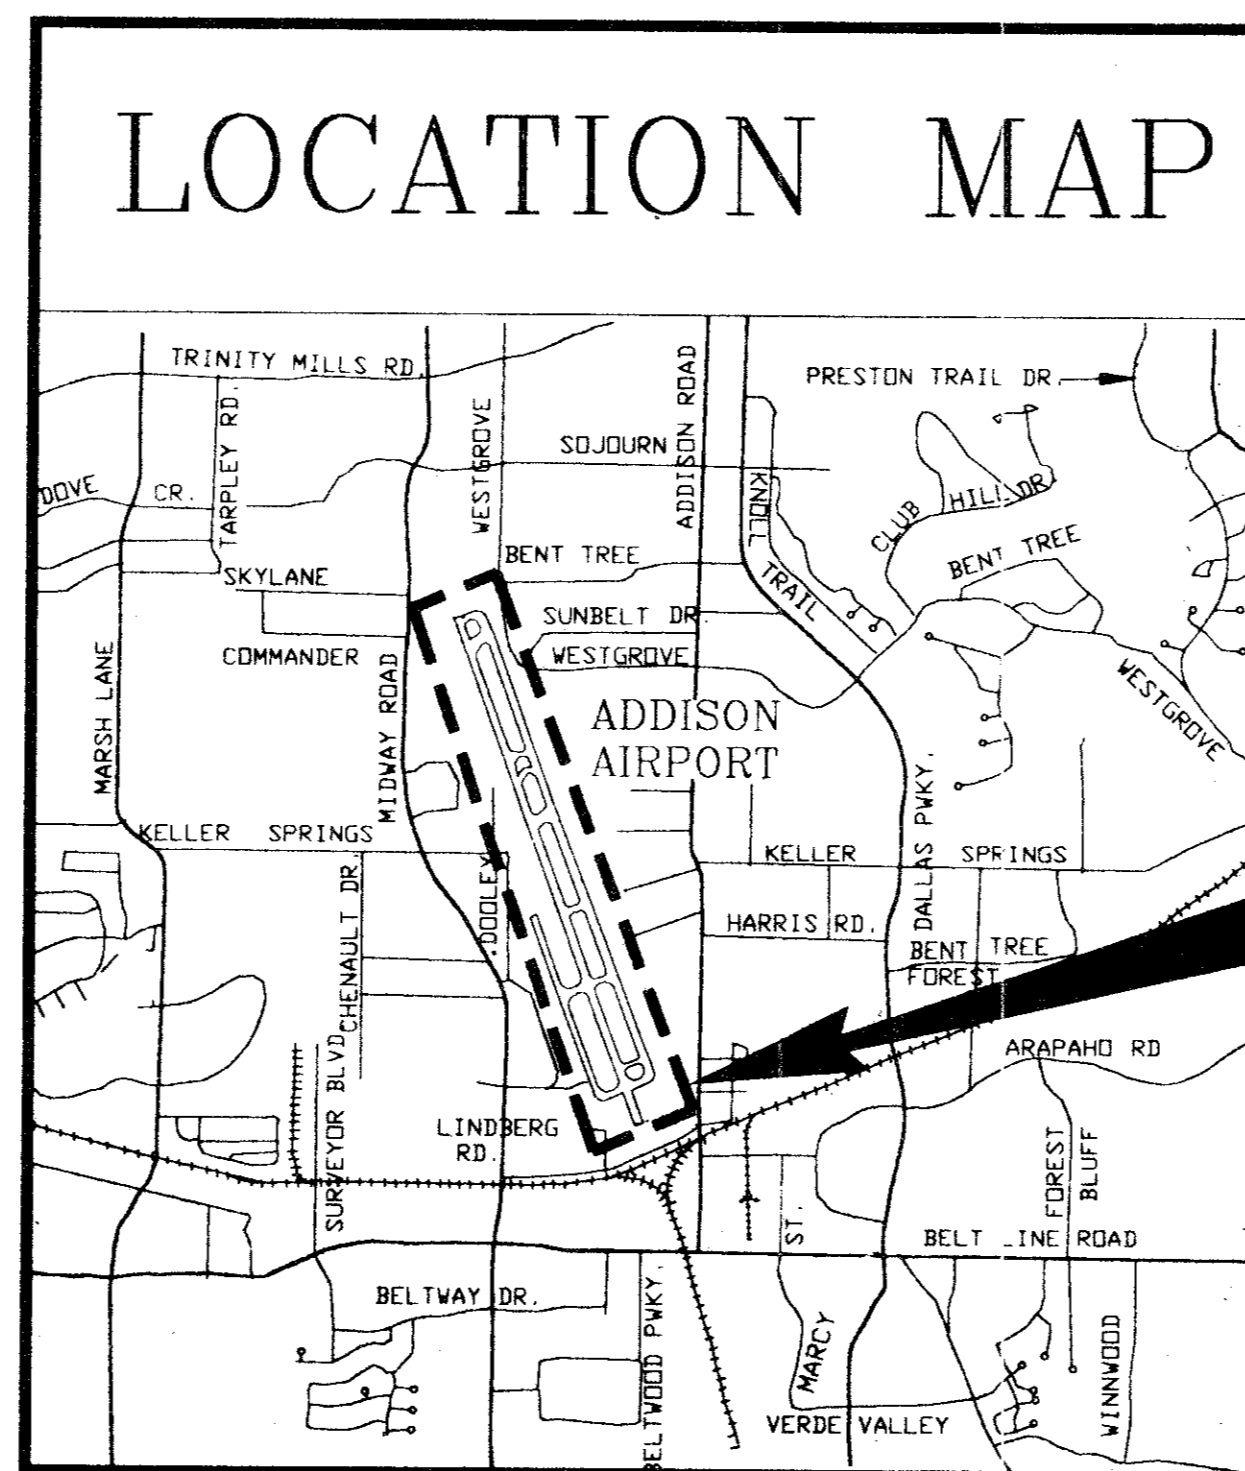

**PROPOSED IMPROVEMENTS**

TYPE OF CONSTRUCTION: PAVING, MARKING AND LIGHTING (M.I.R.L.)

REVISIONS		
DATE	DESCRIPTION	BY

RECOMMENDED FOR APPROVAL

*D. M. Logan*

DESIGN ENGINEER

DATE June 1, 1992

RECOMMENDED FOR APPROVAL

*Karen E. Clifton*  
PROJECT ENGINEER

DATE June 1, 1992

APPROVED

*[Signature]*  
CITY ENGINEER

**AS BUILT**

NRV 1 0 1993

DATE June 1, 1992

SET