
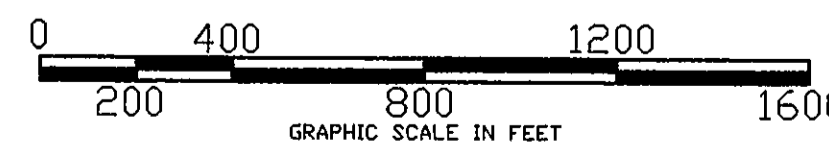


LEGEND

- WATER LINES ————
- SANITARY SEWER LINES - - - - -
- LONE STAR GAS LINES - - - - -
- CABLE TV LINES - - - - -
- UNDERGROUND POWER — UC — UC —

AS BUILT
OCT 20 1995

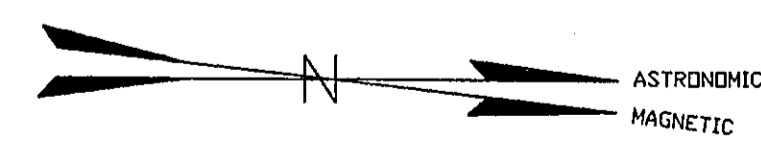

THE SEAL APPEARING ON THIS DOCUMENT WAS AUTHORIZED BY TRACY L. TERRILL, P.E. 70974, ON MAY, 1994.

DESIGN: <u>T.L.T.</u>	A.I.P. NO. <u>3-48-0063-06</u>	Date	Revisions	By
DRAWN: <u>M.J.C.</u>	BID NO. <u>94-33</u>			
CHECKED: <u>L.D.T.</u>	JOB NO. <u>Y8024.60</u>			
SCALE: 1" = 400'				

Greiner, Inc.
Greiner, Inc.
Fort Worth, Texas
Engineers, Architects
and Planners



ADDISON AIRPORT

UTILITY PLAN

SHEET
30
DATE/MAY, 1994