


CAUTION: UNDERGROUND UTILITIES

CONTACT UTILITY COMPANIES AND FAA 48 HOUR PRIOR TO CONSTRUCTION FOR LOCATION OF UTILITIES. ANY DAMAGE TO EXISTING FACILITIES WILL BE THE SOLE RESPONSIBILITY OF THE CONTRACTOR. ANY REPAIRS OR DAMAGES SHALL BE PAID FOR BY THE CONTRACTOR AT NO EXPENSE TO THE OWNER. SPLICES ARE NOT ALLOWED IN FAA INSTRUMENT LANDING SYSTEMS CABLES. DAMAGE TO THESE CABLES WILL RESULT IN REPLACEMENT OF THE ENTIRE CABLE AT CONTRACTOR'S EXPENSE. CALL FAA AT 214-239-4042 OR 214-490-4750. FAX 214-490-7324.

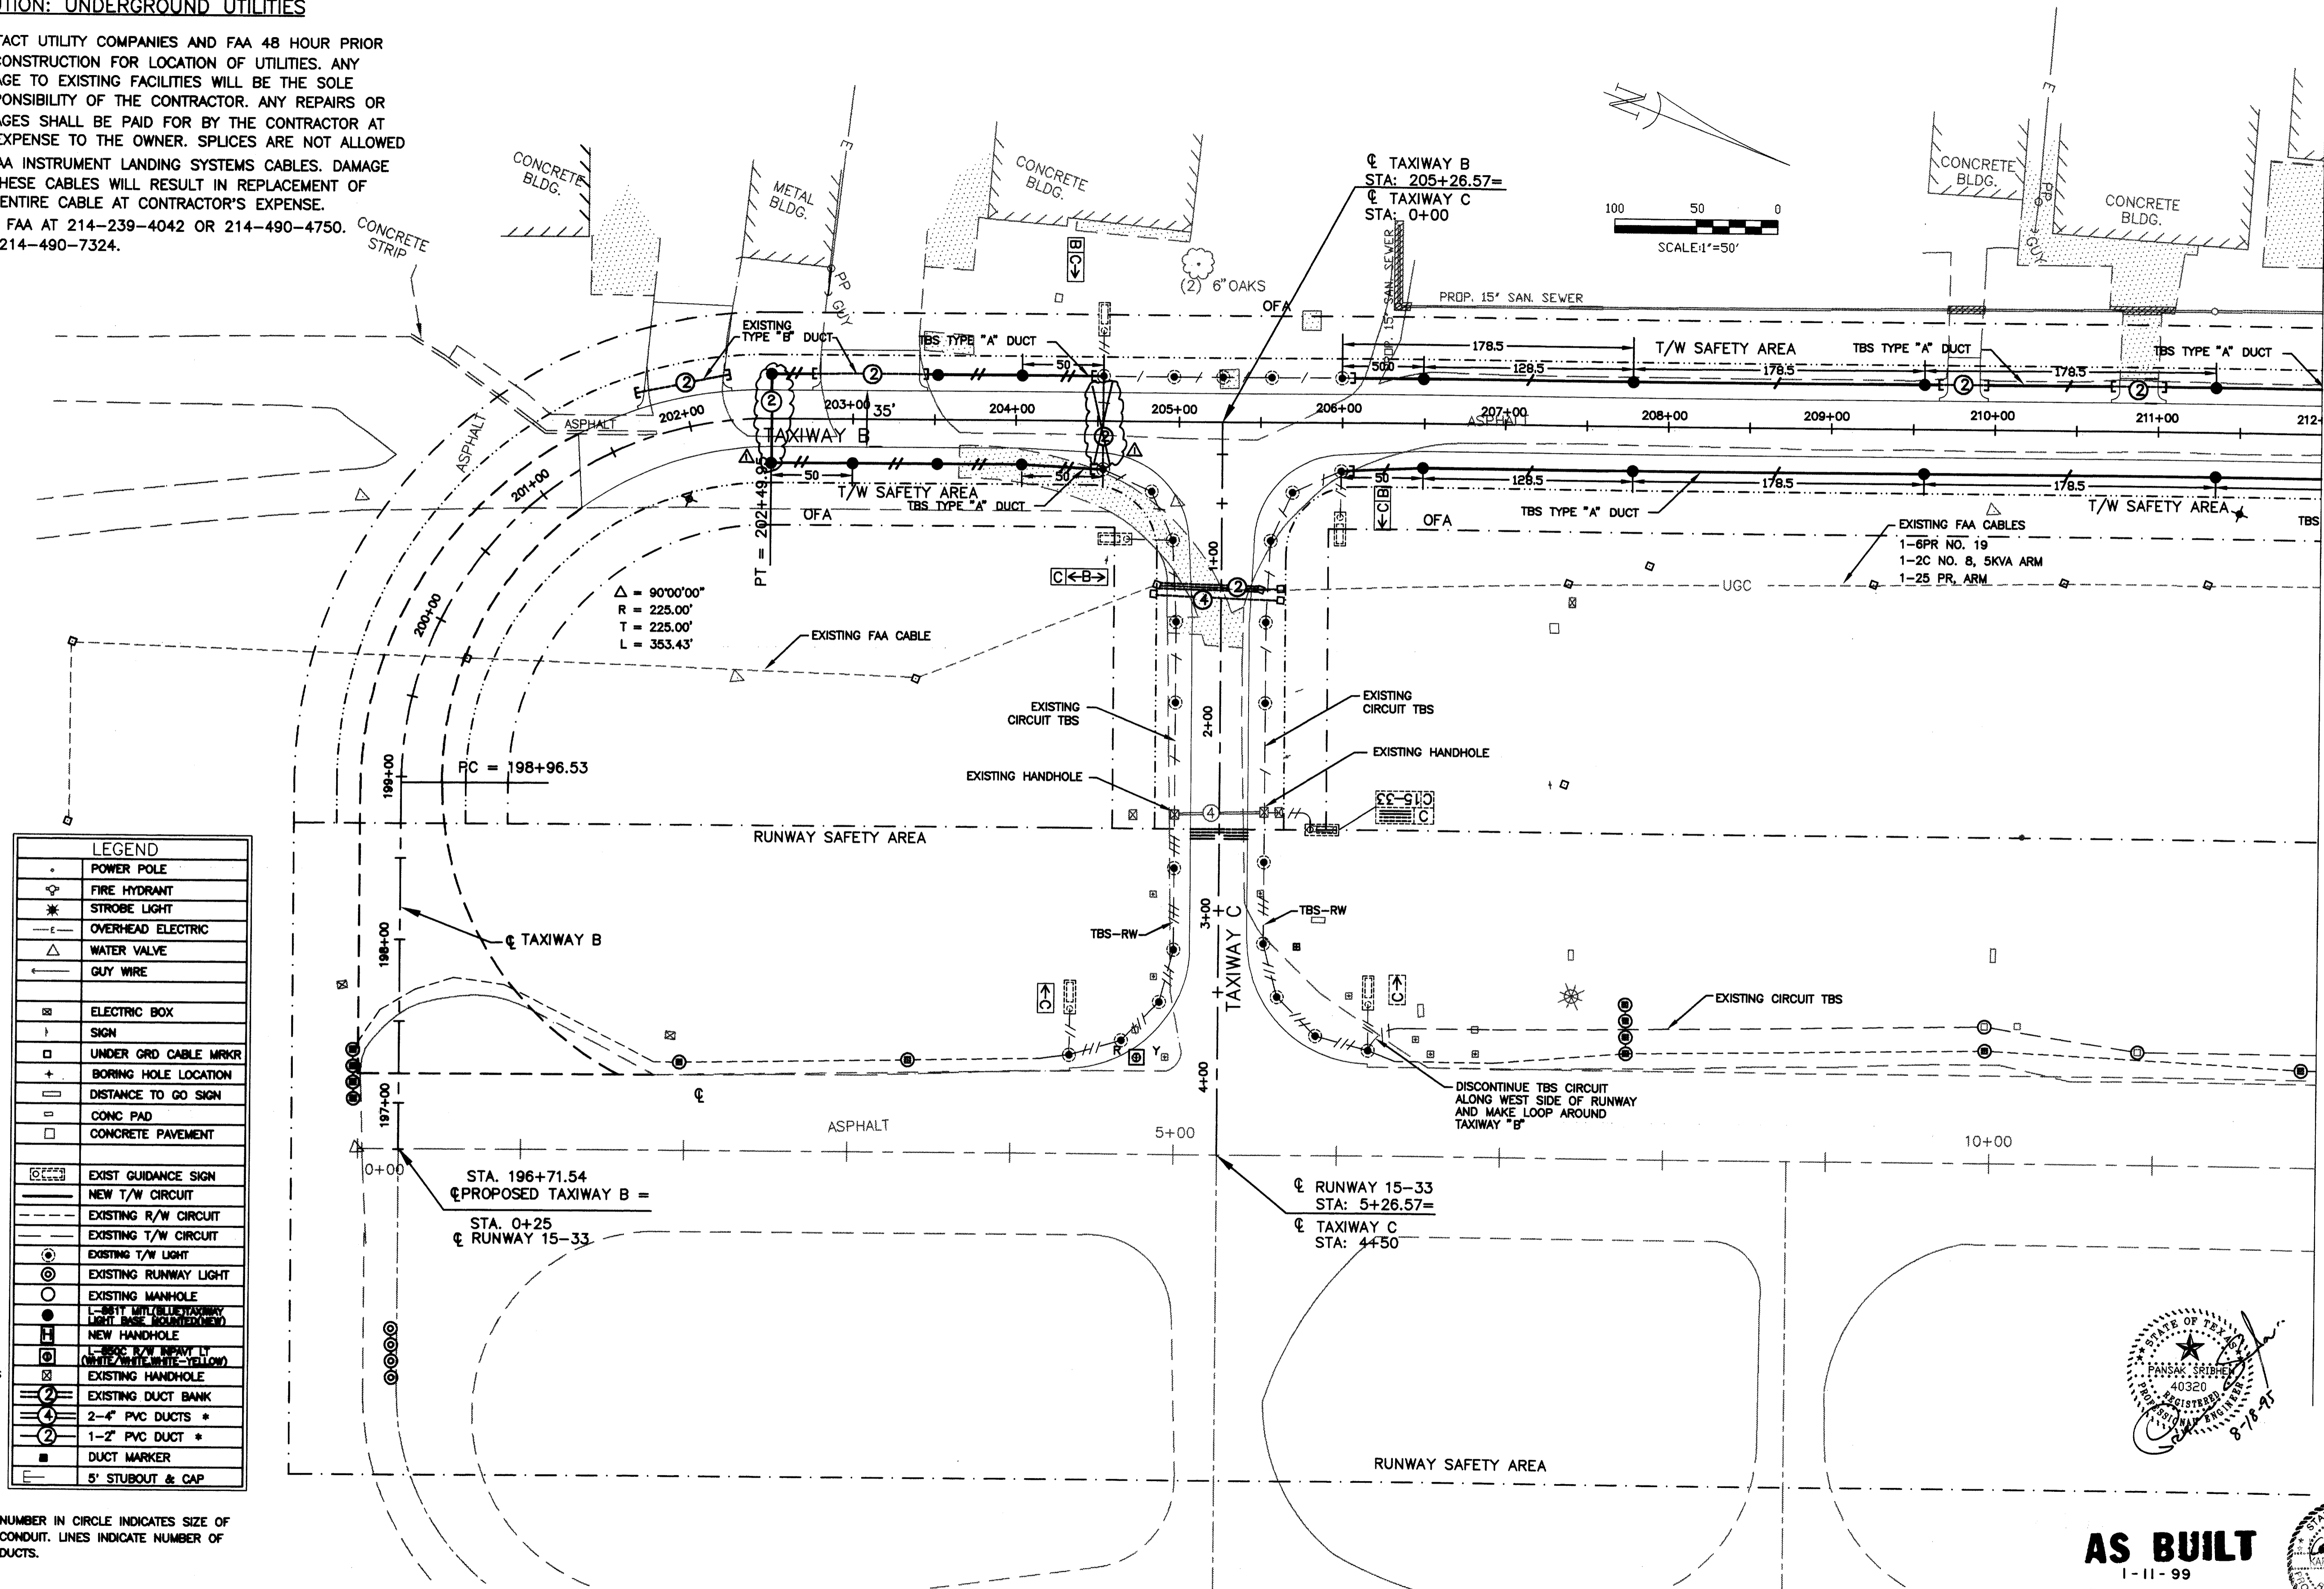

LEGEND	
○	POWER POLE
⊕	FIRE HYDRANT
★	STROBE LIGHT
—	OVERHEAD ELECTRIC
△	WATER VALVE
—	GUY WIRE
□	ELECTRIC BOX
⊢	SIGN
□	UNDER GRD CABLE MARKER
+	BORING HOLE LOCATION
—	DISTANCE TO GO SIGN
□	CONC PAD
□	CONCRETE PAVEMENT
⊞	EXIST GUIDANCE SIGN
—	NEW T/W CIRCUIT
---	EXISTING R/W CIRCUIT
---	EXISTING T/W CIRCUIT
⊙	EXISTING T/W LIGHT
⊙	EXISTING RUNWAY LIGHT
○	EXISTING MANHOLE
○	L-861T WITH (BLUE) HAWKEYE LIGHT BASE (ROUND/NEW)
⊞	NEW HANDHOLE
⊞	L-860C R/W INVERT LY (WHITE/WHITE-YELLOW)
⊞	EXISTING HANDHOLE
⊞	EXISTING DUCT BANK
⊞	2-4" PVC DUCTS *
⊞	1-2" PVC DUCT *
■	DUCT MARKER
—	5' STUBOUT & CAP

ALTERNATE NO. 4
 L-853 ELEVATED RETROREFLECTIVE EDGE MARKER
 NOTE: ALTERNATE NO. 4 CONSISTS OF PLACING REFLECTIVE MARKERS IN LIEU OF L-861T EDGE LIGHTS

* NUMBER IN CIRCLE INDICATES SIZE OF CONDUIT. LINES INDICATE NUMBER OF DUCTS.

MATCH LINE - SEE SHEET 42




AS BUILT
1-11-99



DESIGN: R.V.C.	TXDOT NO. 9842 ADDSN	1-11-99	AS BUILT	MG
DRAWN: MTR	APP. NO. 2-19-0063-02			
CHECKED: E.S.A.	BID NO. 95-12-98-04			
SCALE: 1" = 50'	JOB NO. E708024.70	Date	Revisions	By

Greiner, Inc.
Greiner, Inc.
Fort Worth, Texas

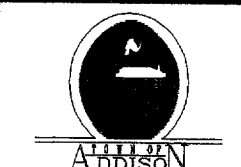

ADDISON AIRPORT

ADDITIVE ALT. NO. 3/4 - TAXIWAY "B"
LIGHTING LAYOUT - STA. 201+50 TO 212+00

SHEET 41
DATE: AUG 1996