


NOTE: VERIFY LOCATION OF EXISTING MC FIBRE OPTICS LINE IN THIS AREA. MAINTAIN A MINIMUM OF 5' BETWEEN IRRIGATION MAIN LINE AND FIBRE OPTICS LINE. NOTIFY D.A.R.T. OF CONFLICTS.


SLEEVE AS SCHEDULED: SLEEVE AND PIPE MUST BE INSTALLED PRIOR TO CONSTRUCTION OF TRANSIT PLATFORM. COORDINATE WITH OTHER CONTRACTORS. SLEEVE MUST BE EXTENDED 12" MIN. INTO PLANTER.

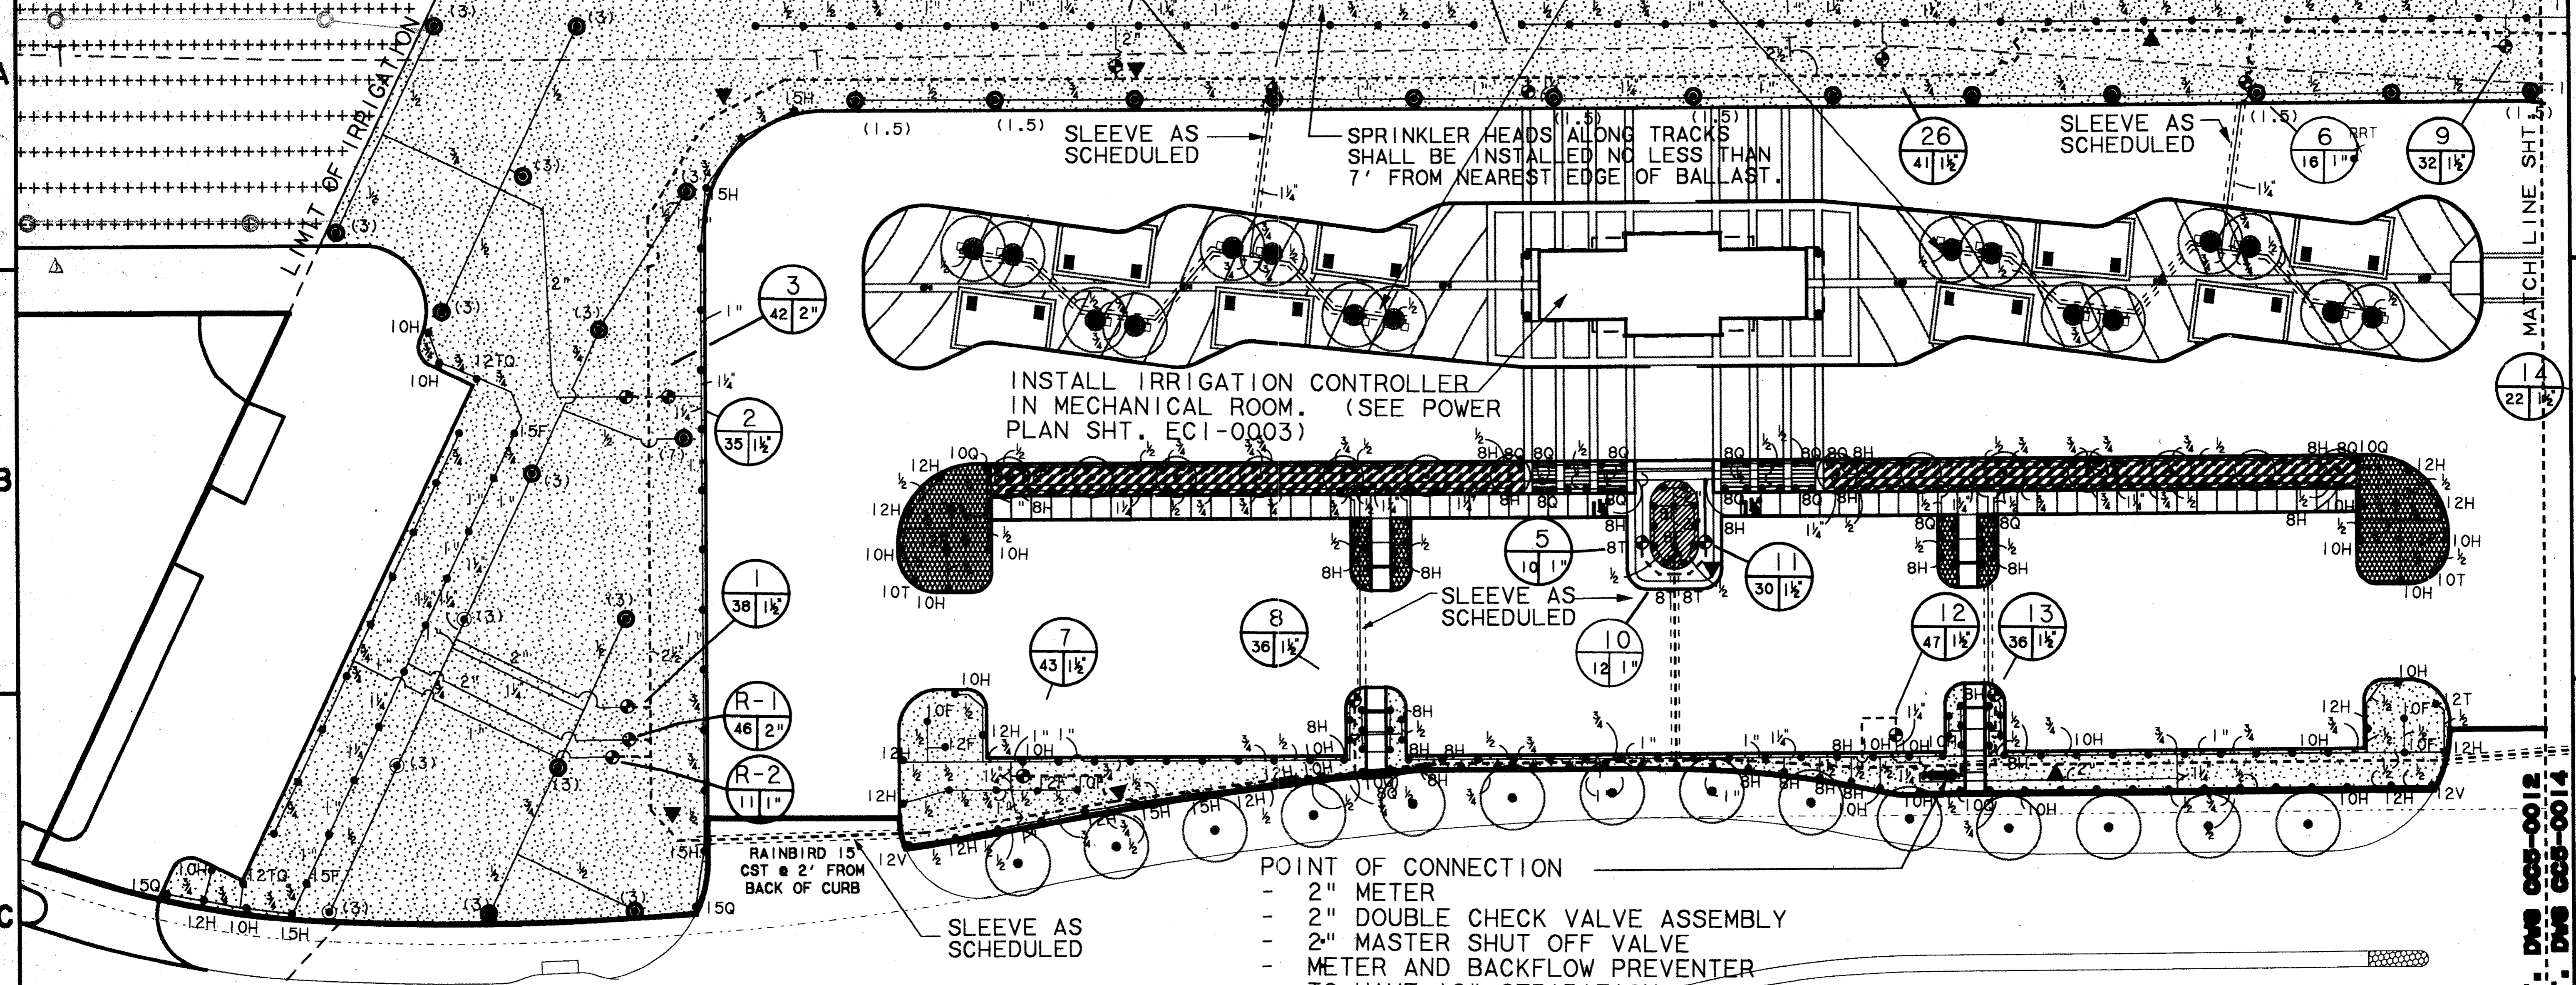

NOTE: REFER TO DRAWING LC2-0005 FOR LEGEND & SLEEVE SCHEDULE

ARAPAHO ROAD

CONFORMED

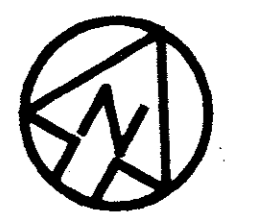

SCALE (1 IN FEET)


HALFF ASSOCIATES, INC.
IRRIGATION CONSULTANTS
CONTRACT SHEET No. 45 OF 95

REV	DATE	DESCRIPTION	BY	ENG	CHK	APP	REV	DATE	DESCRIPTION	BY	ENG	CHK	APP
△	8/30/99	RECORD (AS BUILT) DRAWING	RDM		JLM		△						
△							△						
△							△						
△							△						
△							△						



SWA Group
2211 North Lamar
Dallas, Texas 75202
214-954-0016
Landscape Architecture
Site Planning
Urban Design

WLA
WENDY LOPEZ & ASSOCIATES, INC.
ENGINEERING • SURVEYING • CONSTRUCTION SERVICES
1825 MARKET CENTER BLVD - SUITE 510
DALLAS, TEXAS 75207
(214) 748-7777

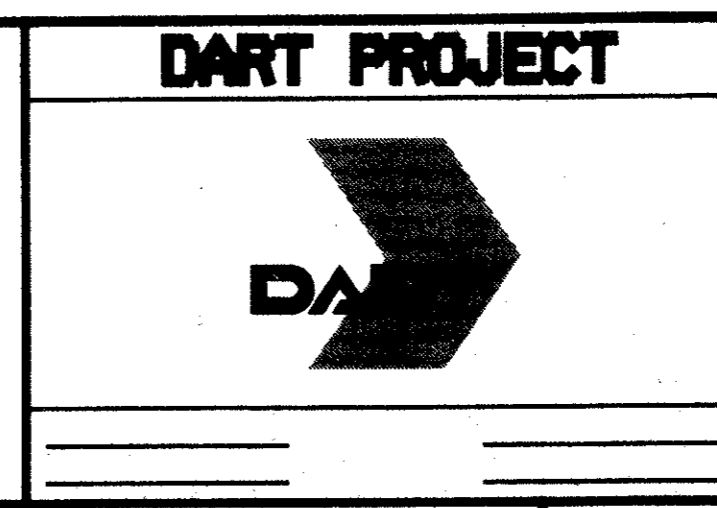

SCALE 1"=20'-0"
DRAWN L. HUBBES
DESIGNED B. BRISTOV
CHECKED B. BRISTOV
IN CHARGE V. STEVENS
DATE 14 AUGUST 97

ADDISON TRANSIT CENTER IRRIGATION PLAN
CONTRACT C-97000136
DWG No. CCS-0012
REV 01

\$\$\$SYTIME\$\$\$\$\$
 \$\$\$PRF\$\$\$
 \$\$\$USERNAME\$\$\$
 \$\$\$ROT\$\$\$
 \$\$\$PEN\$\$\$
 \$\$\$FILE6\$\$\$
 \$\$\$FILE7\$\$\$
 \$\$\$FILE8\$\$\$
 \$\$\$FILE9\$\$\$
 \$\$\$FILE10\$\$\$
 \$\$\$FILE11\$\$\$
 \$\$\$FILE12\$\$\$
 \$\$\$FILE13\$\$\$
 \$\$\$FILE14\$\$\$
 \$\$\$FILE15\$\$\$

MATCH LINE SHT. DWG CCS-0012
 MATCH LINE SHT. DWG CCS-0014