



0 5 10 15 20 30 40 60  
SCALE (IN FEET)

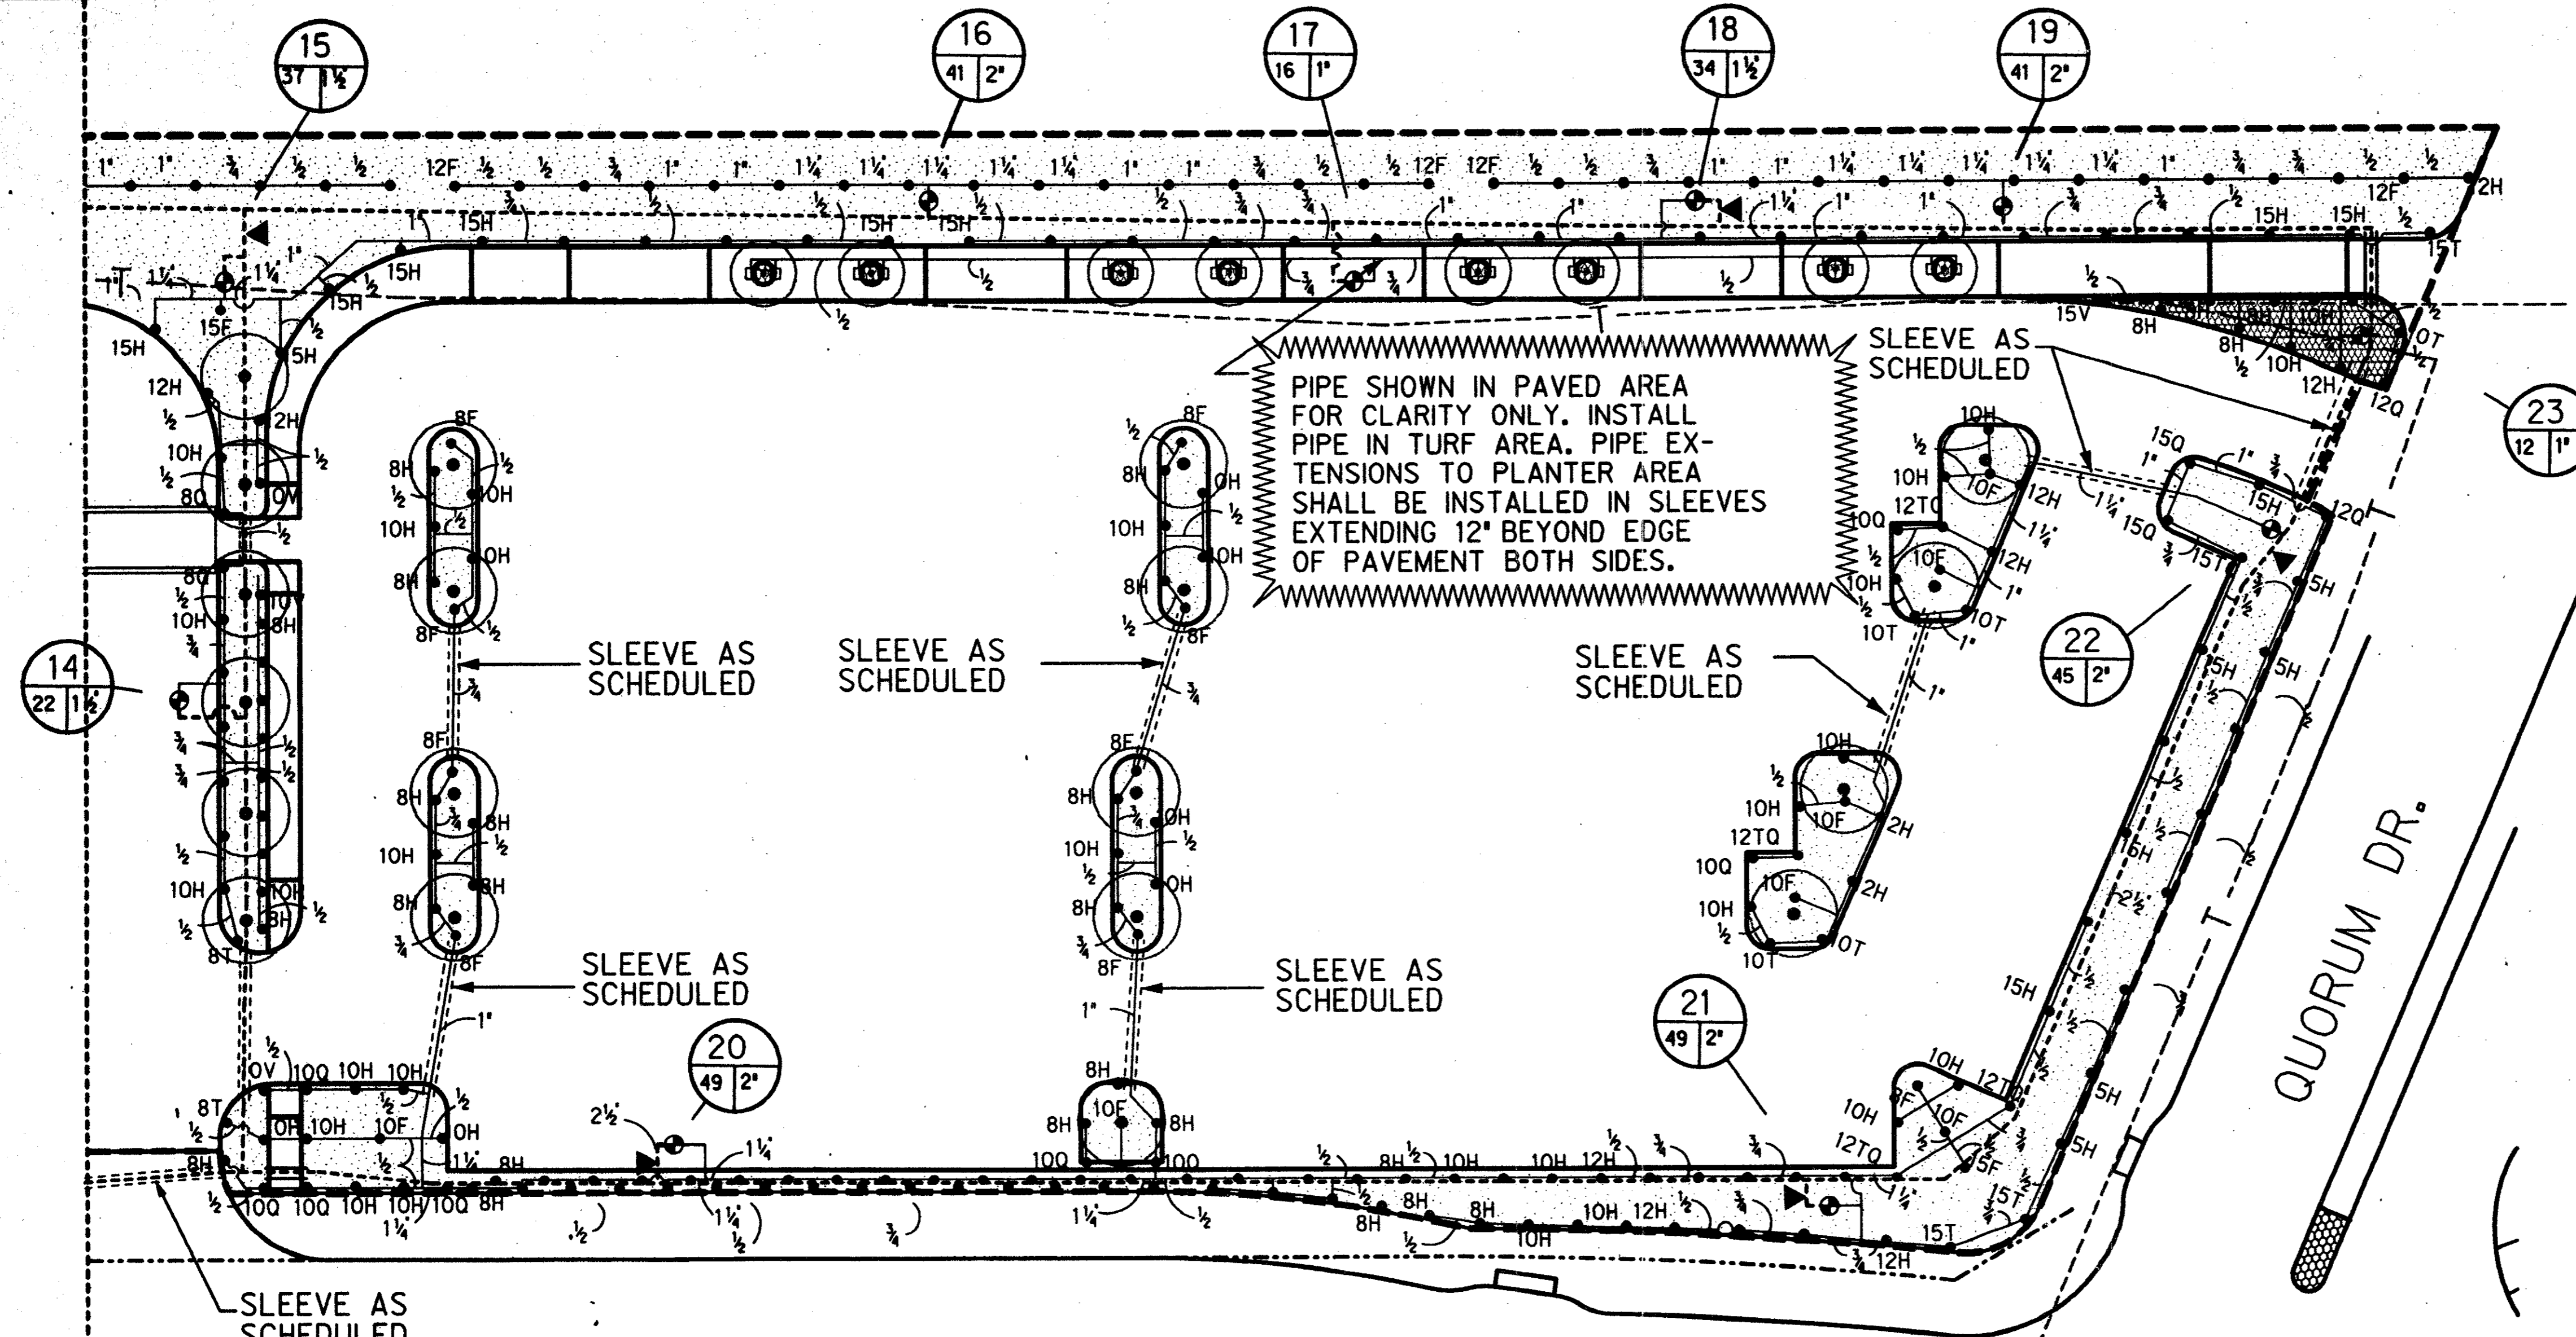

**NOTE:**  
1) REFER TO DRAWING LC2-0005 FOR LEGEND & SLEEVE SCHEDULE  
2) INSTALL TWO(2) IRRIGATION BUBBLERS AS SPECIFIED, AT OPPOSITE SIDES OF TREE ROOT BALL (TYP.)

Record (As-built) Certification  
Having checked this submission, we certify that it conforms to the requirements of the contract in all respects, except as otherwise indicated.  
Contract No. 97000136  
Date of Certification: 8/14/97  
Tom Kinder  
President

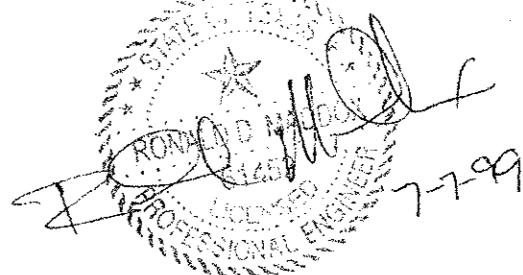

MATCH LINE SHT. DWG CC5-0012  
MATCH LINE SHT. DWG CC5-0014

THE SEAL APPEARING ON THIS DOCUMENT WAS AUTHORIZED BY E. BRIAN BRISTOW, L.I. 4639 ON AUG. 13, 1997. ALTERATION OF A SEALED DOCUMENT WITHOUT PROPER NOTIFICATION TO THE RESPONSIBLE LICENSED IRRIGATOR IS AN OFFENSE UNDER THE TEXAS LICENSED IRRIGATORS ACT. THE RECORD COPY OF THIS DRAWING IS ON FILE AT THE OFFICES OF HALFF ASSOCIATES, INC., 8616 NORTHWEST PLAZA DRIVE, DALLAS TEXAS 75225



**CONFORMED**

**HALFF ASSOCIATES, INC.**  
IRRIGATION CONSULTANTS

CONTRACT SHEET No. 46 OF 95

ADDISON  
TRANSIT CENTER  
IRRIGATION PLAN

REV	DATE	DESCRIPTION	BY	ENG	CHK	APP	REV	DATE	DESCRIPTION	BY	ENG	CHK	APP

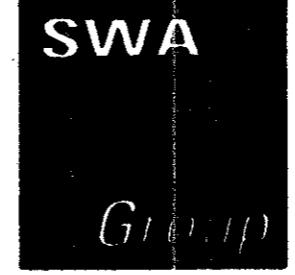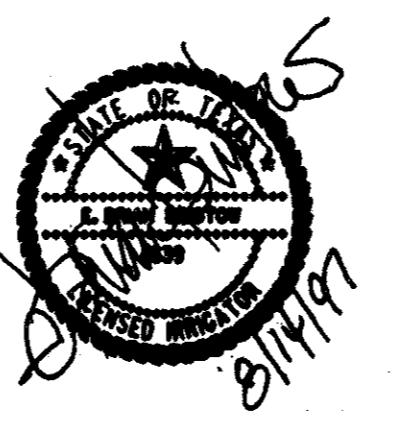


2211 North Lamar  
Dallas, Texas 75202  
214-954-0016

Landscape  
Architecture  
Site Planning  
Urban Design



WENDY LOPEZ & ASSOCIATES, INC.  
ENGINEERING - SURVEYING - CONSTRUCTION SERVICES  
303 MARKET CENTER BLVD - SUITE 20  
DALLAS, TEXAS 75201  
(214) 746-7777

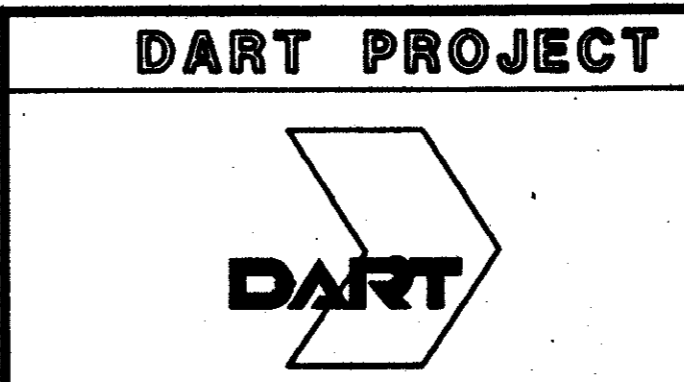

SCALE 1"=20'-0"  
DRAWN L. HUGHES  
DESIGNED B. BRISTOW  
CHECKED B. BRISTOW  
IN CHARGE V. STEVENS  
DATE 14 AUGUST 97

CONTRACT C-97000136  
DWG No. CC5-0014  
REV 0