

PLANS FOR THE CONSTRUCTION OF
PAVING, STORMWATER, WATER, WASTEWATER,
SIGNALIZATION AND STREETScape IMPROVEMENTS FOR

ARAPAHO ROAD

FROM ADDISON ROAD TO DALLAS NORTH TOLLWAY




T O W N O F
ADDISON

RECORD DOCUMENTS 6/9/2000

THESE RECORD DOCUMENTS HAVE BEEN PREPARED BASED ON INFORMATION PROVIDED BY OTHERS. THE CONSULTANT HAS NOT VERIFIED THE ACCURACY AND/OR COMPLETENESS OF THIS INFORMATION AND SHALL NOT BE RESPONSIBLE FOR ANY ERRORS OR OMISSIONS THAT MAY BE INCORPORATED AS A RESULT OF ERRONEOUS INFORMATION PROVIDED BY OTHERS.

SHEET NO.	INDEX OF DRAWINGS
	COVER SHEET
Q-1 to Q-4	QUANTITY SHEETS
R-1 to R-3	RIGHT-OF-WAY PLANS
D-1 to D-3	DEMOLITION PLANS
CS-1 to CS-7	CONSTRUCTION SEQUENCING PLANS
P-1 to P-2	PAVING TYPICAL SECTIONS
P-3 to P-14	PAVING PLANS, PROFILES & DETAILS
P-15	RETAINING WALL PLAN, PROFILE & DETAIL
P-16 to P-19	STRIPING PLANS
ST-1	DRAINAGE AREA MAP
ST-2 to ST-5	STORMWATER CALCULATIONS
ST-6 to ST-17	STORMWATER PLANS, PROFILES & DETAILS
W-1 to W-11	WATER & WASTEWATER PLAN/PROF. & DET.
S-1 to S-14	SIGNALIZATION PLANS & DETAILS
X-1 to X-10	CROSS SECTIONS
LA-1 to LA-7	LANDSCAPE LAYOUT PLANS
LC-1 to LC-4	LANDSCAPE CONSTRUCTION DETAILS
PL-1 to PL-7	PLANTING PLANS & DETAILS
IR-1 to IR-6	IRRIGATION PLANS
SE-1 to SE-6	SITE-ELECTRICAL PLANS

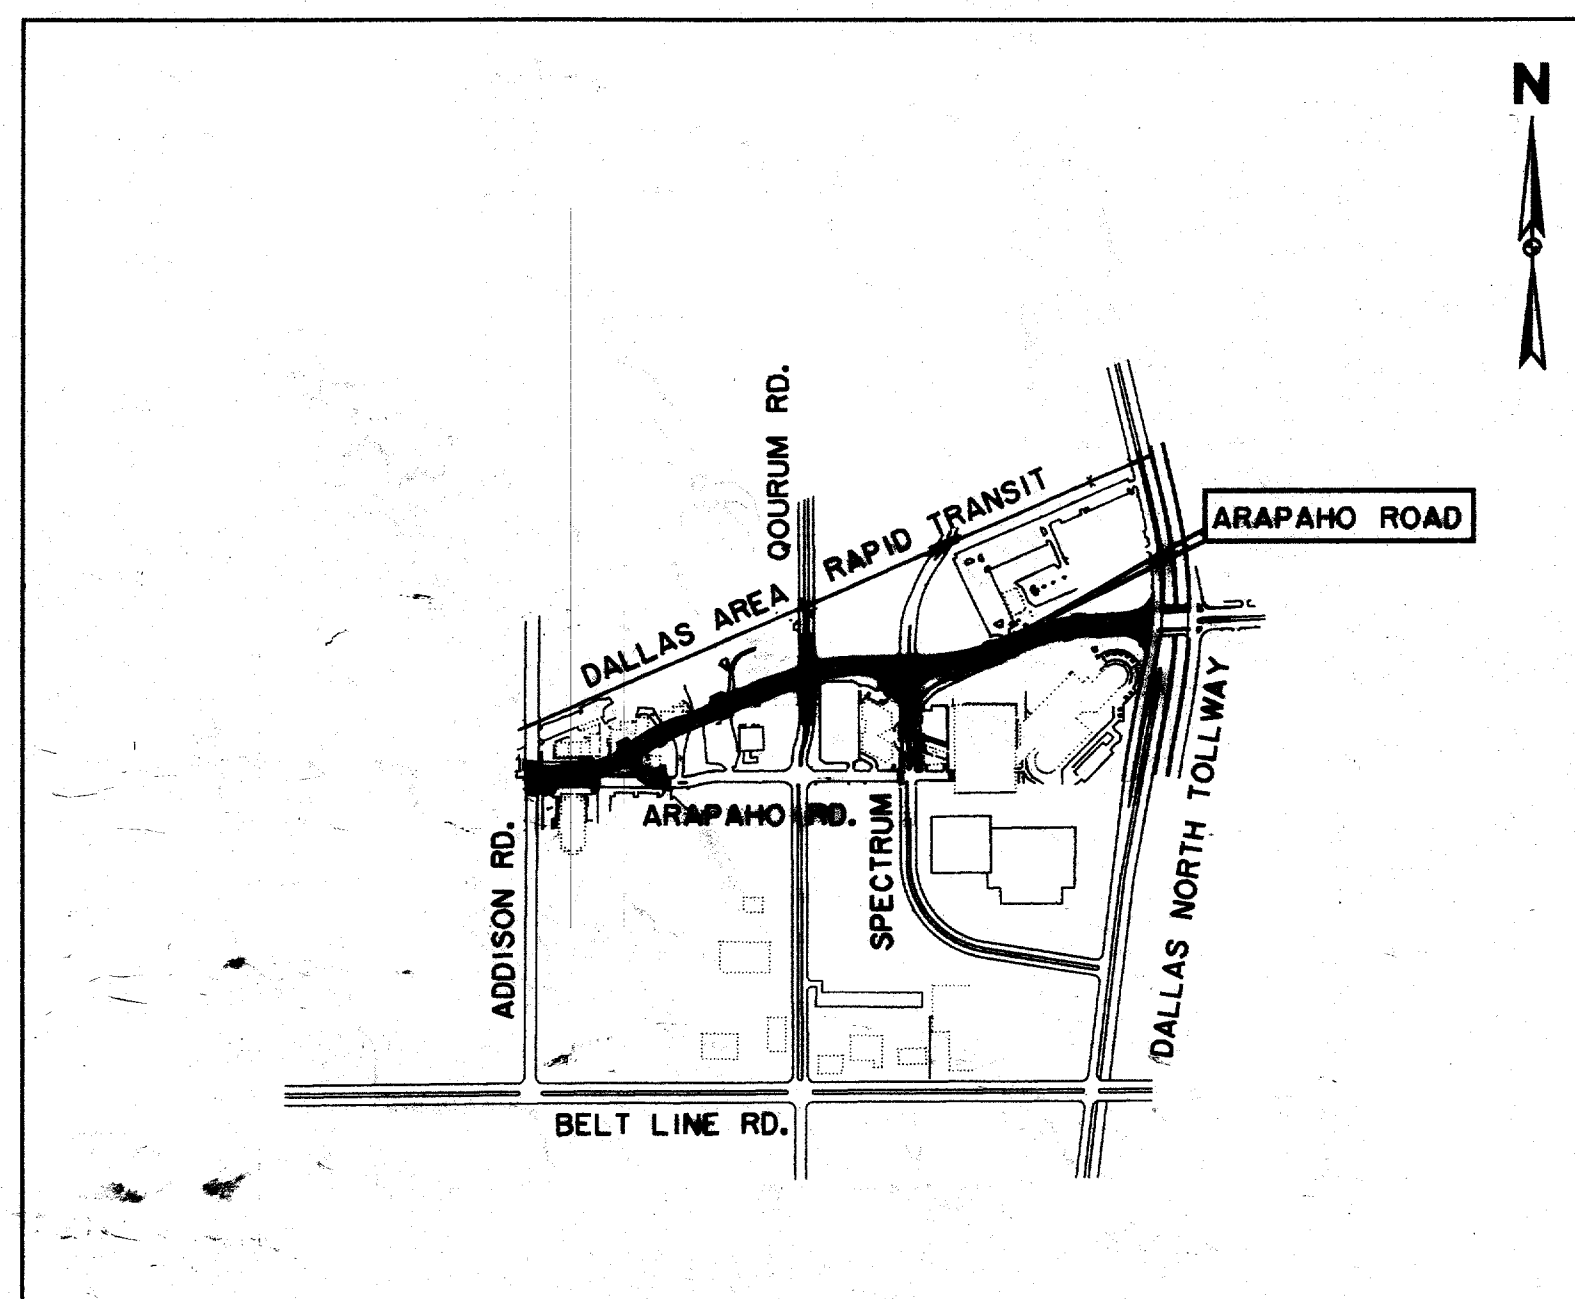


LOCATION MAP

OWNER:
TOWN OF ADDISON
DEPARTMENT OF PUBLIC WORKS
16801 WESTGROVE
P.O. BOX 144
ADDISON, TEXAS 75001
(972) 450-7018

ENGINEER:
HUITT-ZOLLARS, INC.
3131 MCKINNEY AVE., SUITE 600
DALLAS, TEXAS 75204
(214) 871-3311

LANDSCAPE ARCHITECT:
MESA DESIGN GROUP
3100 MCKINNON ST., SUITE 905
DALLAS, TEXAS 75201
(214) 871-0568

THE SEAL APPEARING ON THIS DOCUMENT WAS AUTHORIZED BY KENNETH A. ROBERTS, P.E. 55446 ON OCTOBER 24, 1997.

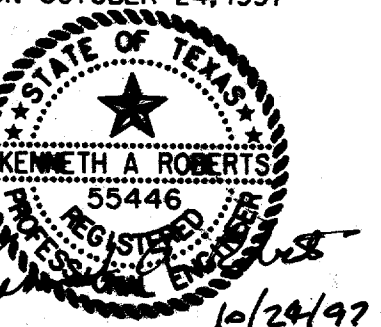

ARAPAHO ROAD