

PLEASE REFER ALL INQUIRIES TO OUR SHOP ORDER NUMBER ESI-04-150

MYERS POWER PRODUCTS

725 E. HARRISON ST., CORONA, CA. 92879

CAT. NO. _____
 SEE DRAWING _____ FOR WIRING DIAGRAM
 240/480 V 1 Ø 3 W 70 AMPS
 UTILITY _____ 14.000 AIC
 DISTRIBUTOR ELECTROL SYSTEM
 CONTRACTOR _____
 FINISH COLOR LT. GREEN WHITE DK. GREEN
 OTHER
 CALTRANS YES NO
 U.L. LABEL SERVICE EQUIPMENT INDUSTRIAL CONTROL CABINET & BOXES
 NAMEPLATES BREAKER I.D. CONTRACT NO. _____
 PHENOLIC LOCATION _____
 POWER POLE NO. _____
 PHOTOCELL REQUIRED YES NO PHOTOCELL PROVISIONS YES NO

MYERS METERED UNDERGROUND SERVICE PEDESTAL

NEMA 3R CONSTRUCTION-STAINLESS STEEL HARDWARE
 12 GAUGE STEEL CONSTRUCTION.
 ALL FACTORY WIRING CODE GAUGE COPPER CONDUCTORS WITH 600V INSULATION
 SERVICE TERMINATIONS NO. 6 AWG TO 250 MCM CU/AL



MATERIAL LIST

NO	DESCRIPTION	QTY	AMP	POLE	KAIC	MYERS P/N
	SERV. DISC.	1	70	2	14K	EHD2070L
SUB-BREAKERS AS INDICATED						
INT	PLUG-IN INTERIOR	1	200	3Ø	240V	CUTLER-HAMMER
	TRANSFORMER	1	25KVA	1PH 480V		ACME
	HOA SWITCH	1	10	SPST	120V	TELEMECANIQUE
	EH CONTACTOR	1	200	2	120V	GE# CR360L
	PE RECEPT.	1	15		120V	


DATE: 04/06/04 BY: JLT S/O #

NOTE 1) PROVIDE PEDESTAL SUPPORT FOR CABINET, REFER TO ED(8)-03 FOR FOUNDATION NOTES AND CONCEPT.

NOTE 2) SEE PANEL SCHEDULE LDC "A" AND "B" FOR ADDITIONAL INFORMATION.

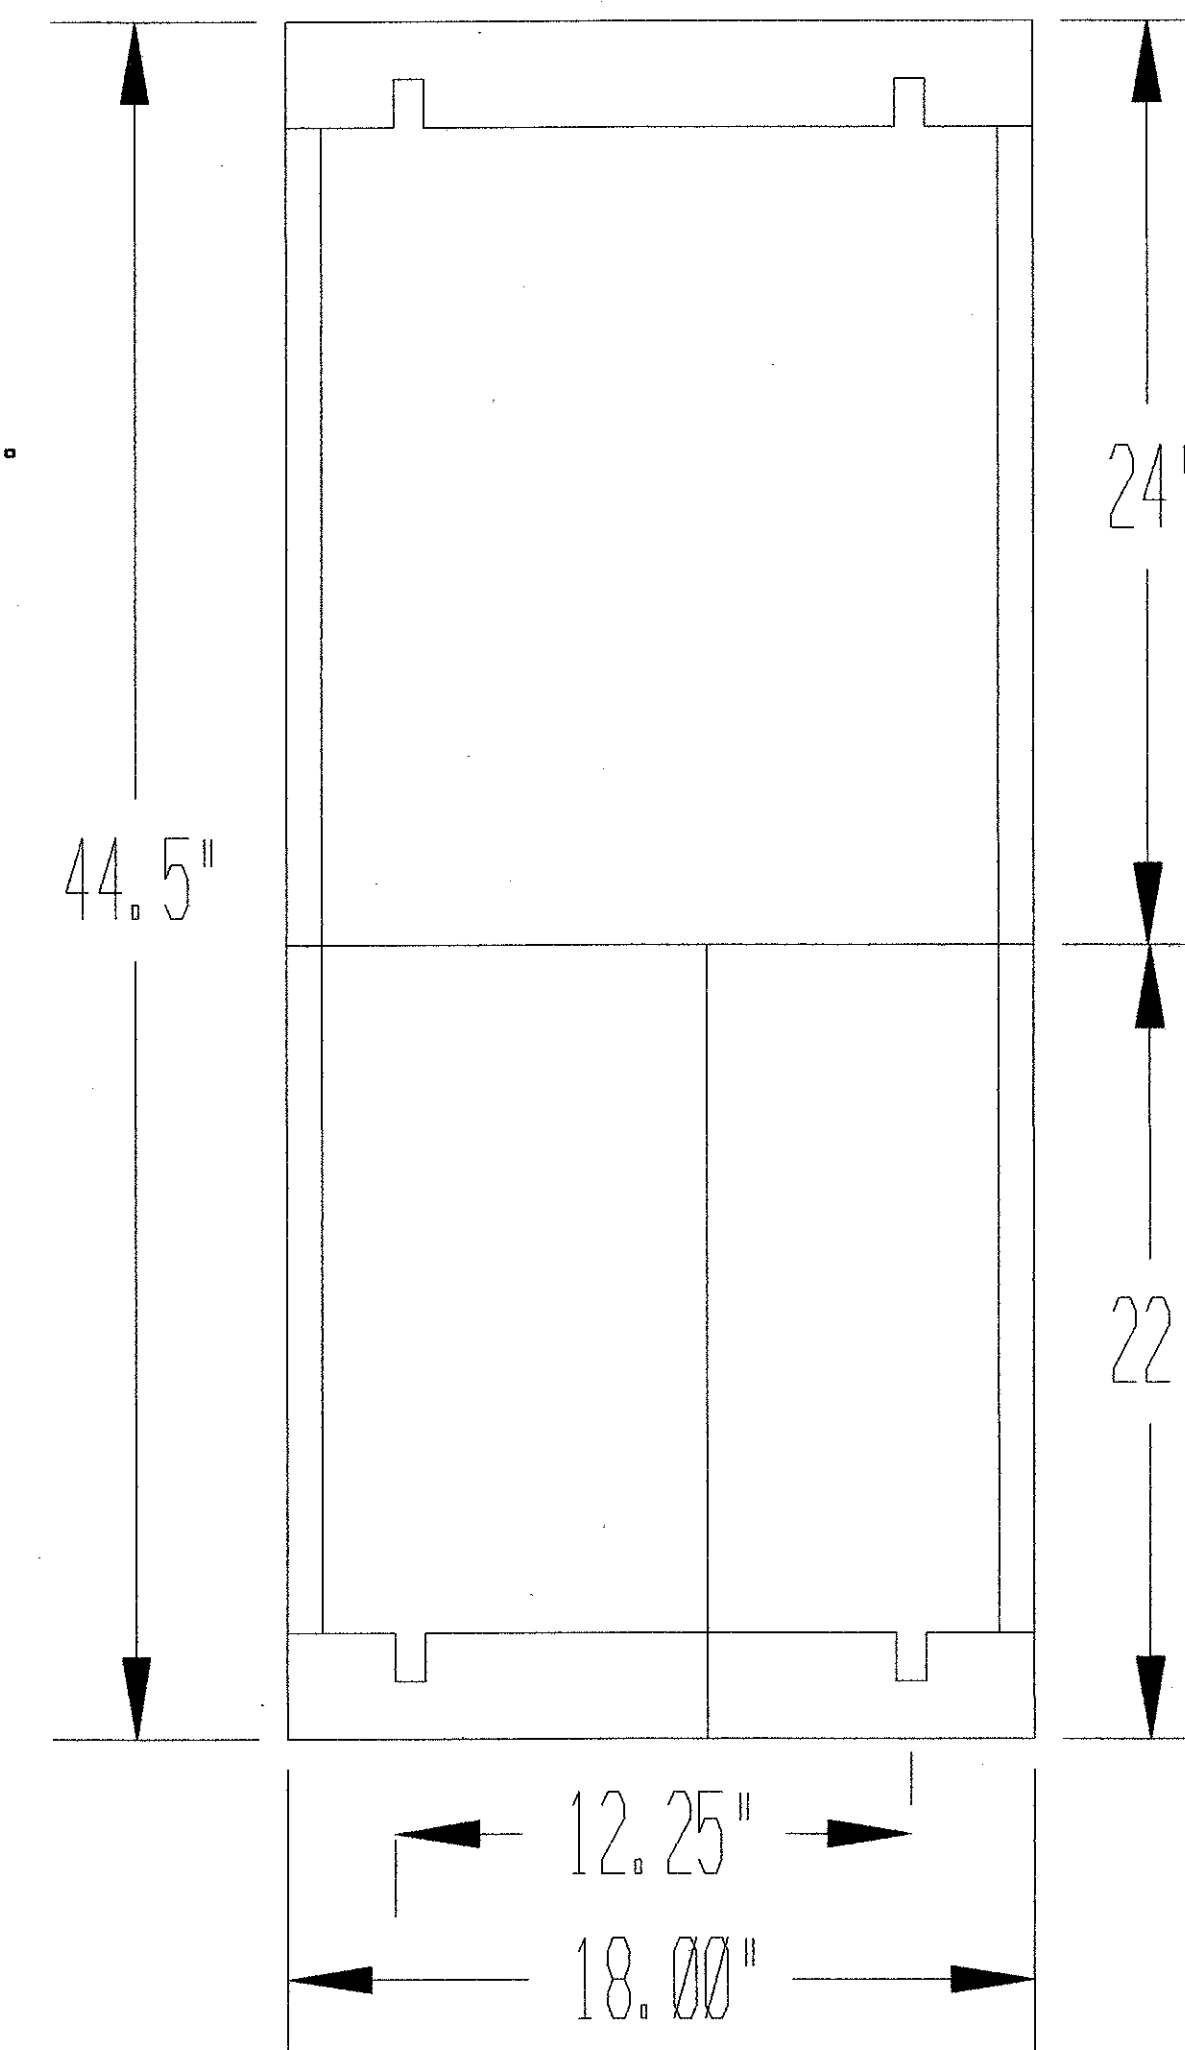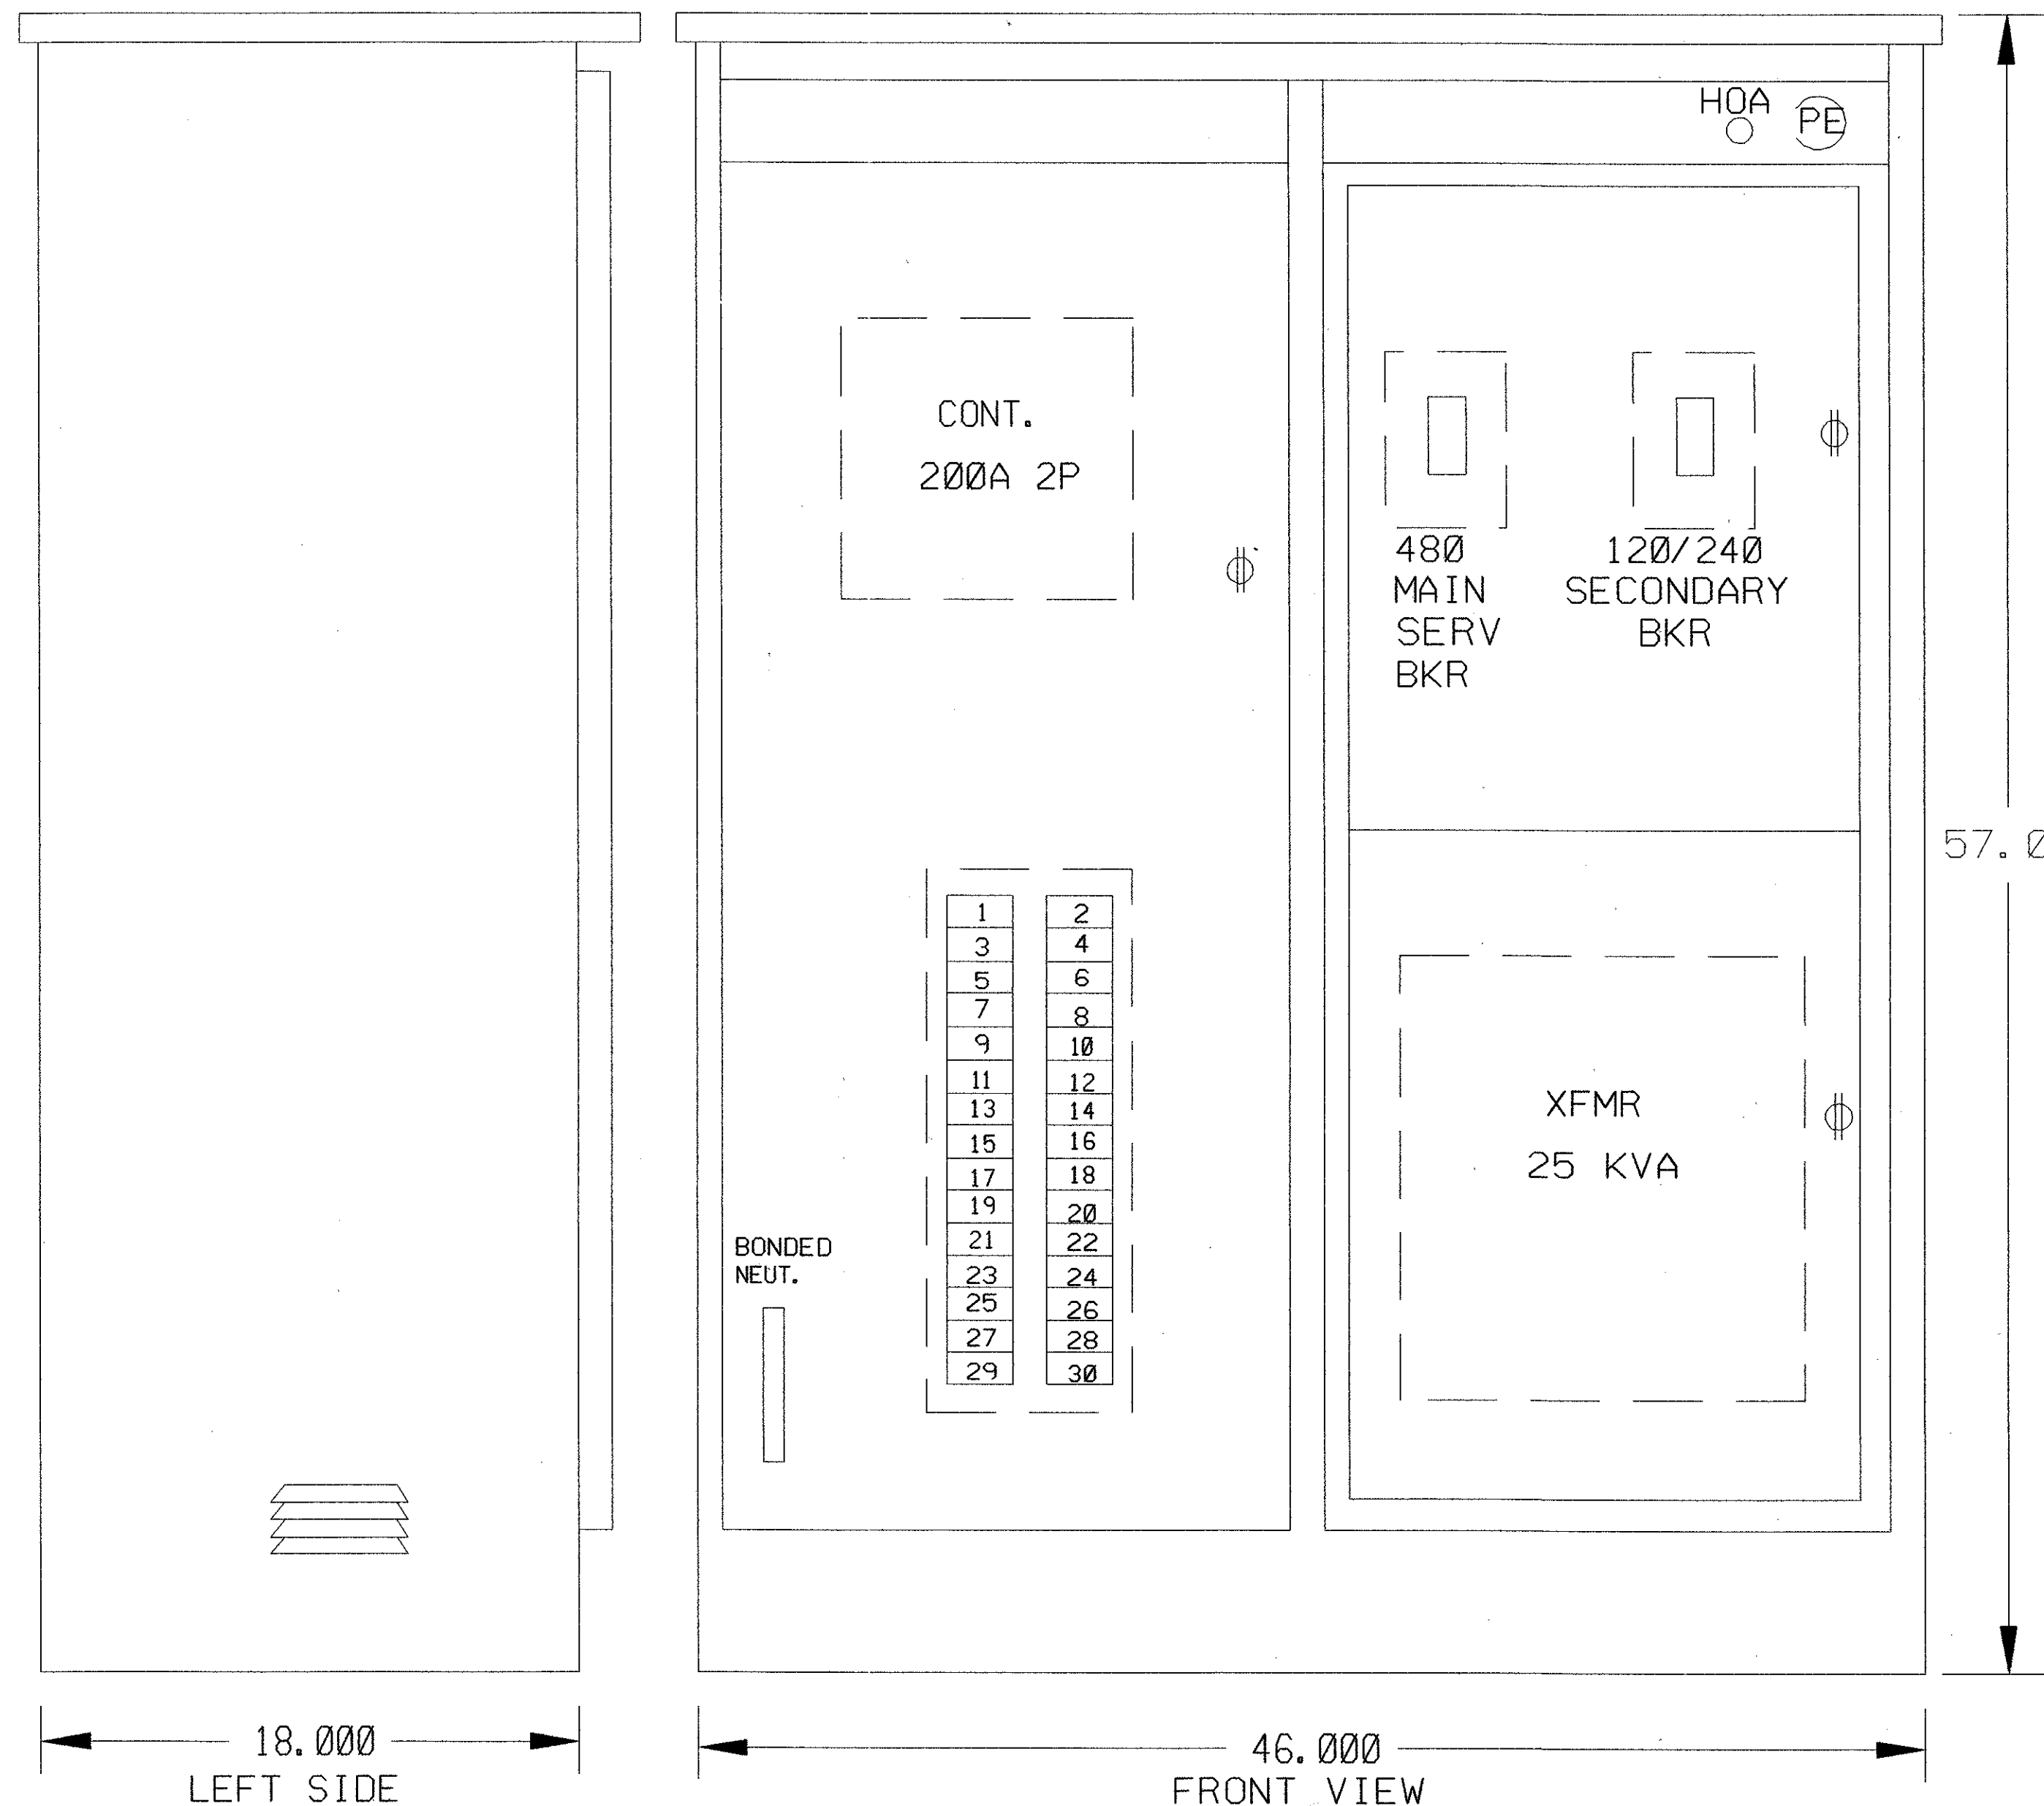

MOUNTING SLOT DETAIL

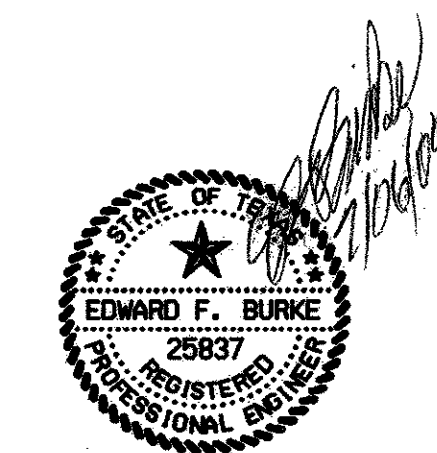

NO.		DATE		REVISION		APPROV.	
URS GREYSTONE CENTRE 3010 LBJ FREEWAY, SUITE 1300 DALLAS, TX 75234 ARAPAHO ROAD - PHASE III SURVEYOR BOULEVARD TO ADDISON ROAD BRIDGE LIGHTING DETAILS SHEET 3 of 3 TOWN OF ADDISON, TEXAS							
Design	EFB	Drawn	DT	DATE	SCALE	PROJECT NO.	SHEET NO.
Check	Check	Check	Check	05-07-04		25768	BL-13

E/S THIS DOCUMENT, THE IDEAS, AND DESIGNS, WHICH CONTAIN PROPRIETARY AND CONFIDENTIAL INFORMATION INCORPORATED HEREIN, IS THE PROPERTY OF ELECTROL SYSTEMS, INC. WHICH MUST NOT BE DUPLICATED, USED OR DISCLOSED (IN WHOLE OR IN PART) WITHOUT THE EXPRESSED WRITTEN AUTHORIZATION OF ELECTROL SYSTEMS, INC.

CONTRACTOR: URS CORP.	FILE: M:\DWG002004	REVISION: NO REVISION	REVISION DATE:
DATE: 6 APRIL 04	PROJECT: ARAPAHO ROAD - LOAD DISTRIBUTION CENTERS A & B	TITLE: CUSTOM PANEL	REFERENCE # ESI-04-150-11
DRAWN BY: LCV	ELECTROL SYSTEMS, INC. 10623 SENTINEL DRIVE SAN ANTONIO, TX 78217 [210] 599-6485		
SCALE: NTS			

7/1/2004 3:32:24 PM

V:\rsd\01\data\projects\arapaho_road\bridge\lighting\detail\0415011\cylout.dgn