


SINGLE PHASE									
PANEL: LDC "A"			VOLTS: 240/120		WIRES: 3		MAIN: 100 A:		
CIRC. NO.	TRIP AMPS	NO. POLES	DESCRIPTION	AMPS		DESCRIPTION	CIRC. NO.	TRIP AMPS	NO. POLES
				L1	L2				
1	20		"B" FIXTURES NORTH	2.0		"B" FIXTURES SOUTH	2	20	
3	20	2	"B" FIXTURES NORTH		2.0	"B" FIXTURES SOUTH	4	20	2
5	20		"C" FIXTURES PED. HR	10.0		"C" FIXTURES SOUTH TB	6	20	
7	20	2	"C" FIXTURES PED. HR		10.0	"C" FIXTURES SOUTH TB	8	20	2
9	20		"C" FIXTURES PED. HR	10.0		"C" FIXTURES SOUTH TB	10	20	
11	20	2	"C" FIXTURES PED. HR		10.0	"C" FIXTURES SOUTH TB	12	20	2
13	20		"A2" FIXTURE S - ARCH	16.0		GFI RECEPT. S - ARCH	14	20	1
15	20	2	"A2" FIXTURE S - ARCH		16.0	GFI RECEPT. S - ARCH	16	20	1
17	20	1	"B" FIXTURE CONTROLLER	0.9		"E21" FIXTURE S - STINGER	18	20	
19	20		SPACE		0.9	"E21" FIXTURE S - STINGER	20	20	2
21	20		SPACE			SPACE	22	20	
23	20		SPACE			SPACE	24	20	
CONNECTED LOAD				74.2	73.2				
ESTIMATED DEMAND				66.2	65.2				

SINGLE PHASE									
PANEL: LDC "B"			VOLTS: 240/120		WIRES: 3		MAIN: 100 A:		
CIRC. NO.	TRIP AMPS	NO. POLES	DESCRIPTION	AMPS		DESCRIPTION	CIRC. NO.	TRIP AMPS	NO. POLES
				L1	L2				
1	20		"D" FIXTURES	14.8		"A & E" FIXTURES N - ARCH	2	20	
3	20	2	"D" FIXTURES		14.8	"A & E" FIXTURES N - ARCH	4	20	2
5	20		"D" FIXTURES	16.0		GFI RECEPT. N - ARCH	6	20	1
7	20	2	"D" FIXTURES		16.0	GFI RECEPT. N - ARCH	8	20	1
9	20		"D" FIXTURES	0.9		"E22" FIXTURE S - STINGER	10	20	
11	20	2	"D" FIXTURES		0.9	"E22" FIXTURE S - STINGER	12	20	2
13	20		SPACE			SPACE	14	20	
15	20		SPACE			SPACE	16	20	
17	20		SPACE			SPACE	18	20	
19	20		SPACE			SPACE	20	20	
21	20		SPACE			SPACE	22	20	
23	20		SPACE			SPACE	24	20	
CONNECTED LOAD				72.7	72.7				
ESTIMATED DEMAND				64.7	64.7				

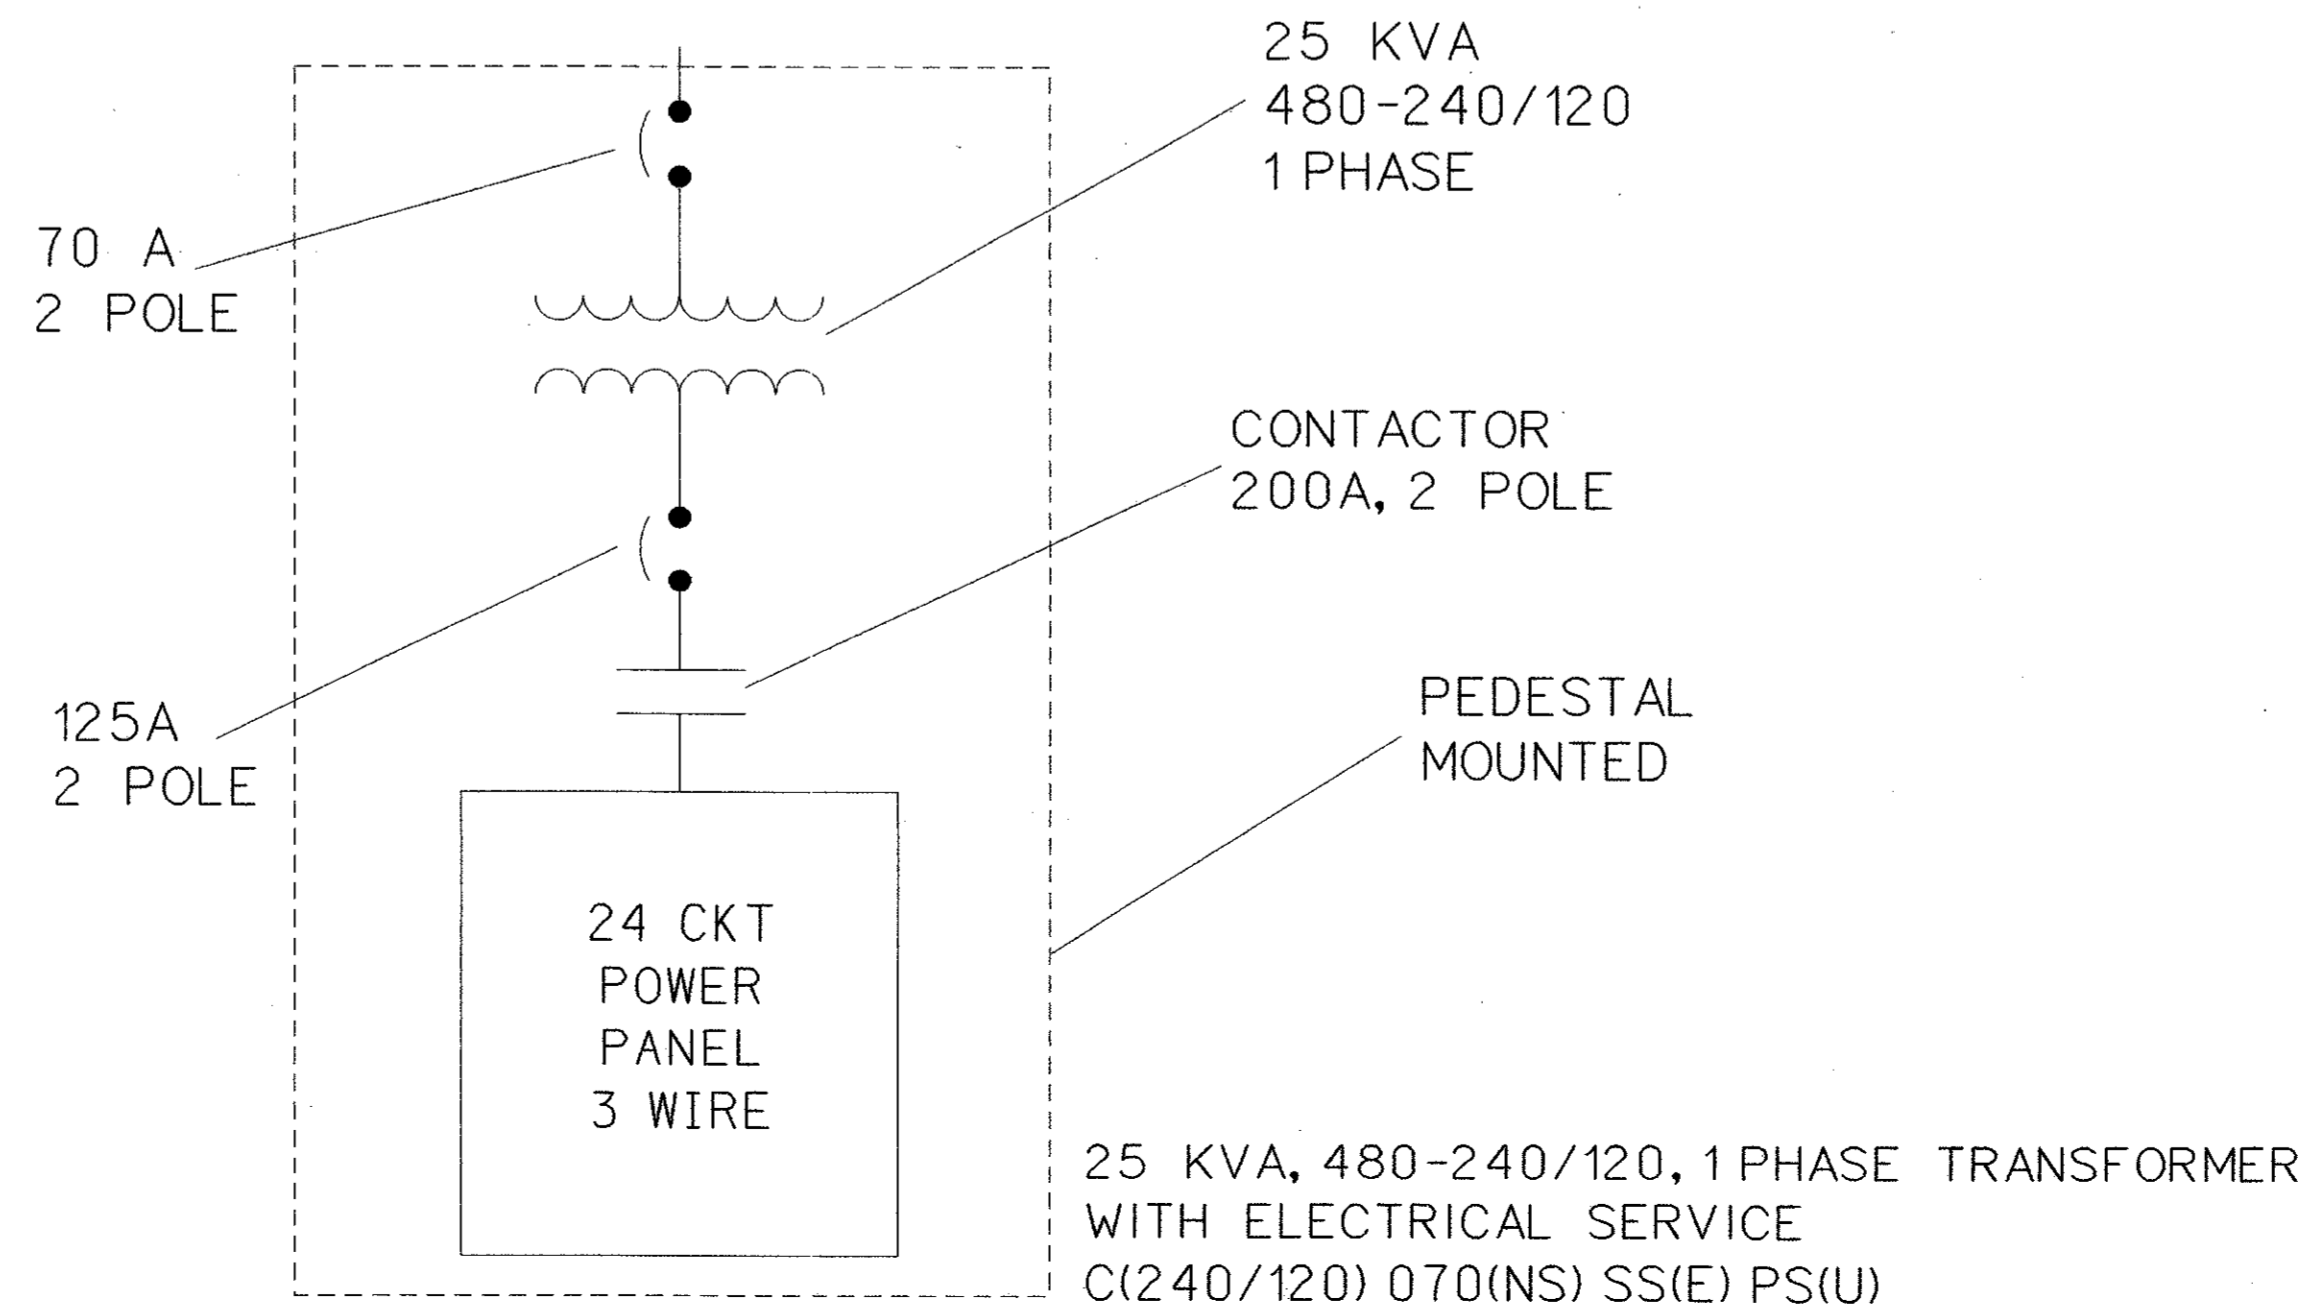

NO.		DATE	REVISION	APPROV.
URS				
GREYSTONE CENTRE 3010 LBJ FREEWAY, SUITE 1300 DALLAS, TX 75244				
ARAPAHO ROAD - PHASE III				
SURVEYOR BOULEVARD TO ADDISON ROAD				
BRIDGE LIGHTING PANEL SCHEDULE LDC "A" & "B"				
TOWN OF ADDISON, TEXAS				
Design	EFB	Drawn	DT	DATE
Check	Check	05-07-04	SCALE	PROJECT NO. SHEET NO.
			25768	BL - 24