

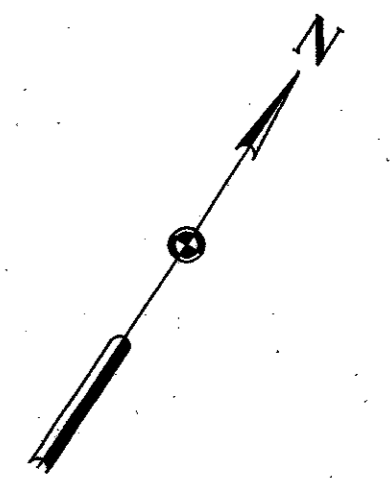


29-JUN-2004 13:02  
G:\25768-ph3\h1\cds\rf3ur01.dgn

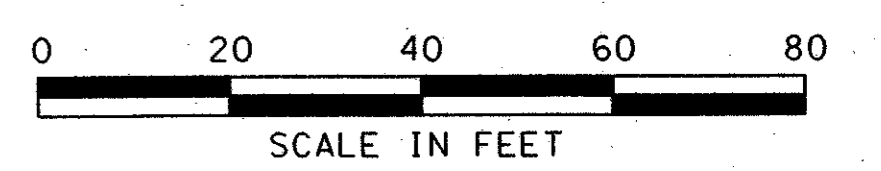

**LEGEND**

- OH — OVERHEAD LINES
- CO SANITARY SEWER CLEANOUT
- FH FIRE HYDRANT
- W WV WATER VALVE
- ⊗ WM WATER METER
- ⊗ GM GAS METER

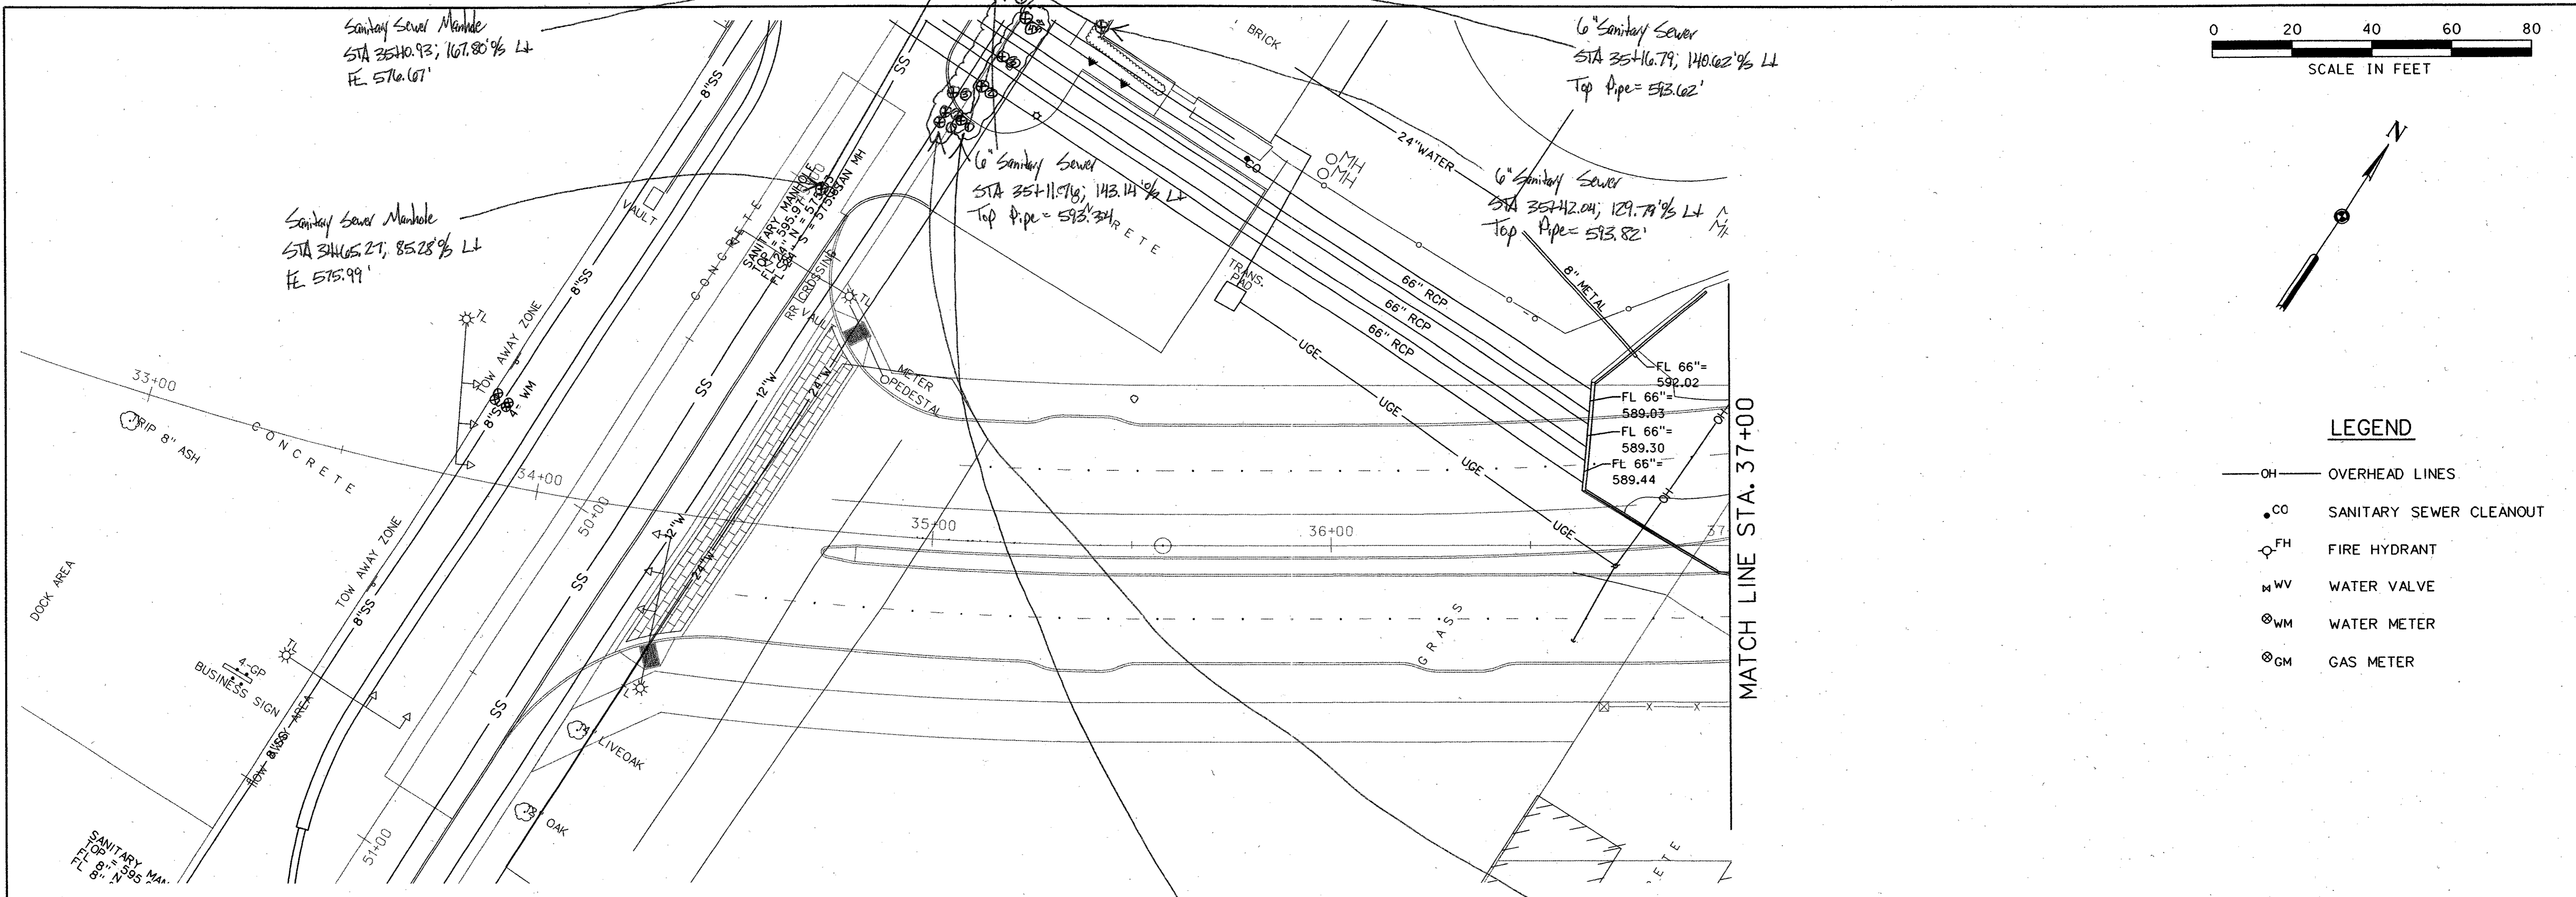

Related 8" Waterline

Loc	Desc	STA	%	Elev (Top Pipe)
1	45° Bend (Upper)	37+00.67	30.14 Lt	597.19
2	45° Bend (Lower)	37+02.95	28.07 Lt	595.31
3	45° Bend (Lower)	37+30.75	21.71 Lt	595.14
4	45° Bend (Upper)	37+32.88	21.90 Lt	597.03
5	Top Pipe	37+38.58	27.80 Lt	597.03

12" Waterline Laying



Loc	Desc	STA	%	Elev (Top Pipe)
1	Valve Stem	37+95.08	104.30 Lt	591.09
2	Upper 45° Bend	37+97.47	106.99 Lt	591.96
3	Lower 45° Bend	38+00.42	112.02 Lt	586.34
4	Lower 45° Bend	38+17.59	138.52 Lt	586.34
5	Upper 45° Bend	38+21.77	144.43 Lt	592.18
6	Valve Stem	38+21.05	147.70 Lt	594.22

24" Waterline

Loc	Desc	STA	%	Elev (Top Pipe)
1	Top Pipe	38+08.99	106.26 Lt	586.12
2	Top Pipe	38+08.91	113.94 Lt	586.01
3	Top Pipe	38+13.75	121.88 Lt	587.61
4	Top Pipe	38+20.56	132.35 Lt	587.61

**NOTE:**

UNDERGROUND UTILITIES EXIST WITHIN AND ADJACENT TO THE LIMITS OF CONSTRUCTION. AN ATTEMPT HAS BEEN MADE TO LOCATE THESE UTILITIES ON THE PLANS. ALL EXISTING UTILITIES MAY NOT BE SHOWN ON THE PLANS, AND THE LOCATION OF THE UTILITIES SHOWN MAY VARY FROM THE LOCATION ON THE PLANS. PRIOR TO THE BEGINNING OF ANY TYPE OF EXCAVATION, THE CONTRACTOR SHALL CONTACT THE UTILITIES INVOLVED AND MAKE ARRANGEMENTS FOR THE LOCATION OF THE UTILITY ON THE GROUND. THE CONTRACTOR SHALL MAINTAIN THE UTILITY LOCATION MARKINGS UNTIL THEY ARE NO LONGER NECESSARY.

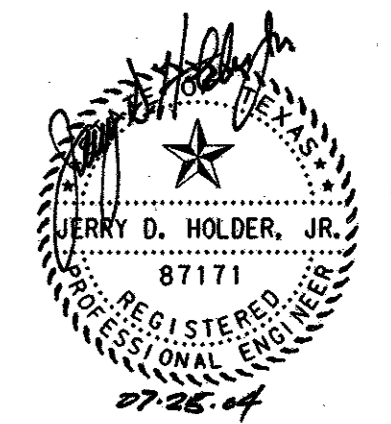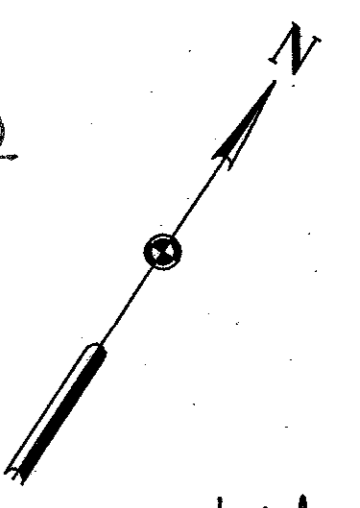

182	REVISION	APPROV.
<b>HNTB</b> ARCHITECTS ENGINEERS PLANNERS The HNTB Companies		
<b>ARAPAHO ROAD - PHASE III</b>		
SURVEYOR BOULEVARD TO ADDISON ROAD		
EXISTING UTILITY PLAN		
STA 33+87.02 TO 40+00		
TOWN OF ADDISON, TEXAS		
Design JSN	Drawn GFS	DATE SCALE PROJECT NO. SHEET NO.
Check JDH	Check JSN	APRIL 04 1"= 20' 25768 U-1