


RESTRICTOR PLATE DETAIL
N.T.S.

LEGEND


- EXIST. S.S.
- PROP. S.S.
- EXIST. WTR.
- PROP. WTR.
- PROP. STM. SWR.
- EXIST. STM. SEWER
- EXIST. STM. SEWER TO BE ABANDONED
- ⊙ WATER METER
- ⊥ GATE VALVE
- PROP. S.S. M.H.
- EXIST. FIRE HYDRANT
- OHE EXIST. OVER HEAD ELECTRIC

NOTE: ALL DIMENSION ARE TO FACE OF CURB UNLESS OTHERWISE NOTED

NOTE: UNDERGROUND DETENTION VAULTS TO BE PREMANUFACTURED CORRUGATED METAL PIPE MANUFACTURED BY CONTECH CONSTRUCTION PRODUCTS, INC. CONTRACTOR TO CONTACT GARY YOUNG @ (972)659-0826 FOR PIPE SPECIFICATIONS DETAILS & REINFORCEMENT ON DETENTION SYSTEM.

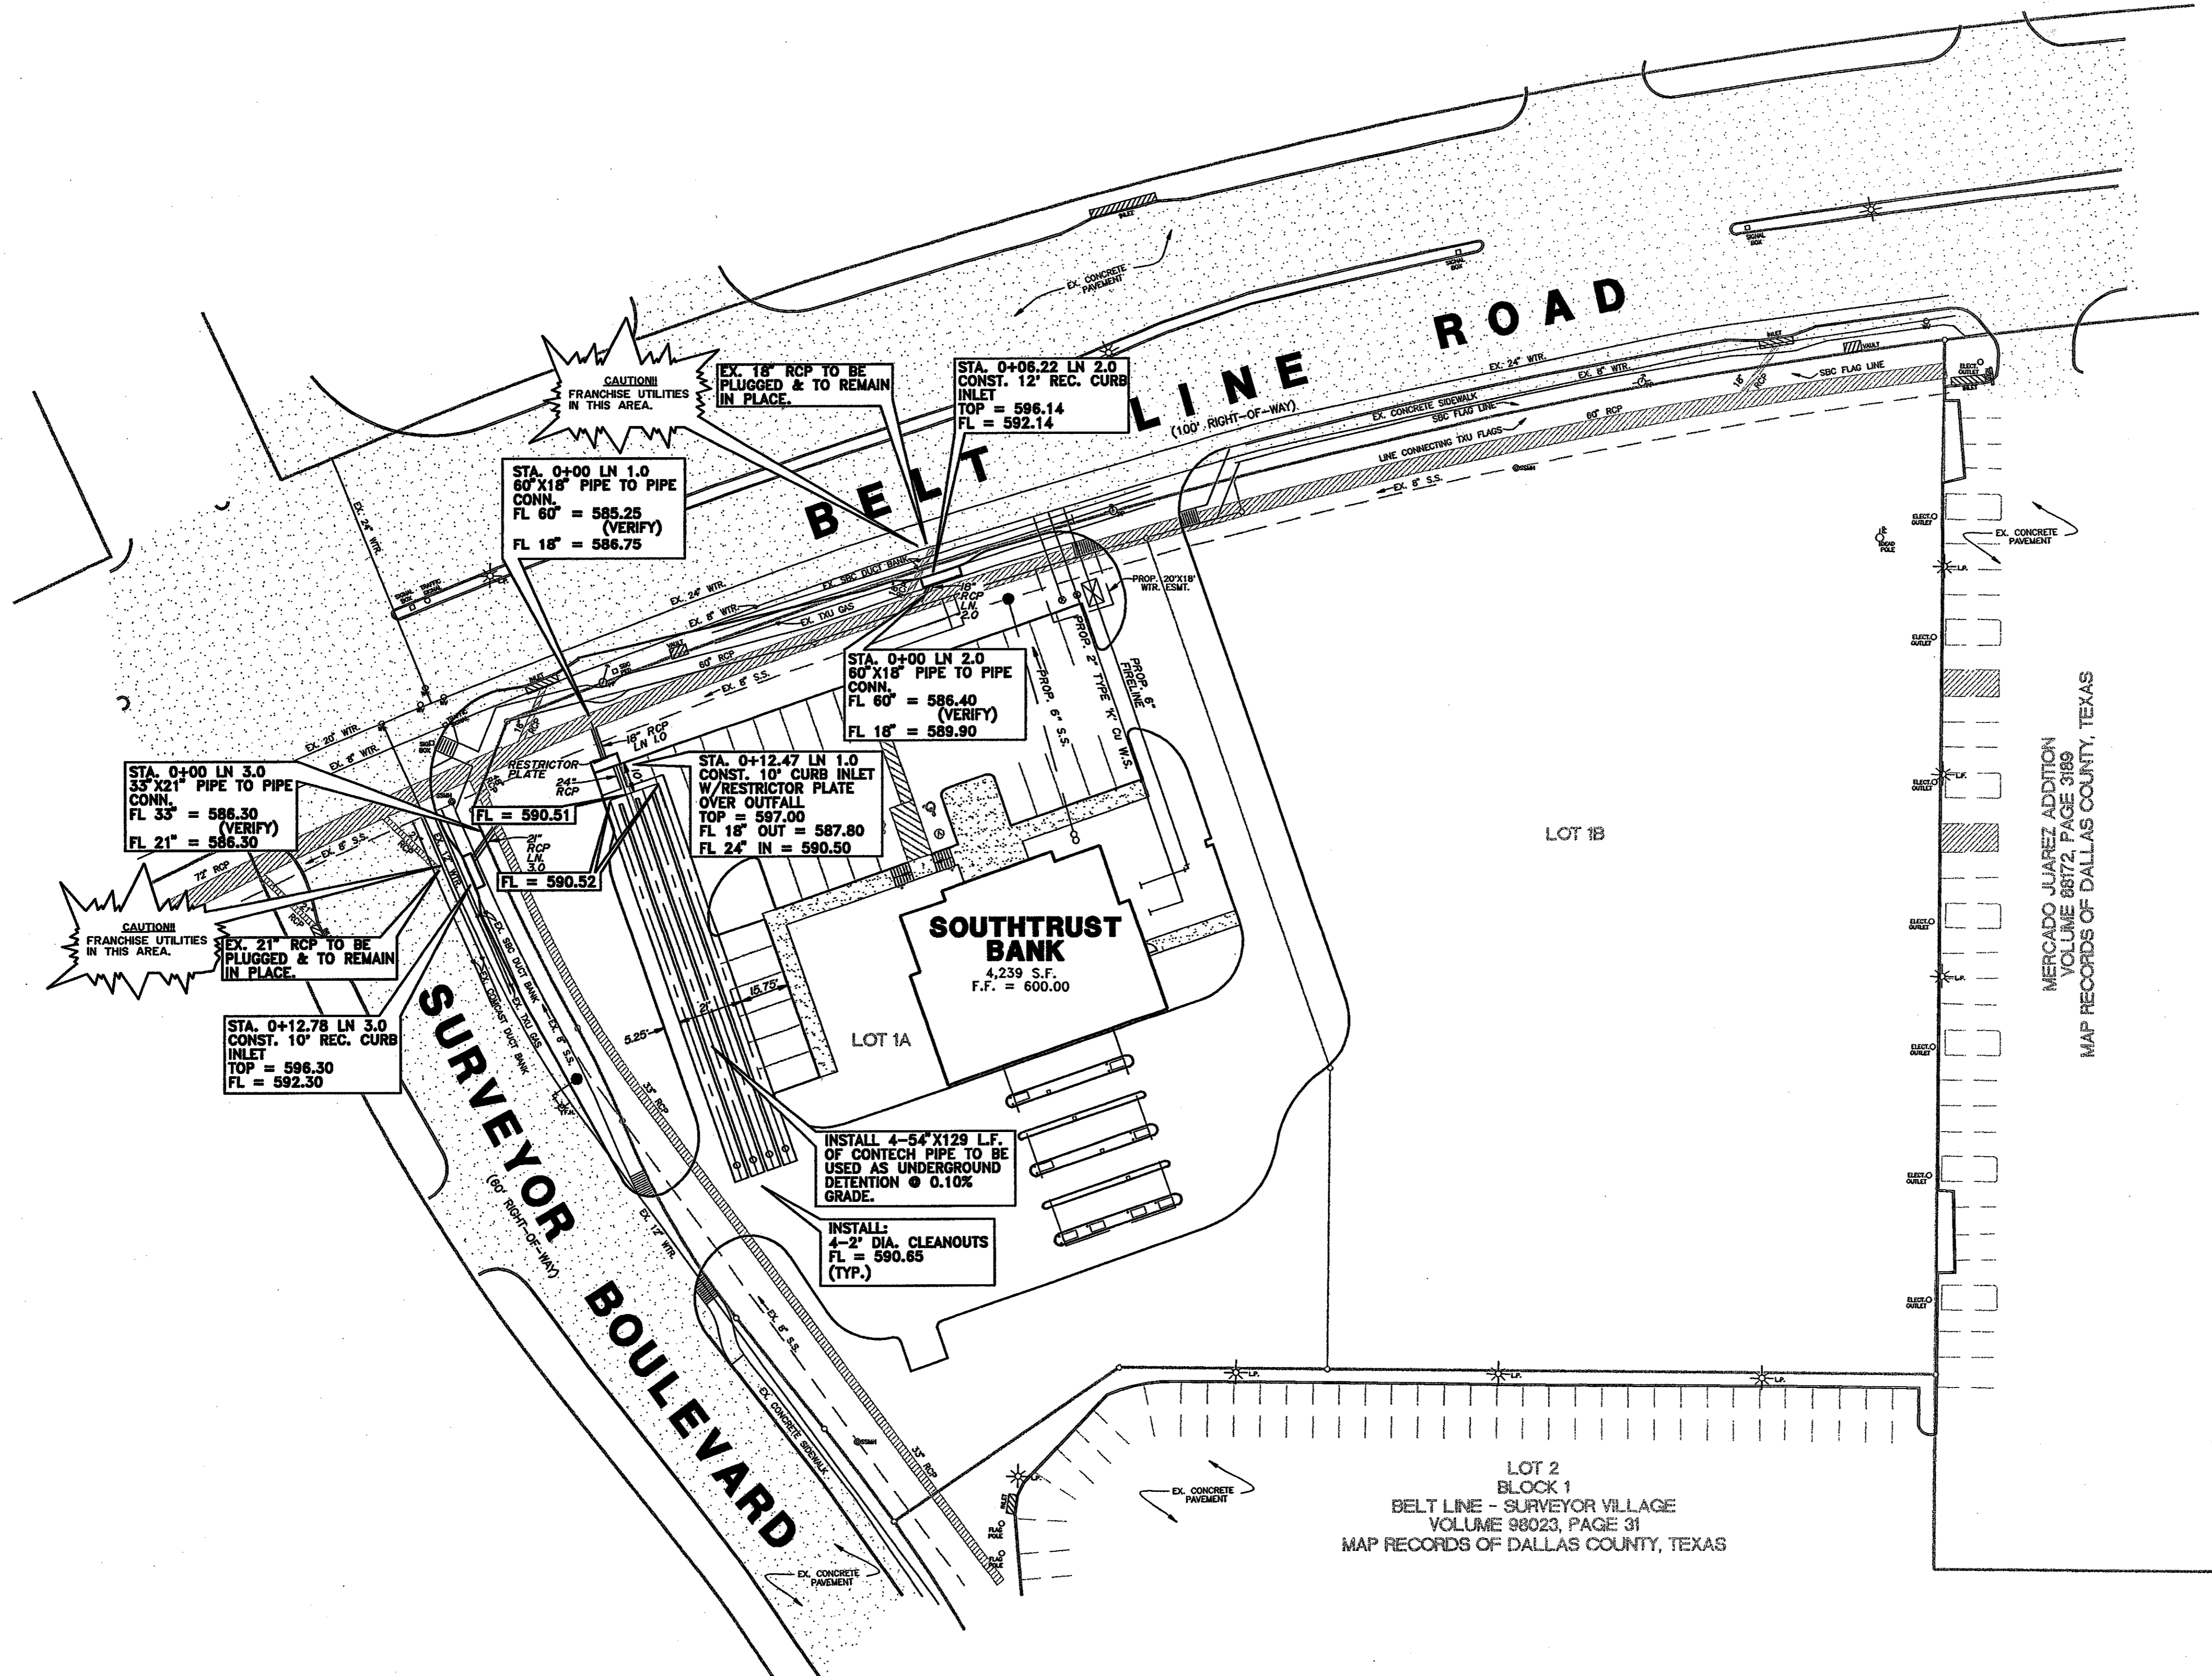

THE SEAL APPEARING ON THIS DOCUMENT WAS AUTHORIZED BY BRYAN M. BURGER, P.E. 90880 ON 5/27/04

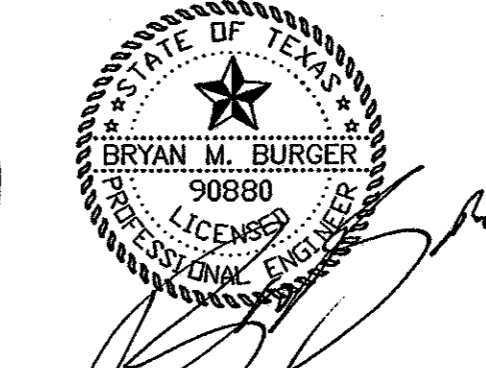

REV.	DATE	REMARKS				
DRAINAGE PLAN						
SOUTHTRUST BANK						
BELT LINE - SURVEYOR VILLAGE ADDITION						
TOWN OF ADDISON, TEXAS						
LAWRENCE A. CATES & ASSOC., LLP 14200 MIDWAY ROAD, SUITE 122 (972) 385-2272		CONSULTING ENGINEERS DALLAS, TEXAS				
DESIGN	DRAWN	DATE	SCALE	NOTES	FILE	NO.
BMB	JVW	FEB-04	1"=30'	D.P.	24001 DRAINAGE	C-6