

ARCHITECTS
 VAN LOM /
 EDWARDS
 A.I.A., P.C.
 34 N.W. First Avenue, Suite 309
 Portland, Oregon 97209 503/226-0590


S.E. CORNER OF BELTLINE ROAD
 AND MIDWAY ROAD
 ADDISON, TEXAS



Job No. 1498-01
 Date: 7/17/92
 Rev: 7/28/92
 10/05/92
 10/21/92

UTILITY PLAN


Sheet No.
C12

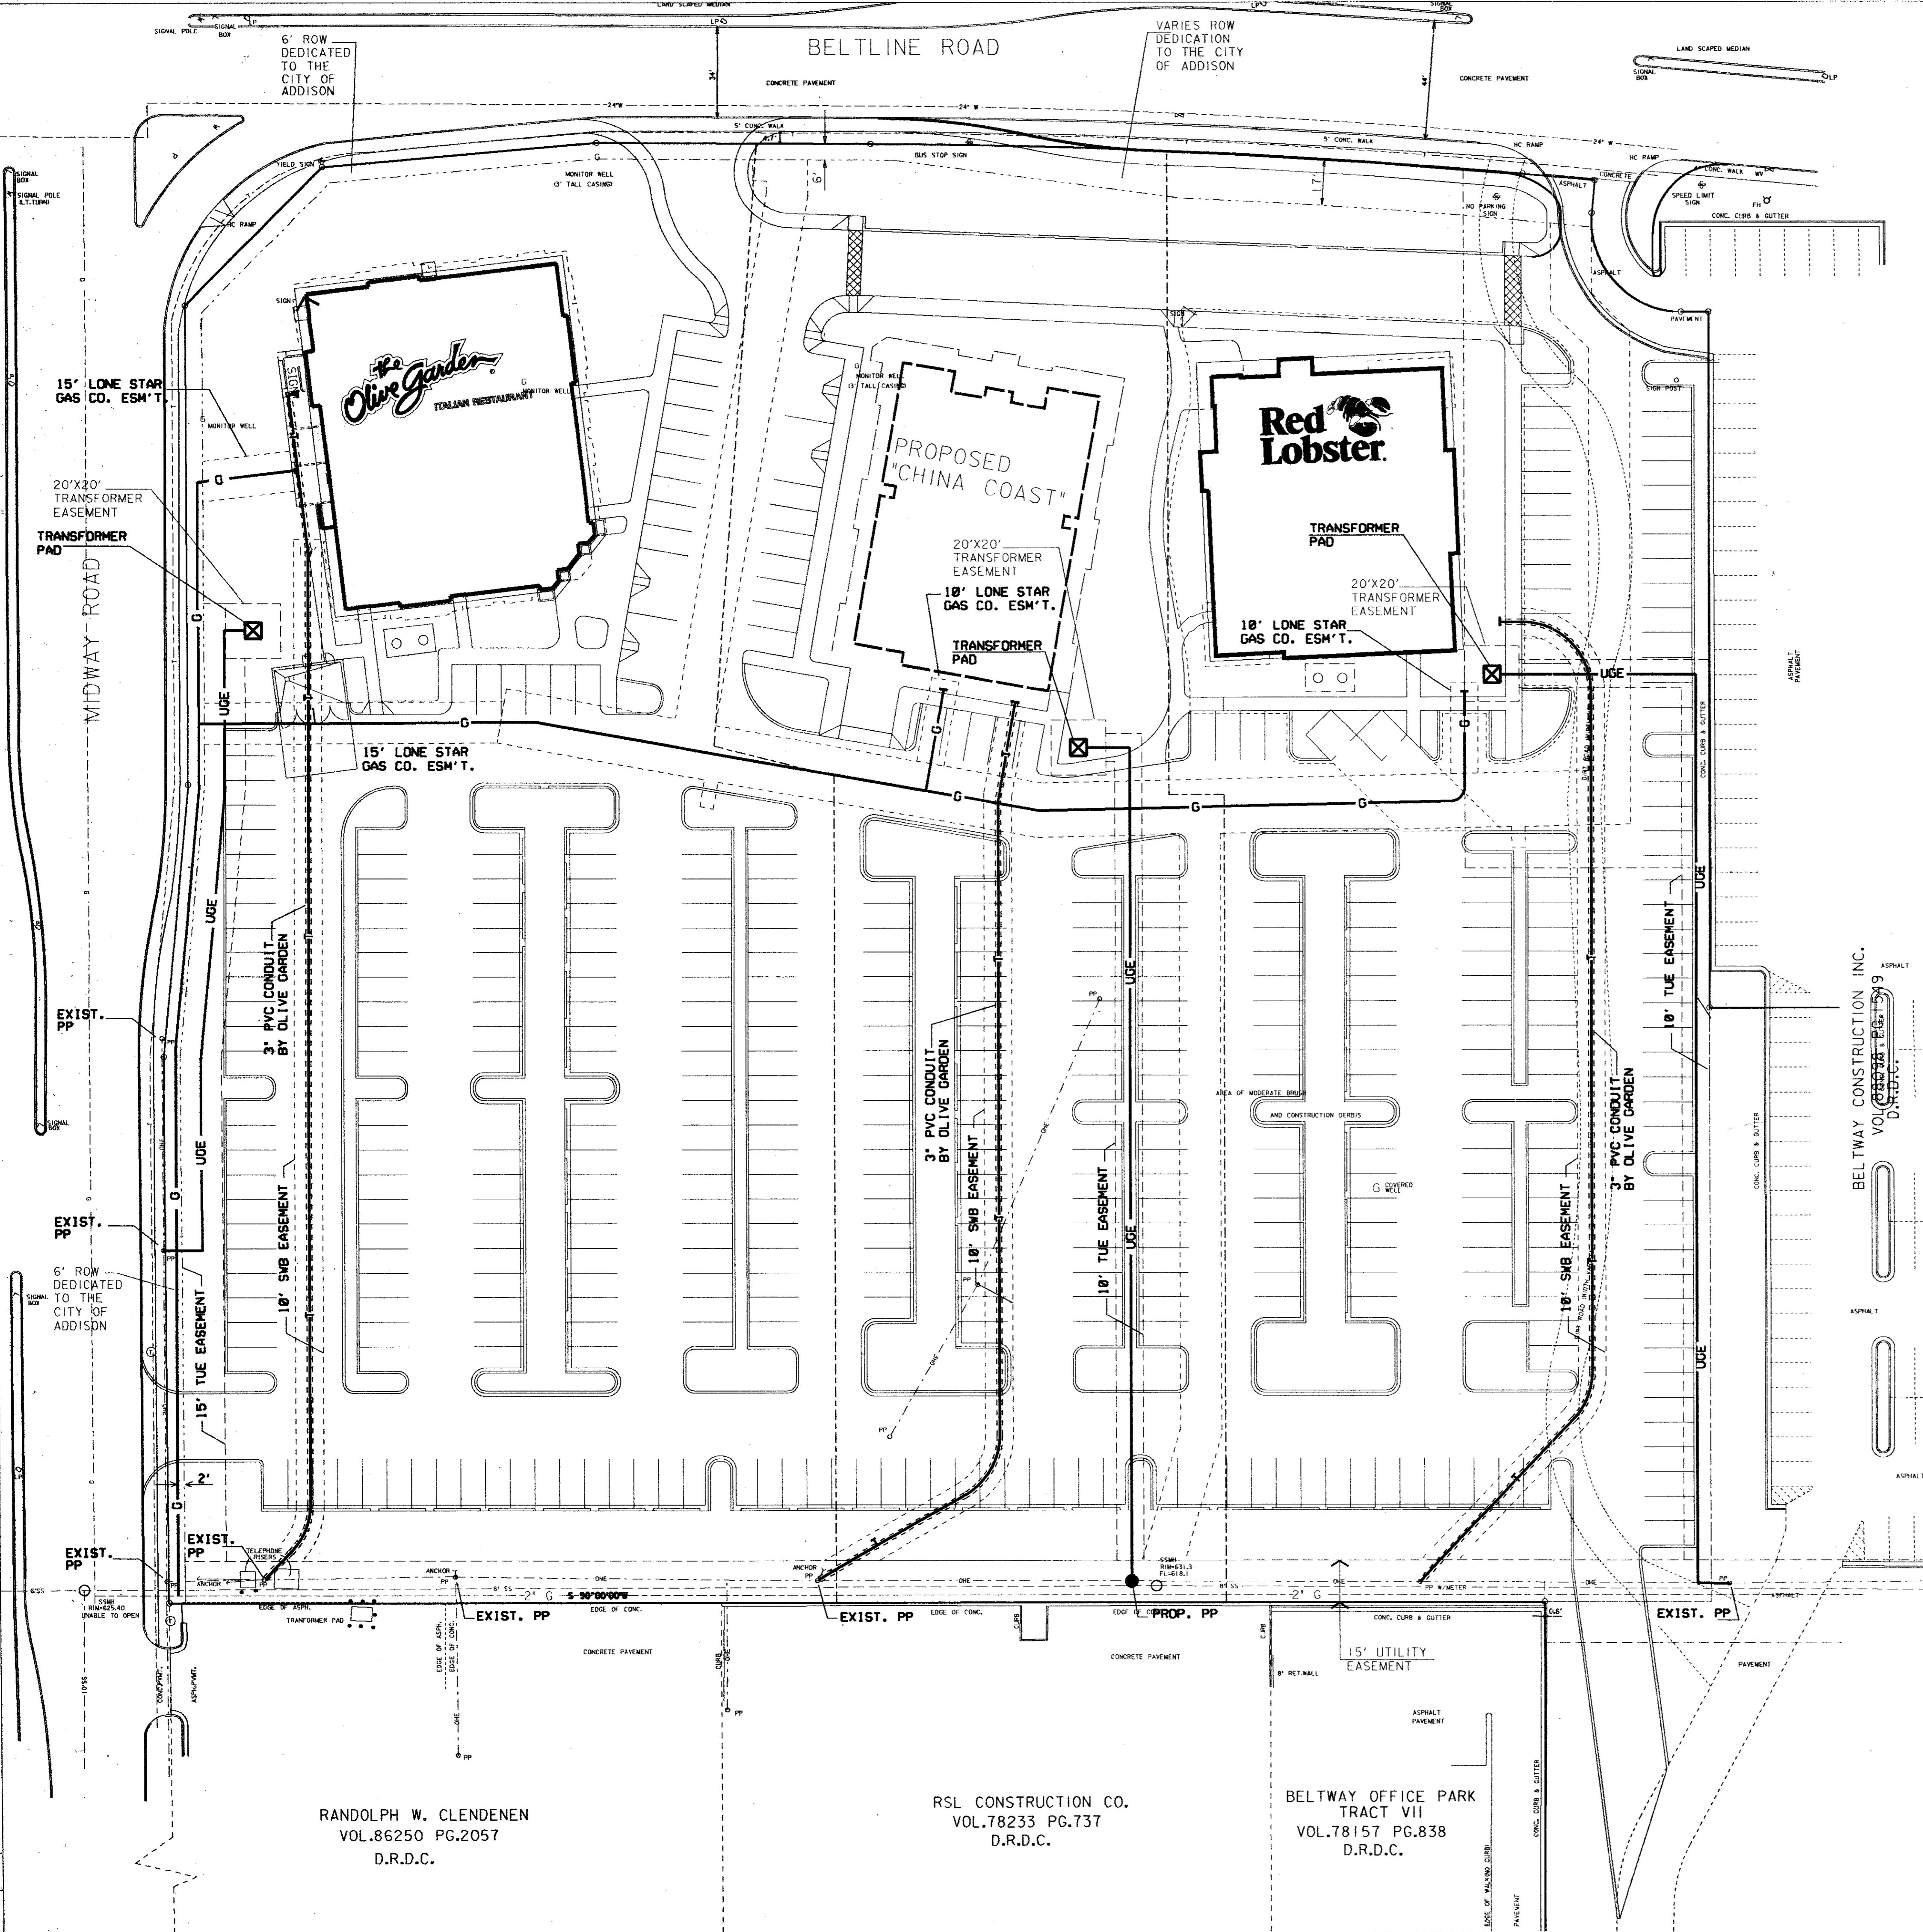

NOTES :
 FOR GAS SERVICES
 CONTACT BOB ROBINSON
 WITH LONE STAR GAS CO.
 @ (214)380-5109
 FOR ELECTRIC SERVICES
 CONTACT TIM BRANCHEAU
 WITH TU ELECTRIC CO.
 @ (214)323-8984
 FOR TELEPHONE SERVICES
 CONTACT TIM BIEDELMAN
 WITH SWB TELEPHONE CO.
 @ (214)234-7085



"AS BUILT"

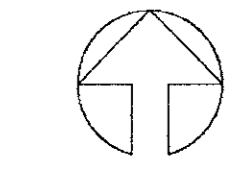

1" = 30'-0"

HUITT - ZOLLARS
 3131 MCKINNEY AVENUE/SUITE 600
 DALLAS, TEXAS/214-871-3311

The construction of this Plan was completed according to the design.

RANDOLPH W. CLENDENEN
 VOL.86250 PG.2057
 D.R.D.C.

RSL CONSTRUCTION CO.
 VOL.78233 PG.737
 D.R.D.C.

BELTWAY OFFICE PARK
 TRACT VII
 VOL.78157 PG.838
 D.R.D.C.