

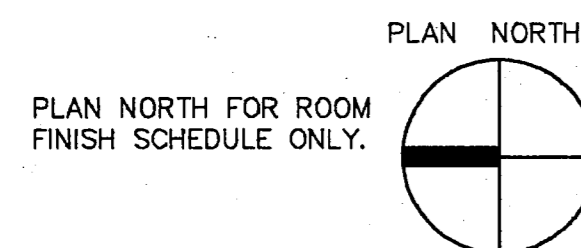


Δ R = 01°59'17"
 L = 2914.79'
 T = 101.13'
 = 50.57'

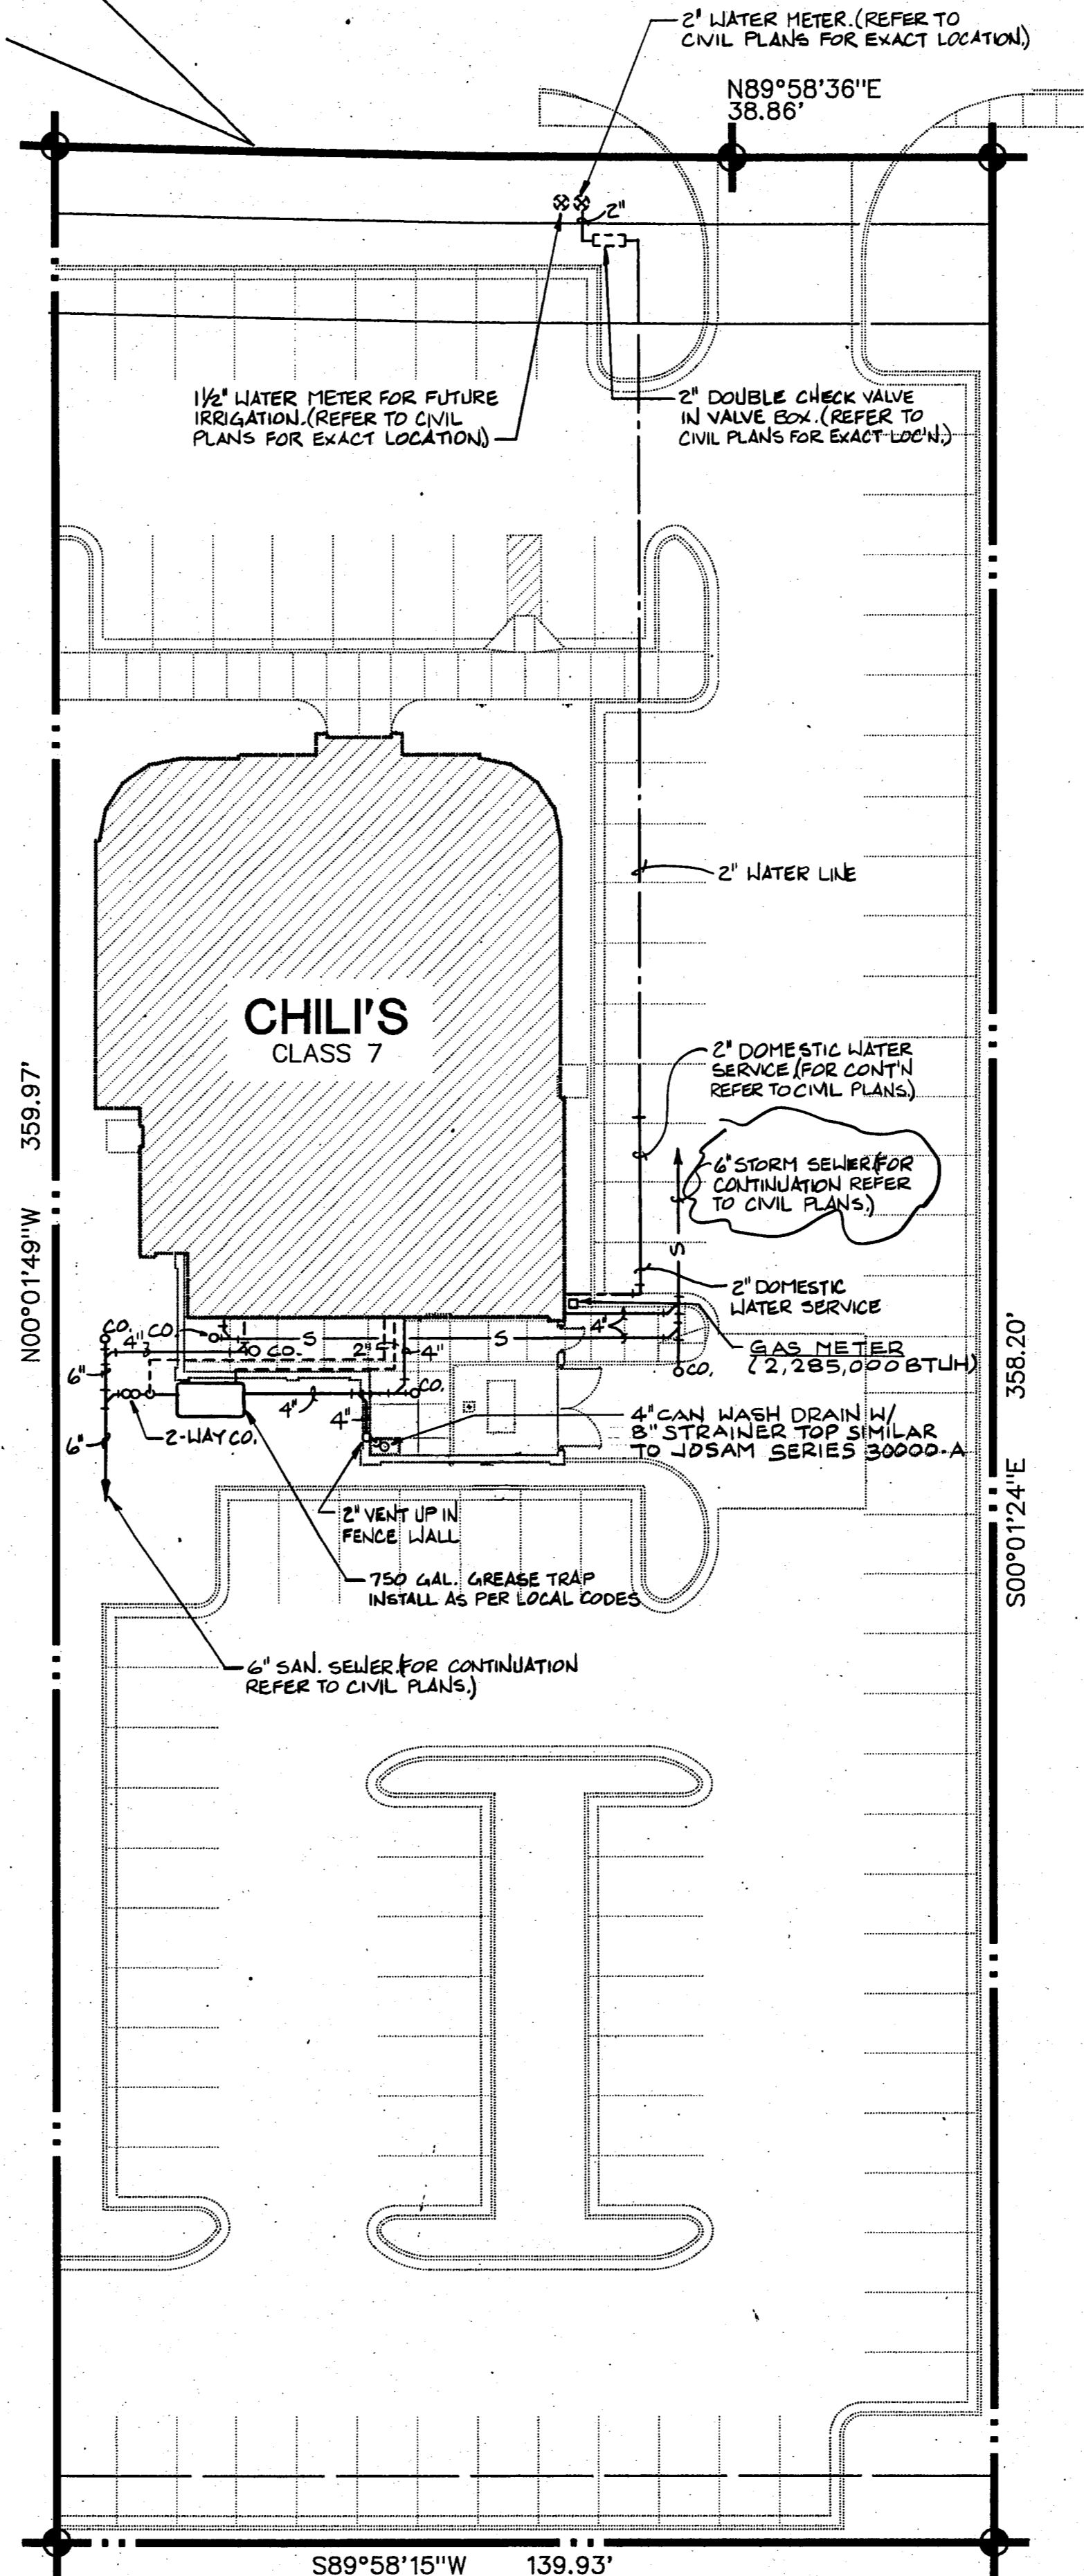

ME1.01 SITE PLAN - PLUMBING
1" = 20'-0"

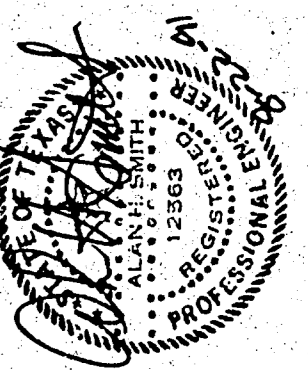

SMITH, DUNCAN AND ASSOCIATES, INC.
 CONSULTING ENGINEERS
 8705 STEWARTS FREEWAY DALLAS, TEXAS 75247 (214) 630-2902

CONTRACTOR SHALL VERIFY ALL CONDITIONS AND DIMENSIONS AT THE JOB SITE AND NOTIFY THE ARCHITECTS OF ANY DIMENSIONAL ERRORS, OMISSIONS OR DISCREPANCIES BEFORE BEGINNING OR FABRICATING ANY WORK DO NOT SCALE DRAWINGS

THE VINCENT ASSOCIATION OF ARCHITECTS
 One Empire Place 1327 Empire Central Suite 104 Dallas, Texas 75247 (214) 630-2902

ADDISON, TX



JOB NUMBER
91097.00

SHEET NUMBER
ME1

OF SHEETS

DATE OF ORIGINAL ISSUE
28 AUGUST 1991

NO. DATE REVISIONS BY

DATE OF THIS PRINTING