

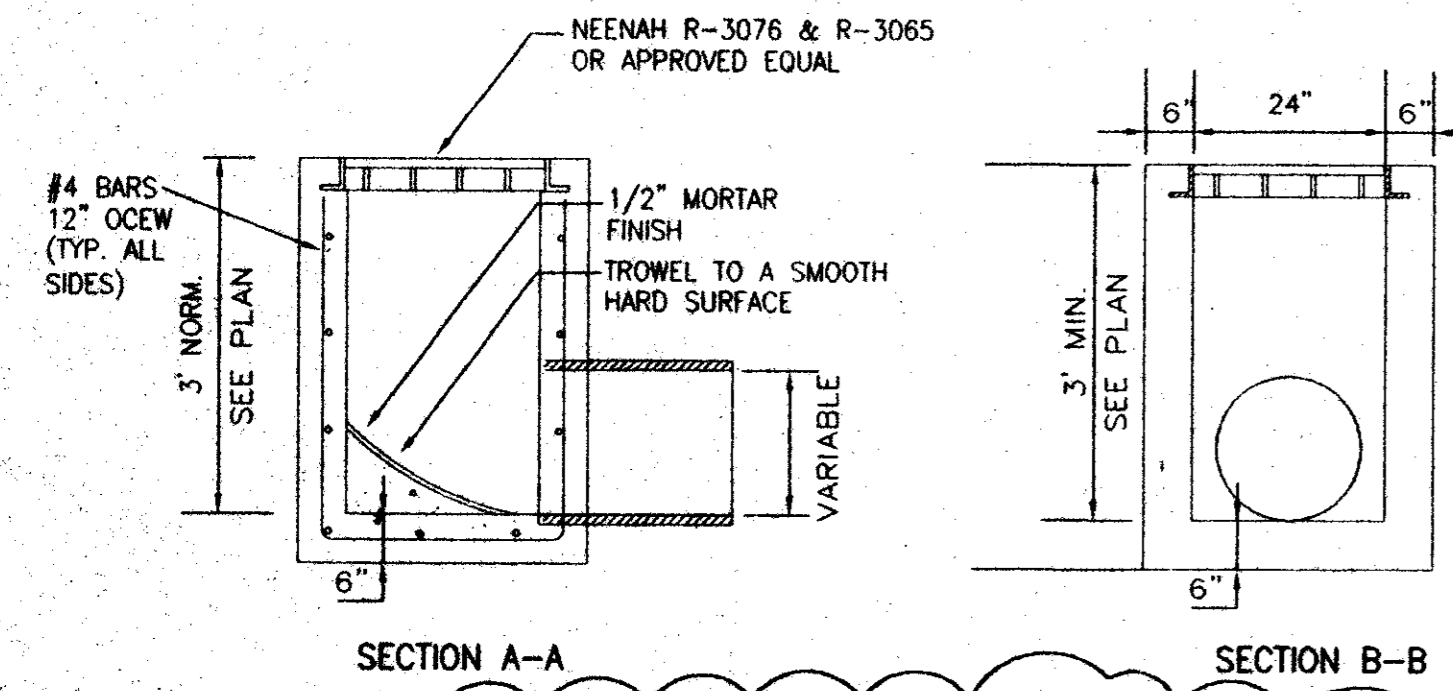


STORM SEWER PLAN
SCALE: 1" = 20'-0"

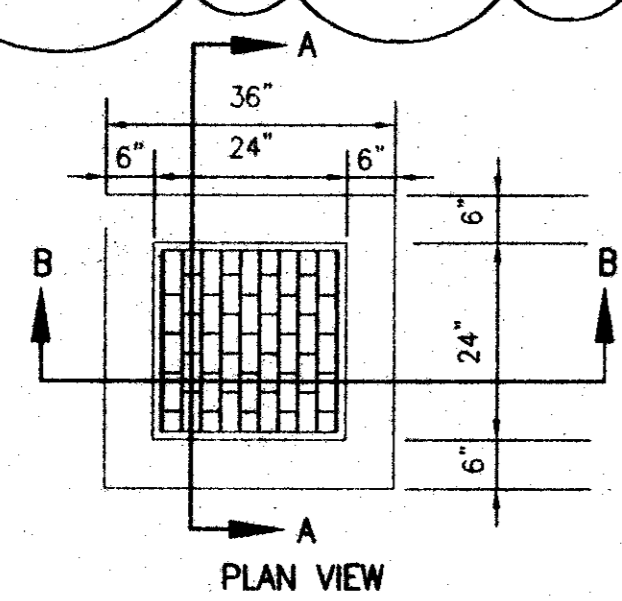


ONE GRATE INLET DETAILS
SCALE: NTS

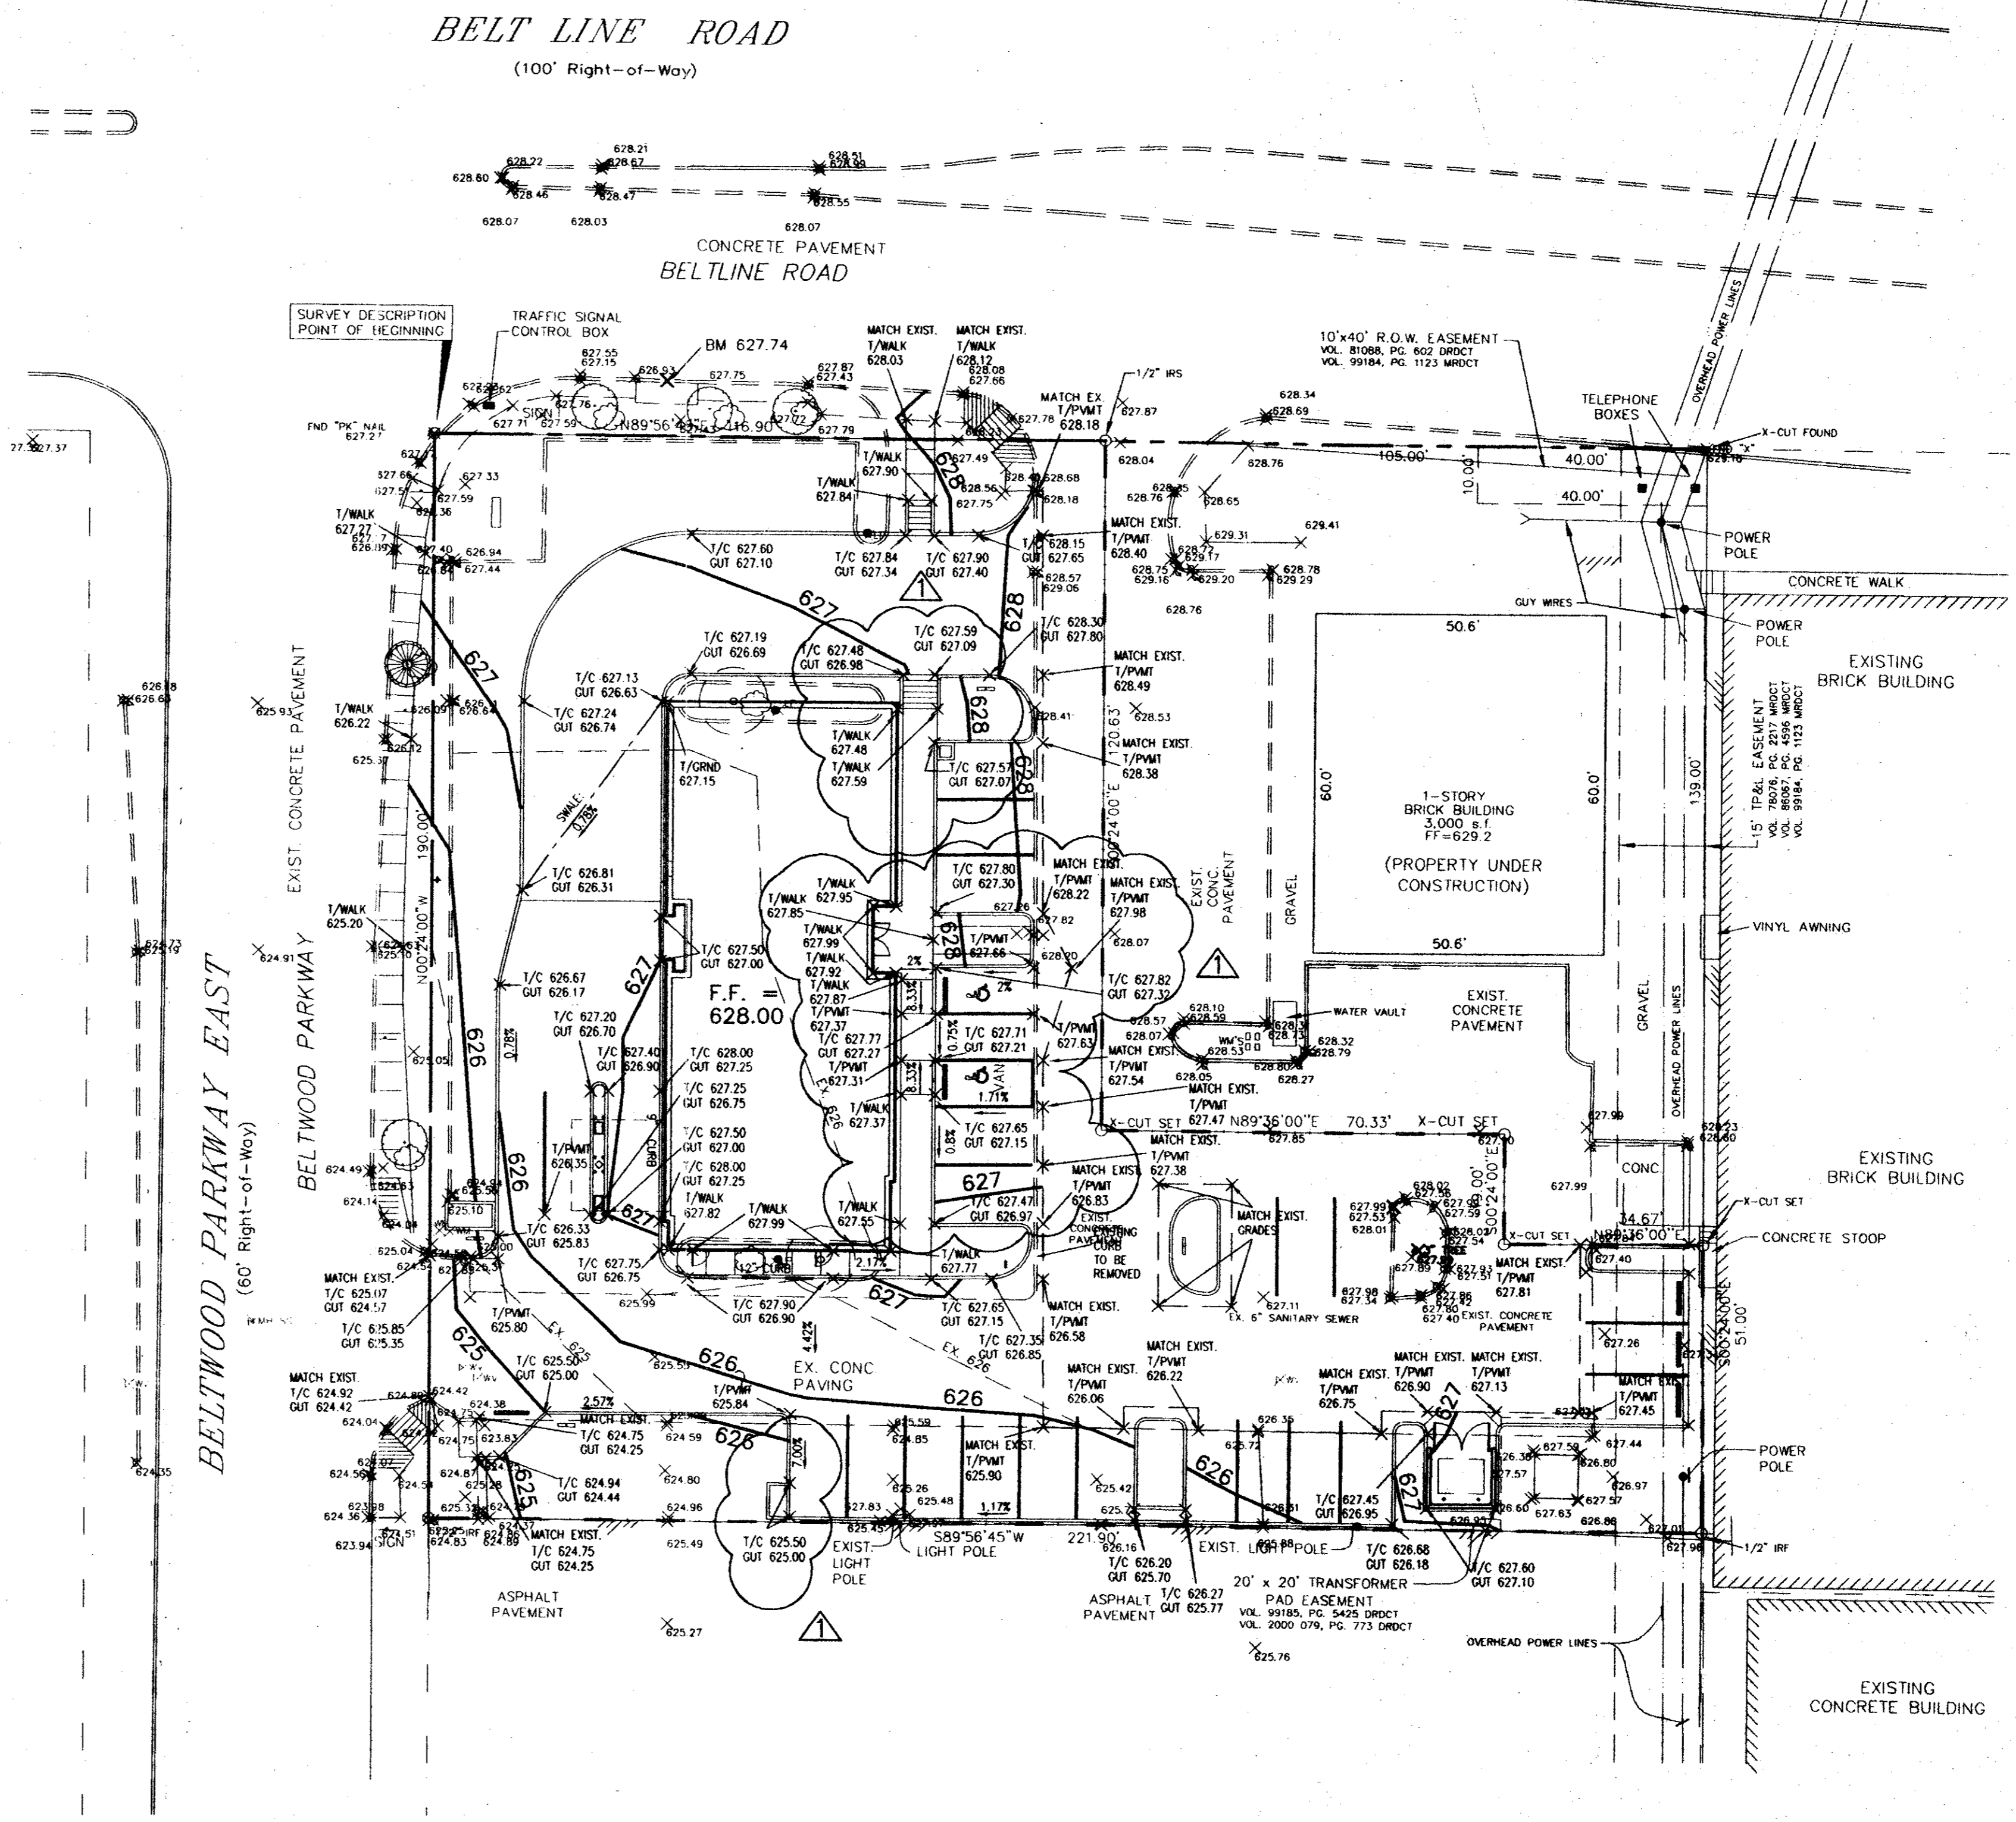

GRADING PLAN
SCALE: 1" = 20'-0"



MICHAEL PEEPLES
ENGINEERS & PLANNERS
2514 TARPLEY ROAD, #118 - CARROLLTON, TX 75006
972-416-1968 (TEL) 972-416-5289 (FAX)

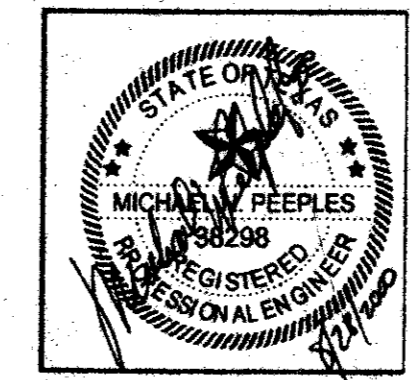

R-F
ROGERS - FORD
ARCHITECTURE - INTERIOR DESIGN
2616 THOMAS AVENUE
DALLAS, TEXAS 75204
TELEPHONE (214) 871-9388
FAX (214) 871-9165

LONE STAR BANK
4650 BELTLINE ROAD
AT BELTWOOD PARKWAY EAST
ADDISON, TX.

07-25-00 ISSUE FOR PERMIT
08/17/2000 ISSUE FOR BID
08/23/2000 ADDENDUM #1
12/15/2000 CANON 1500E

CE-1

Project # 1804
GRADING PLAN

Copyright 2000 MICHAEL PEEPLES ENGINEERS & PLANNERS, P.C. Drawn: P. Alford. Checked: M. Rogers. Title: Grading Plan. Date: 08/17/2000. Project: 1804. Scale: 1" = 20'-0".