

ENGINEERING GROUP INC.
 1855 FLORIDA STREET, SUITE #100
 HUNTINGTON BEACH, CALIFORNIA 92648
 PHONE (714) 947-7100 FAX (714) 941-8000
 CRO PROJECT NUMBER: 295-002



NO.	DATE	DESCRIPTION
1	08/14/14	ISSUED FOR PERMIT
2	08/14/14	ISSUED FOR PERMIT
3	08/14/14	ISSUED FOR PERMIT
4	08/14/14	ISSUED FOR PERMIT
5	08/14/14	ISSUED FOR PERMIT
6	08/14/14	ISSUED FOR PERMIT
7	08/14/14	ISSUED FOR PERMIT
8	08/14/14	ISSUED FOR PERMIT
9	08/14/14	ISSUED FOR PERMIT
10	08/14/14	ISSUED FOR PERMIT
11	08/14/14	ISSUED FOR PERMIT
12	08/14/14	ISSUED FOR PERMIT
13	08/14/14	ISSUED FOR PERMIT
14	08/14/14	ISSUED FOR PERMIT
15	08/14/14	ISSUED FOR PERMIT
16	08/14/14	ISSUED FOR PERMIT
17	08/14/14	ISSUED FOR PERMIT
18	08/14/14	ISSUED FOR PERMIT
19	08/14/14	ISSUED FOR PERMIT
20	08/14/14	ISSUED FOR PERMIT
21	08/14/14	ISSUED FOR PERMIT
22	08/14/14	ISSUED FOR PERMIT
23	08/14/14	ISSUED FOR PERMIT
24	08/14/14	ISSUED FOR PERMIT
25	08/14/14	ISSUED FOR PERMIT
26	08/14/14	ISSUED FOR PERMIT
27	08/14/14	ISSUED FOR PERMIT
28	08/14/14	ISSUED FOR PERMIT
29	08/14/14	ISSUED FOR PERMIT
30	08/14/14	ISSUED FOR PERMIT
31	08/14/14	ISSUED FOR PERMIT
32	08/14/14	ISSUED FOR PERMIT
33	08/14/14	ISSUED FOR PERMIT
34	08/14/14	ISSUED FOR PERMIT
35	08/14/14	ISSUED FOR PERMIT
36	08/14/14	ISSUED FOR PERMIT
37	08/14/14	ISSUED FOR PERMIT
38	08/14/14	ISSUED FOR PERMIT
39	08/14/14	ISSUED FOR PERMIT
40	08/14/14	ISSUED FOR PERMIT
41	08/14/14	ISSUED FOR PERMIT
42	08/14/14	ISSUED FOR PERMIT
43	08/14/14	ISSUED FOR PERMIT
44	08/14/14	ISSUED FOR PERMIT
45	08/14/14	ISSUED FOR PERMIT
46	08/14/14	ISSUED FOR PERMIT
47	08/14/14	ISSUED FOR PERMIT
48	08/14/14	ISSUED FOR PERMIT
49	08/14/14	ISSUED FOR PERMIT
50	08/14/14	ISSUED FOR PERMIT



LAZY DOG RESTAURANT & BAR
 VILLAGE ON THE PARKWAY
 5100 BELT LINE ROAD, SUITE 500
 ADDISON, TX 75254
 BUILDING DEPT. 1ST SUBMITTAL

PROJECT # 235-002
 ISSUE DATE 10/20/14

SHEET TITLE
WASTE AND VENT PIPING PLAN
 SHEET NUMBER
P2.0

- PLAN NOTES**
1. WASTE ON & 2" VENT UP FOR DW - INSTALL WITH W/O.
 2. WASTE ON TO BELOW FLOOR - INSTALL WITH W/O.
 3. WASTE ON TO BELOW FLOOR - INSTALL WITH W/O.
 4. WASTE ON TO BELOW FLOOR - INSTALL WITH W/O.
 5. WASTE ON TO BELOW FLOOR - INSTALL WITH W/O.
 6. WASTE ON TO BELOW FLOOR - INSTALL WITH W/O.
 7. WASTE ON TO BELOW FLOOR - INSTALL WITH W/O.
 8. WASTE ON TO BELOW FLOOR - INSTALL WITH W/O.
 9. WASTE ON TO BELOW FLOOR - INSTALL WITH W/O.
 10. WASTE ON TO BELOW FLOOR - INSTALL WITH W/O.
 11. WASTE ON TO BELOW FLOOR - INSTALL WITH W/O.
 12. WASTE ON TO BELOW FLOOR - INSTALL WITH W/O.
 13. WASTE ON TO BELOW FLOOR - INSTALL WITH W/O.
 14. WASTE ON TO BELOW FLOOR - INSTALL WITH W/O.
 15. WASTE ON TO BELOW FLOOR - INSTALL WITH W/O.
 16. WASTE ON TO BELOW FLOOR - INSTALL WITH W/O.
 17. WASTE ON TO BELOW FLOOR - INSTALL WITH W/O.
 18. WASTE ON TO BELOW FLOOR - INSTALL WITH W/O.
 19. WASTE ON TO BELOW FLOOR - INSTALL WITH W/O.
 20. WASTE ON TO BELOW FLOOR - INSTALL WITH W/O.
 21. WASTE ON TO BELOW FLOOR - INSTALL WITH W/O.
 22. WASTE ON TO BELOW FLOOR - INSTALL WITH W/O.
 23. WASTE ON TO BELOW FLOOR - INSTALL WITH W/O.
 24. WASTE ON TO BELOW FLOOR - INSTALL WITH W/O.
 25. WASTE ON TO BELOW FLOOR - INSTALL WITH W/O.
 26. WASTE ON TO BELOW FLOOR - INSTALL WITH W/O.
 27. WASTE ON TO BELOW FLOOR - INSTALL WITH W/O.
 28. WASTE ON TO BELOW FLOOR - INSTALL WITH W/O.
 29. WASTE ON TO BELOW FLOOR - INSTALL WITH W/O.
 30. WASTE ON TO BELOW FLOOR - INSTALL WITH W/O.
 31. WASTE ON TO BELOW FLOOR - INSTALL WITH W/O.
 32. WASTE ON TO BELOW FLOOR - INSTALL WITH W/O.
 33. WASTE ON TO BELOW FLOOR - INSTALL WITH W/O.
 34. WASTE ON TO BELOW FLOOR - INSTALL WITH W/O.
 35. WASTE ON TO BELOW FLOOR - INSTALL WITH W/O.
 36. WASTE ON TO BELOW FLOOR - INSTALL WITH W/O.
 37. WASTE ON TO BELOW FLOOR - INSTALL WITH W/O.
 38. WASTE ON TO BELOW FLOOR - INSTALL WITH W/O.
 39. WASTE ON TO BELOW FLOOR - INSTALL WITH W/O.
 40. WASTE ON TO BELOW FLOOR - INSTALL WITH W/O.
 41. WASTE ON TO BELOW FLOOR - INSTALL WITH W/O.
 42. WASTE ON TO BELOW FLOOR - INSTALL WITH W/O.
 43. WASTE ON TO BELOW FLOOR - INSTALL WITH W/O.
 44. WASTE ON TO BELOW FLOOR - INSTALL WITH W/O.
 45. WASTE ON TO BELOW FLOOR - INSTALL WITH W/O.
 46. WASTE ON TO BELOW FLOOR - INSTALL WITH W/O.
 47. WASTE ON TO BELOW FLOOR - INSTALL WITH W/O.
 48. WASTE ON TO BELOW FLOOR - INSTALL WITH W/O.
 49. WASTE ON TO BELOW FLOOR - INSTALL WITH W/O.
 50. WASTE ON TO BELOW FLOOR - INSTALL WITH W/O.


STRUCTURAL SLEEVING NOTE
 ALL PIPES THAT PASS THROUGH ANY STRUCTURAL FLOOR/ROOF/CEILING SHALL BE SLEAVED IN A MANNER THAT DOES NOT WEAKEN THE STRUCTURE. SLEAVING SHALL BE DONE IN ACCORDANCE WITH THE FOLLOWING:
 - SLEAVING SHALL BE INSTALLED WITH SLEAVING CHANNELS.
 - SLEAVING SHALL BE INSTALLED WITH SLEAVING CHANNELS.
 - SLEAVING SHALL BE INSTALLED WITH SLEAVING CHANNELS.

CLEANOUT LEGEND

- 1. W/O = WALL CLEANOUT (CLEANOUT TO BE LINE SIZED)
- 2. FLOOR = FLOOR CLEANOUT (CLEANOUT TO BE LINE SIZED)

GENERAL NOTES

SEE SHEET P1.2 FOR ALL PLAN SPECIFIC GENERAL NOTES

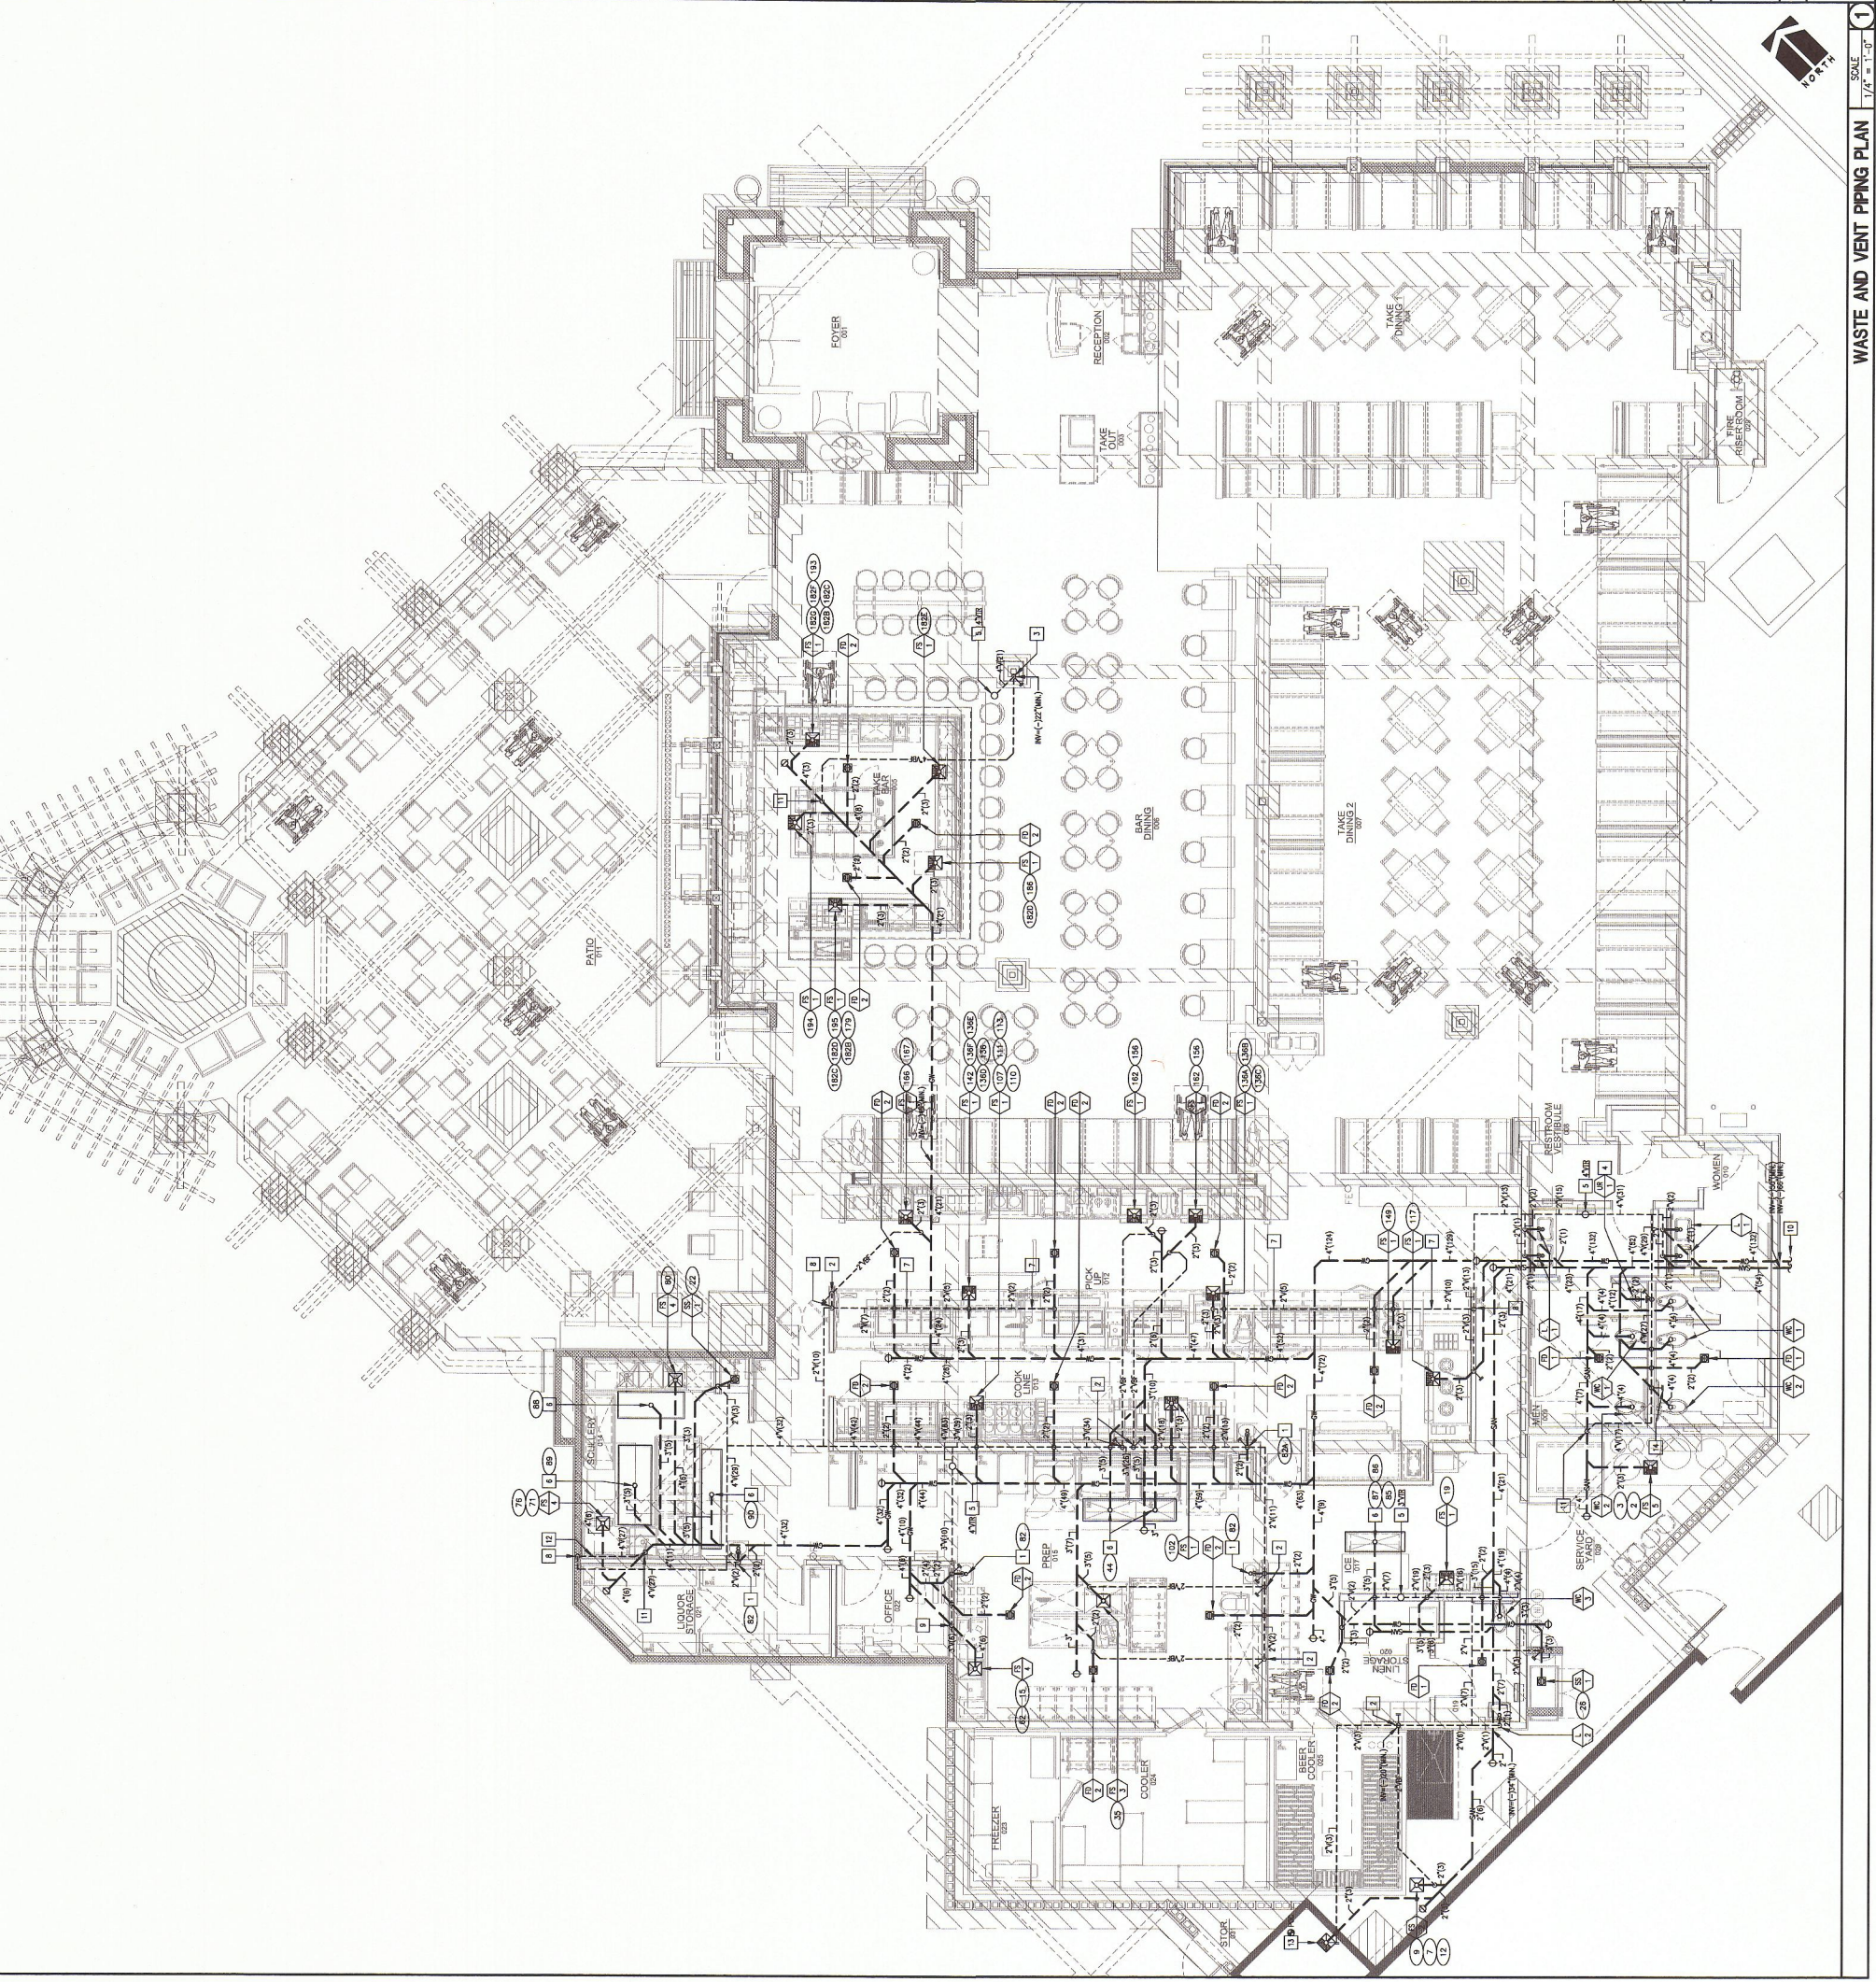

SCALE 1/4" = 1'-0"

WASTE AND VENT PIPING PLAN

1