
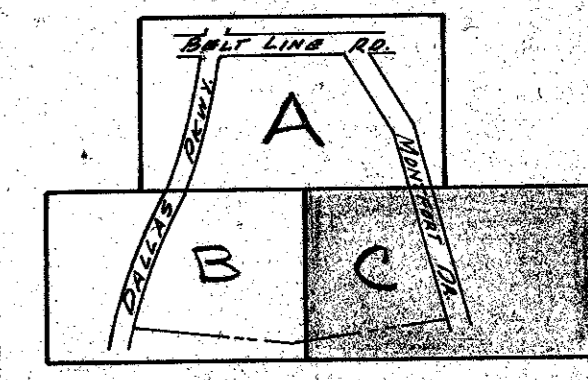
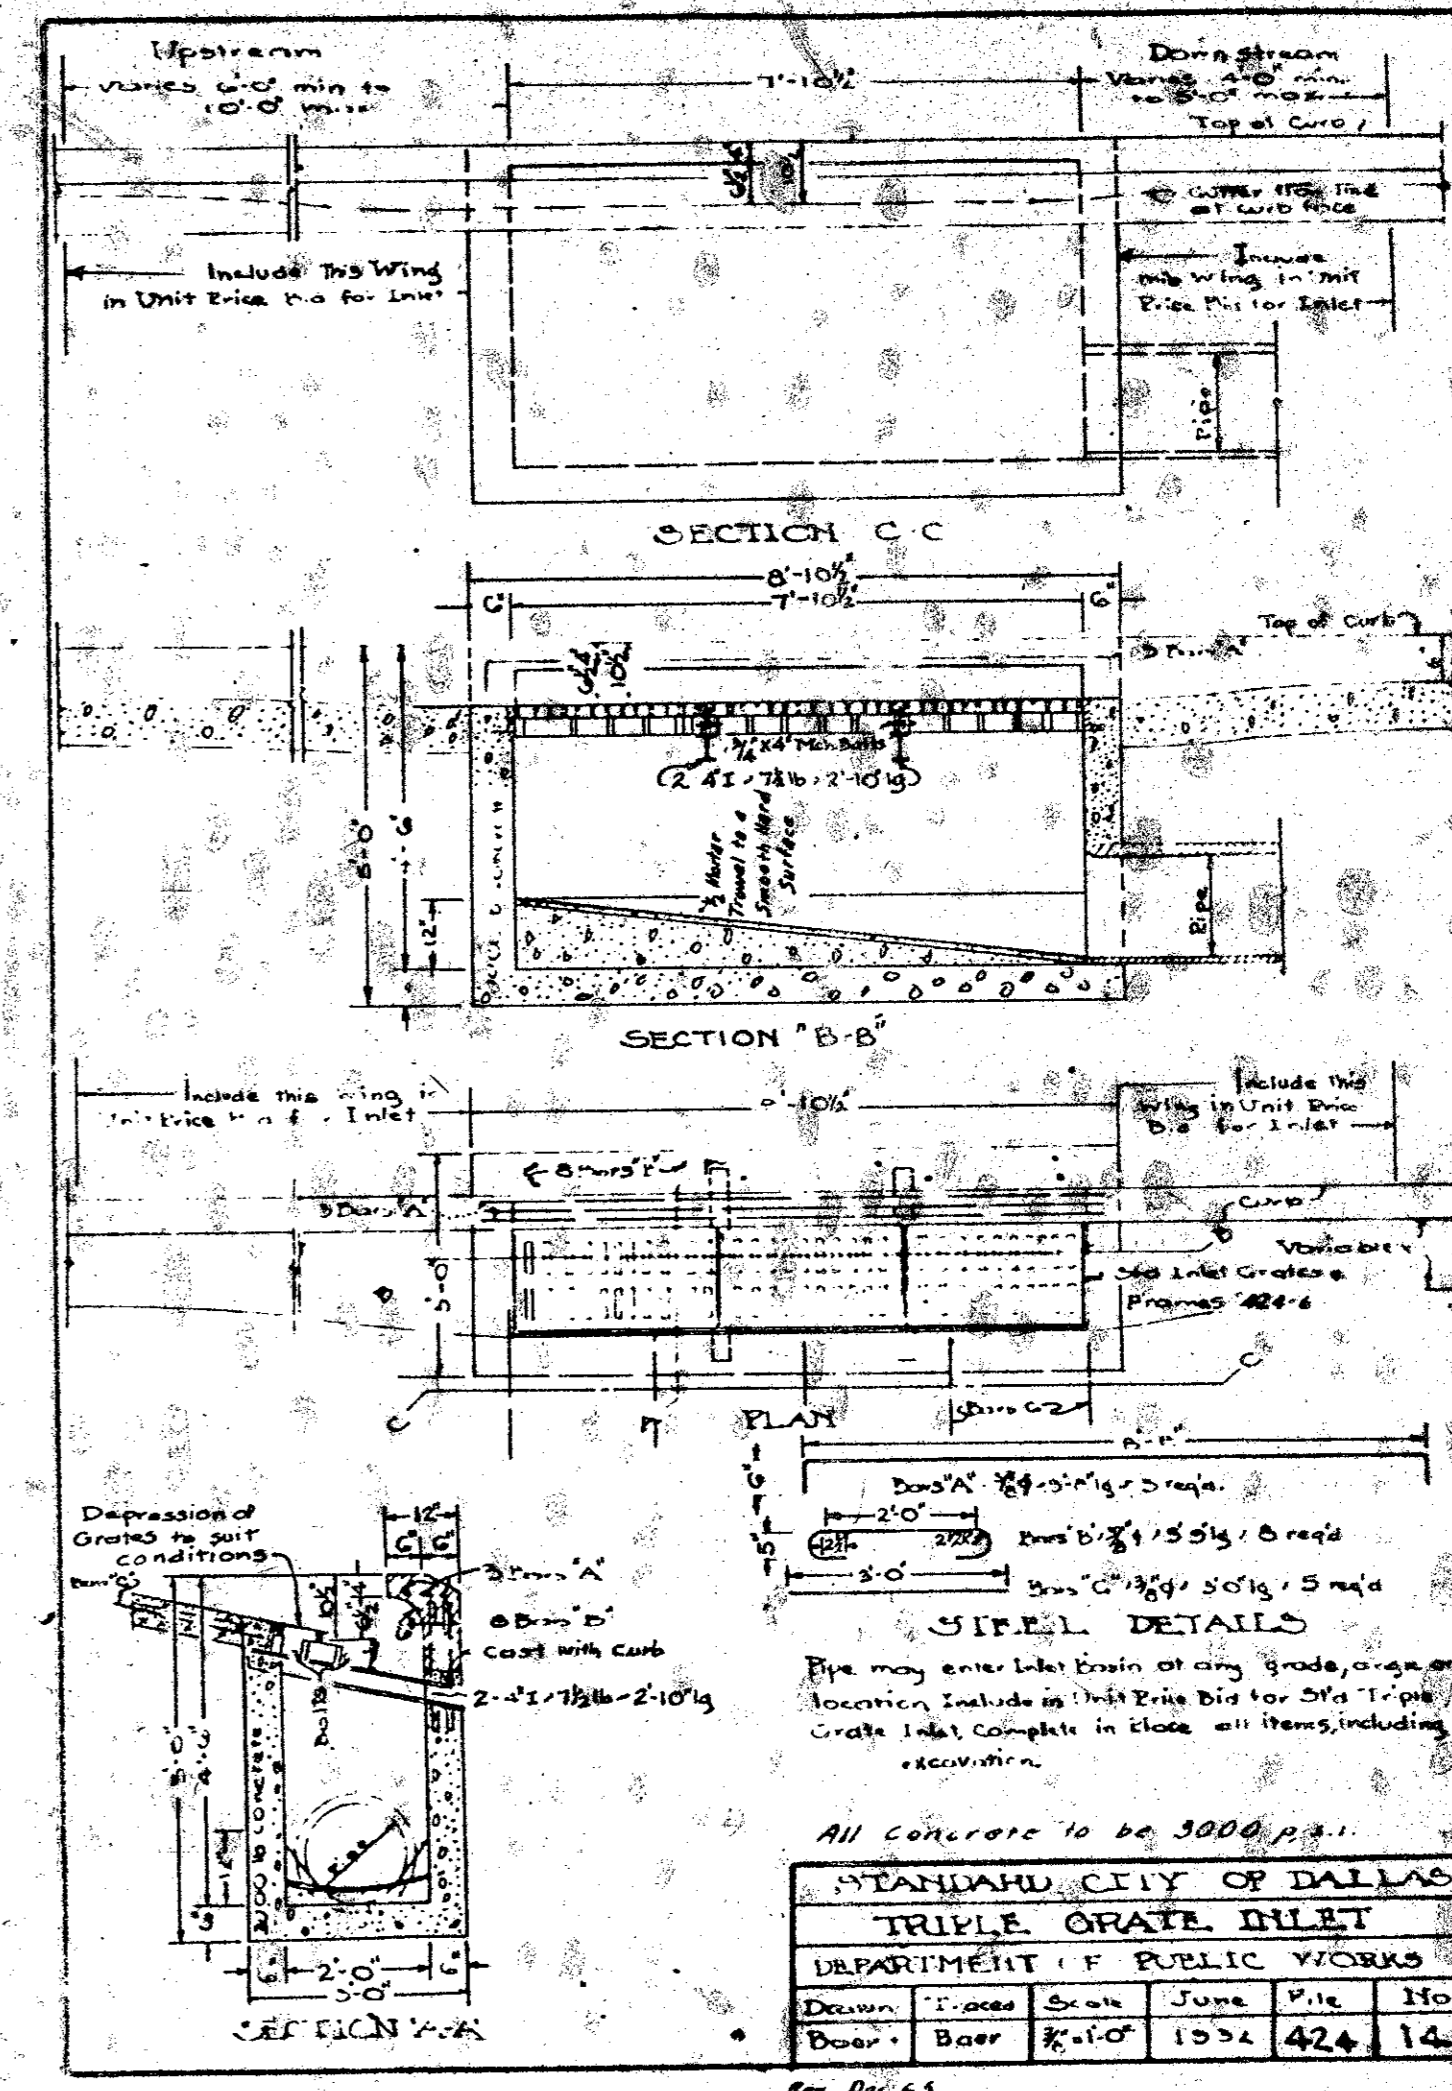


310-12

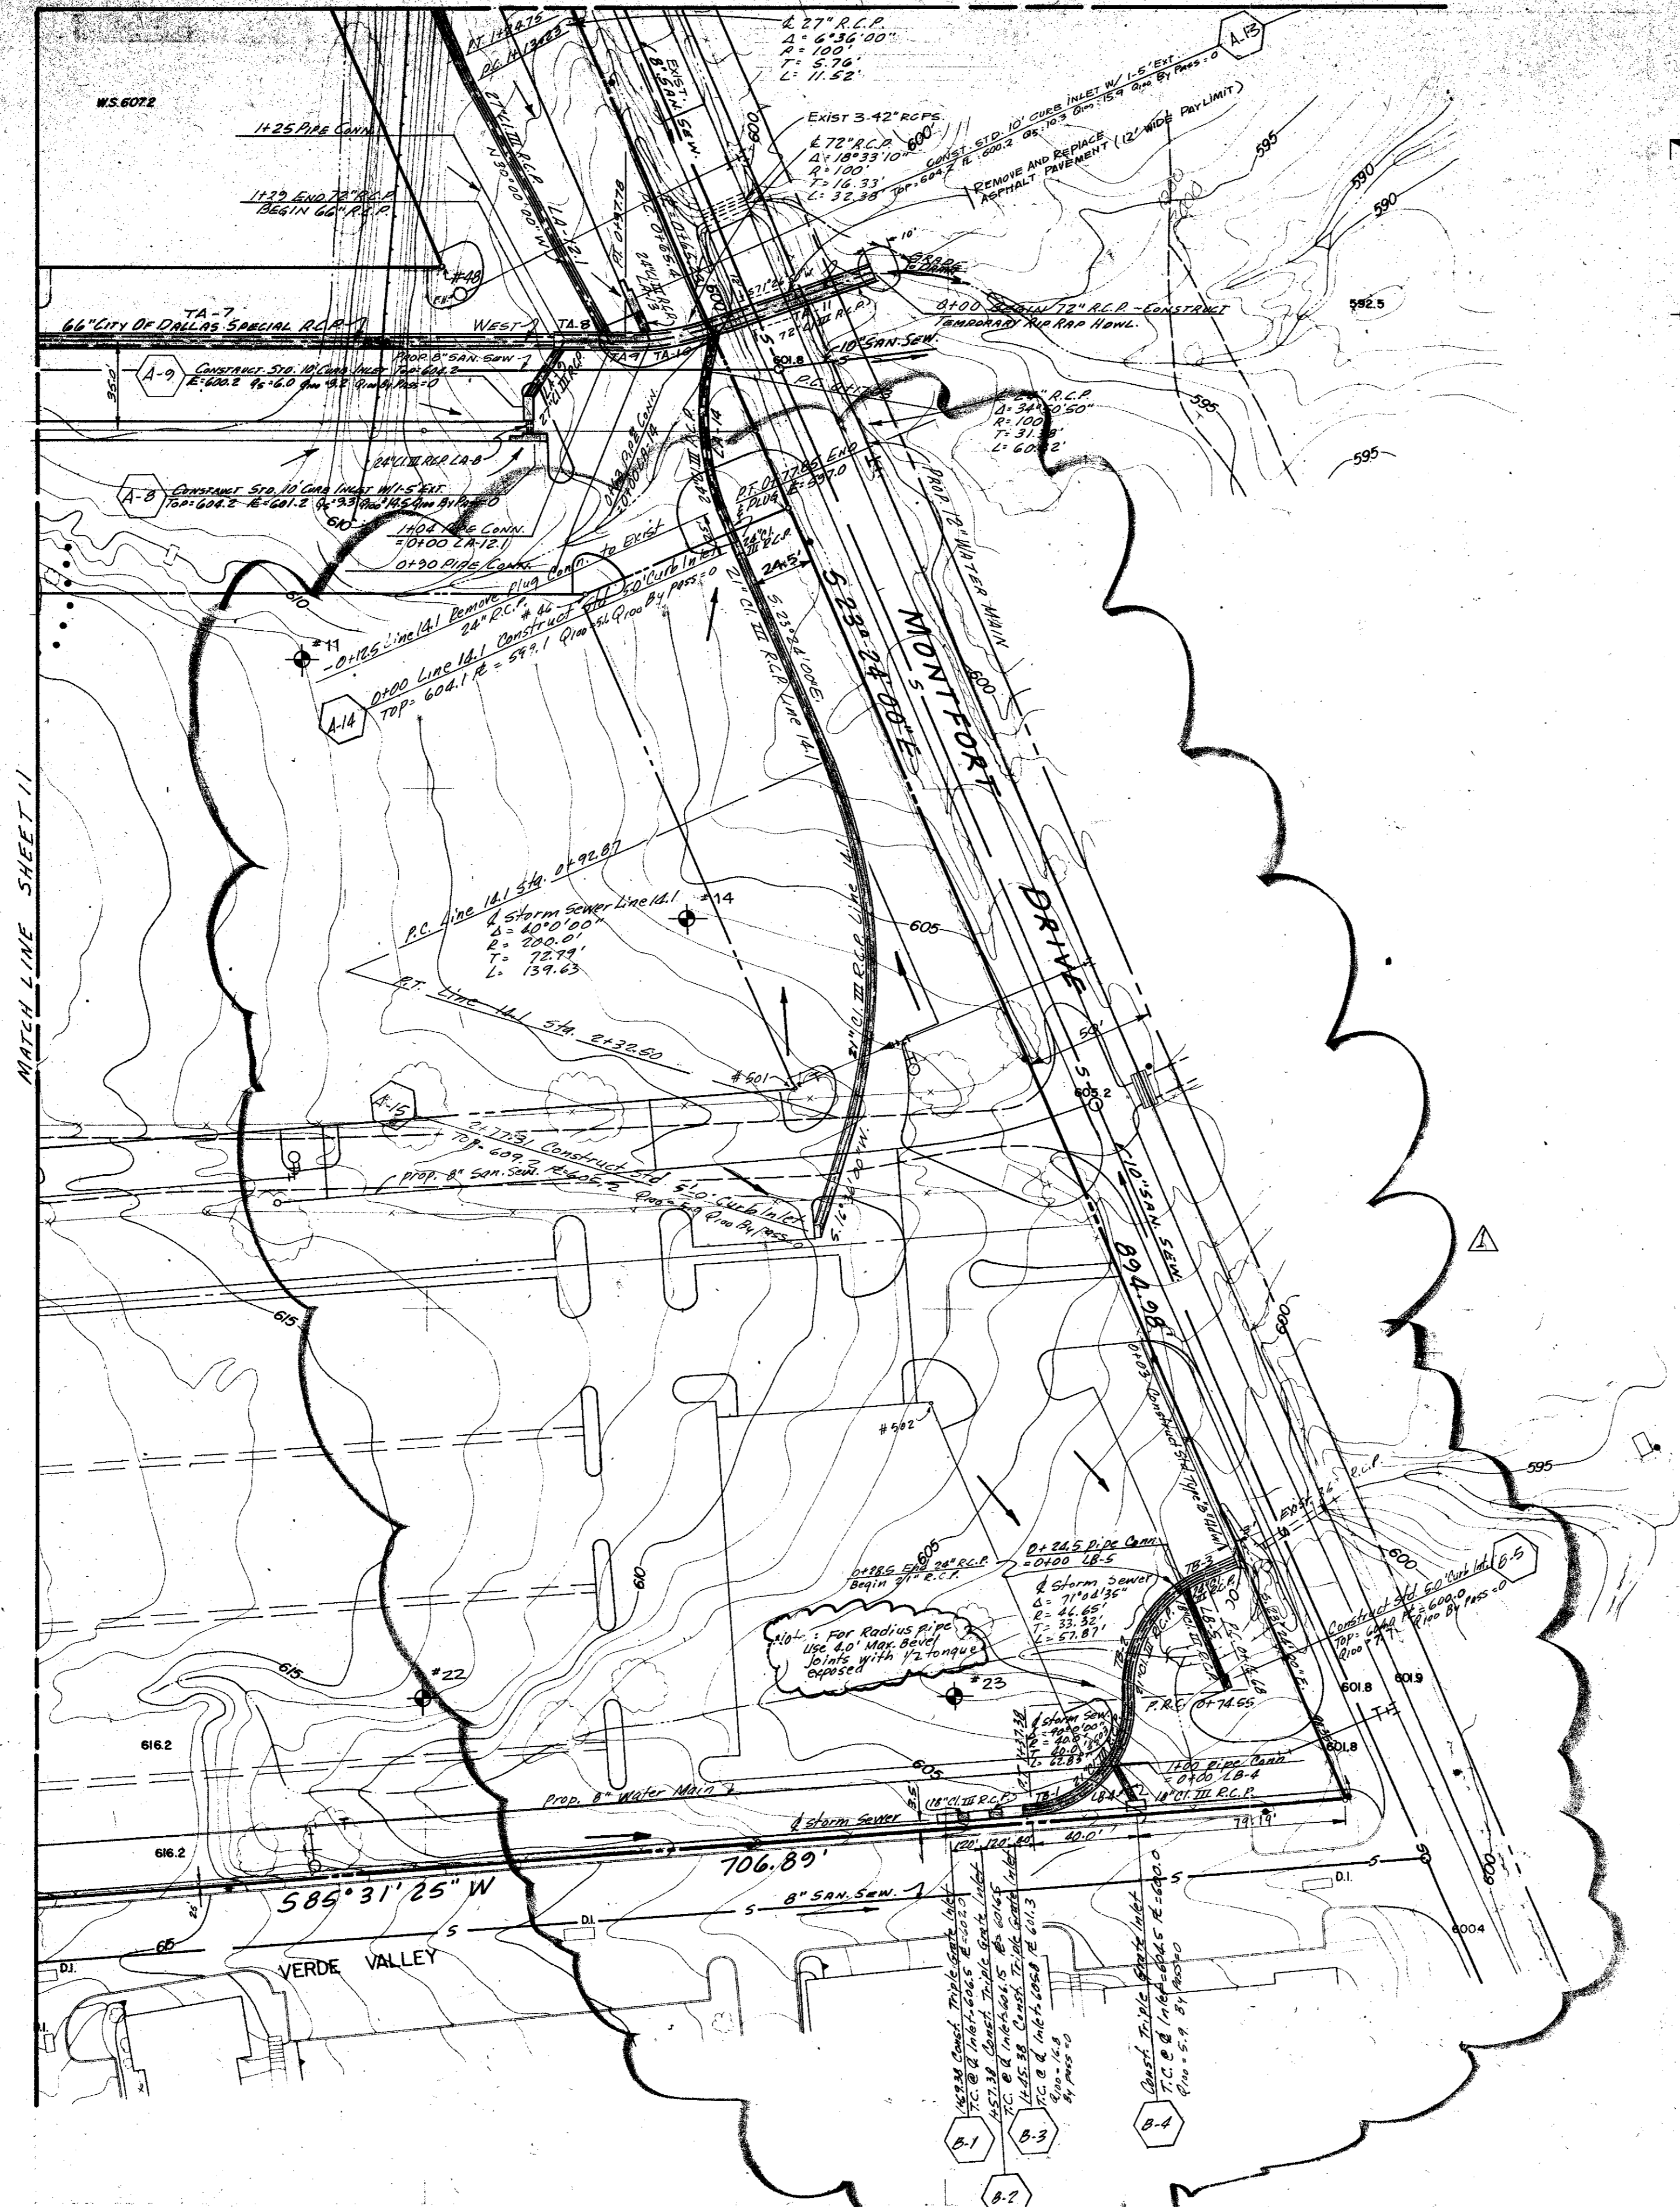

**LOT CORNER COORDINATES**

#	Y	X
48	1201.196	2804.643
49	1074.196	2859.501
50	882.230	2942.572
502	762.893	2994.212
503	628.039	3052.569

**BENCH MARK**:  
 STANDARD WATER DEPT. BENCH MARK  
 CENTER INLET NORTHWEST CORNER  
 BELTLINE ROAD AND DALLAS PKWY.  
 ELEV: 632.08

**NOTE**:  
 REFER TO HORIZONTAL LAYOUT &  
 PAVING PLANS FOR EXACT LOCATION  
 OF CURB INLETS.

INDICATES SOIL BORINGS

2-26-79 Storm Sewer for Second Installation

STORM SEWER PLAN						
VILLAGE ON THE PARKWAY						
VILLAGE PARKWAY VENTURE						
ALBERT H. HALFF ASSOCIATES, INC. ENGINEERS						
CITY OF ADDISON, TEXAS						
DESIGN	DRAWN	DATE	SCALE	NOTES	FILE	NO.
A.H.H. & ASSOC.	T.P.	MAY 1978	1" = 40'	6143		