



BECK-FORRESTER & ASSOCIATES
 ARCHITECTS - PLANNERS TEL: 214-651-9281
 DALLAS, TEXAS 75204
 2902 CARLISLE

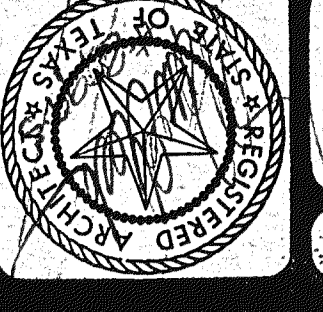

BELT LINE / MARSH BUSINESS PARK
 DAL MAC DEVELOPMENT INC.
 GENERAL PARTNER
 RICHARDSON
 TEXAS

PROJECT NO. 7807
 SHEET NO. A3
 ISSUE DATE 9/24/79

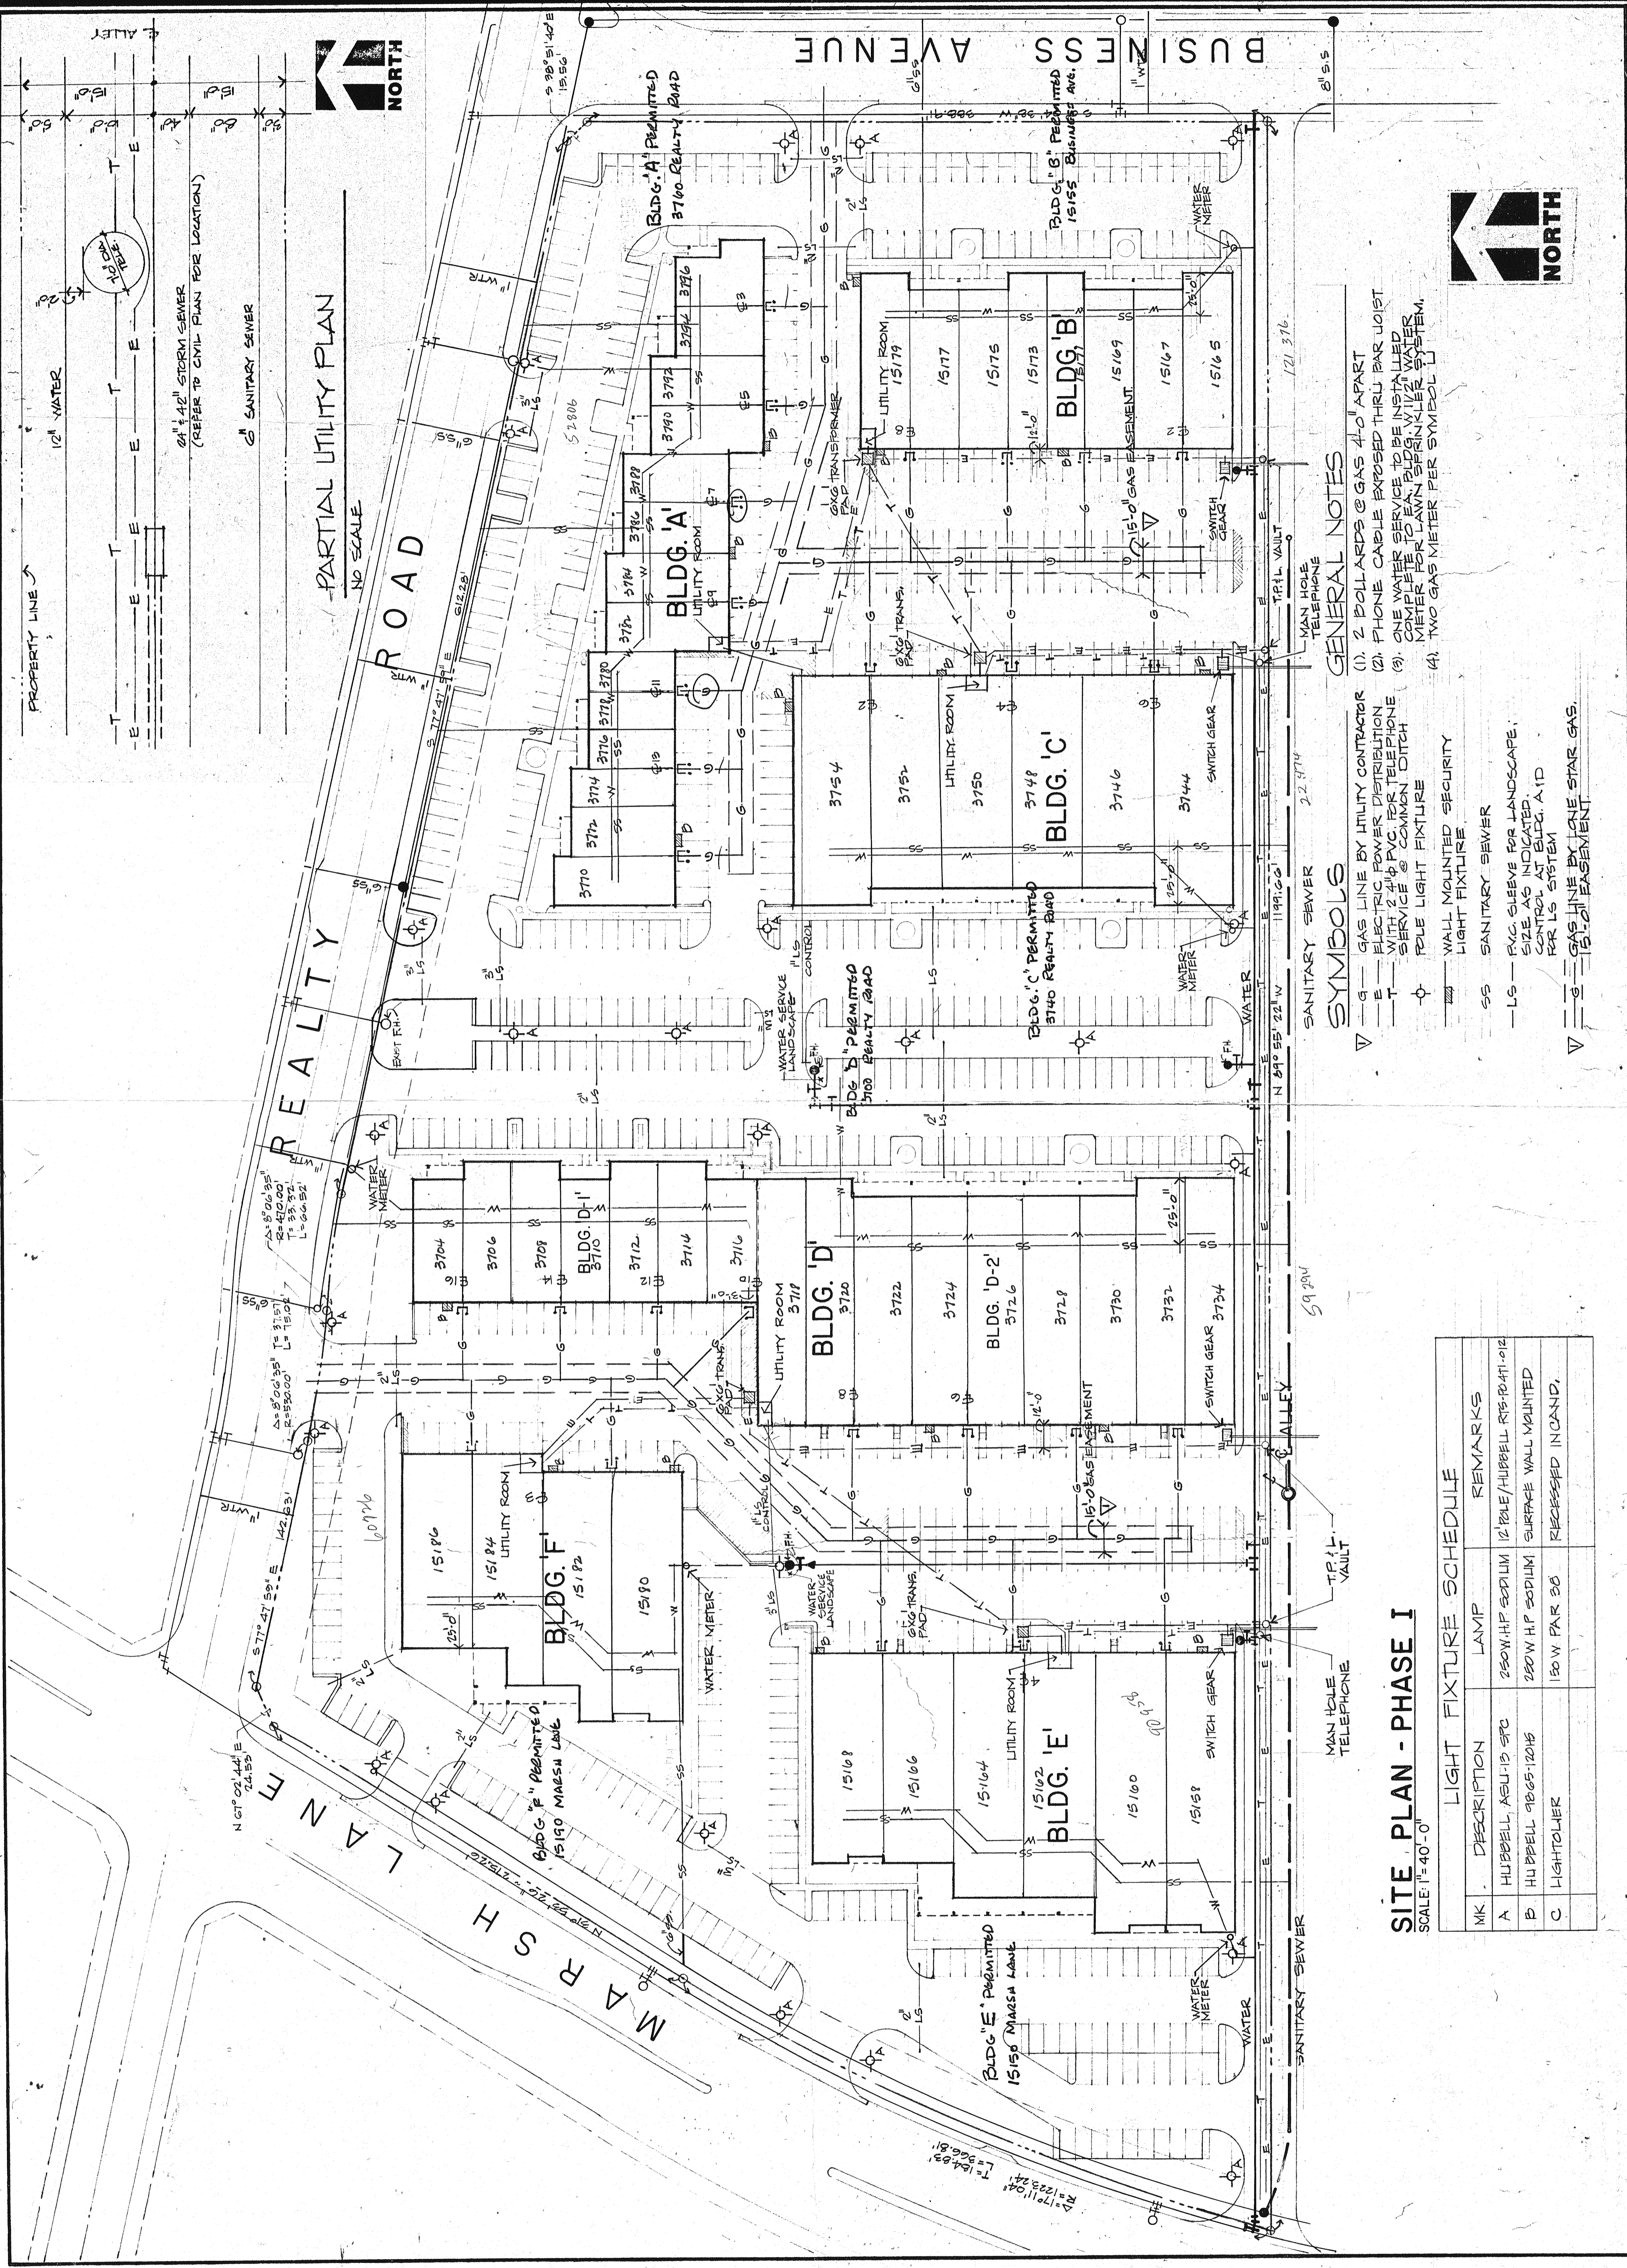

GENERAL NOTES

- (1) 2 BOLLARDS @ GAS 4'-0" APART
- (2) PHONE CABLE EXPOSED THRU BAR JOIST
- (3) ONE WATER SERVICE TO BE INSTALLED COMPLETE TO EA. BLDG. WITH WATER METER FOR LAWN SPRINKLER SYSTEM.
- (4) TWO GAS METER PER SYMBOL 'J'

SYMBOLS

- G - GAS LINE BY UTILITY CONTRACTOR
- E - ELECTRIC POWER DISTRIBUTION WITH 2" P.V.C. FOR TELEPHONE SERVICE & COMMON DITCH
- T - TELEPHONE
- ⊕ - FOLE LIGHT FIXTURE
- ⊕ - WALL MOUNTED SECURITY LIGHT FIXTURE
- SS - SANITARY SEWER
- LS - P.V.C. SLEEVE FOR LANDSCAPE. SIZE AS INDICATED. CONTROL AT BLDG. A 1D FOR LS SYSTEM
- ⊕ - GAS LINE BY ONE STAR GAS

SITE PLAN - PHASE I
 SCALE: 1" = 40'-0"

MK	DESCRIPTION	LAMP	REMARKS
A	HUBBELL, ASU-15 SFC	250W H.P. SODIUM	12" HUBBELL R15-R41-012
B	HUBBELL 9065-12016	250W H.P. SODIUM	SURFACE WALL MOUNTED
C	LIGHTTOWER	150 W. PAR 20	RECESSED INCAND.

LIGHT FIXTURE SCHEDULE