

# ROADWAY LIGHTING AND LANDSCAPE IMPROVEMENTS TO MEDIAN

# BELT LINE ROAD FROM MARSH LANE TO DALLAS NORTH TOLLWAY

BID NUMBER 11-12

*Addison!*

ISSUED FOR CONSTRUCTION 6/1/11

### INDEX OF SHEETS

SHEET NO.	DESCRIPTION
1	COVER SHEET / LOCATION MAP
2 - 14	ROADWAY LIGHTING PLAN
15 - 20	ELECTRICAL DETAILS
21 - 30	REMOVAL & LAYOUT PLANS
31 - 40	LANDSCAPE & IRRIGATION PLANS
41	HARDSCAPE, LANDSCAPE & IRRIGATION DETAILS
42	MATERIALS AND QUANTITIES

JOE CHOW  
MAYOR

BRUCE ARFSTEN	BLAKE W. CLEMENS
ROGER S. MELLOW	NEIL RESNICK
KIMBERLY LAY	BIANCA R. NOBLE


#### COUNCIL MEMBERS

RON WHITEHEAD  
CITY MANAGER

LEA DUNN  
DEPUTY CITY MANAGER

NANCY CLINE, P.E.  
DIRECTOR OF PUBLIC WORKS

SLADE STRICKLAND  
DIRECTOR OF PARKS DEPARTMENT

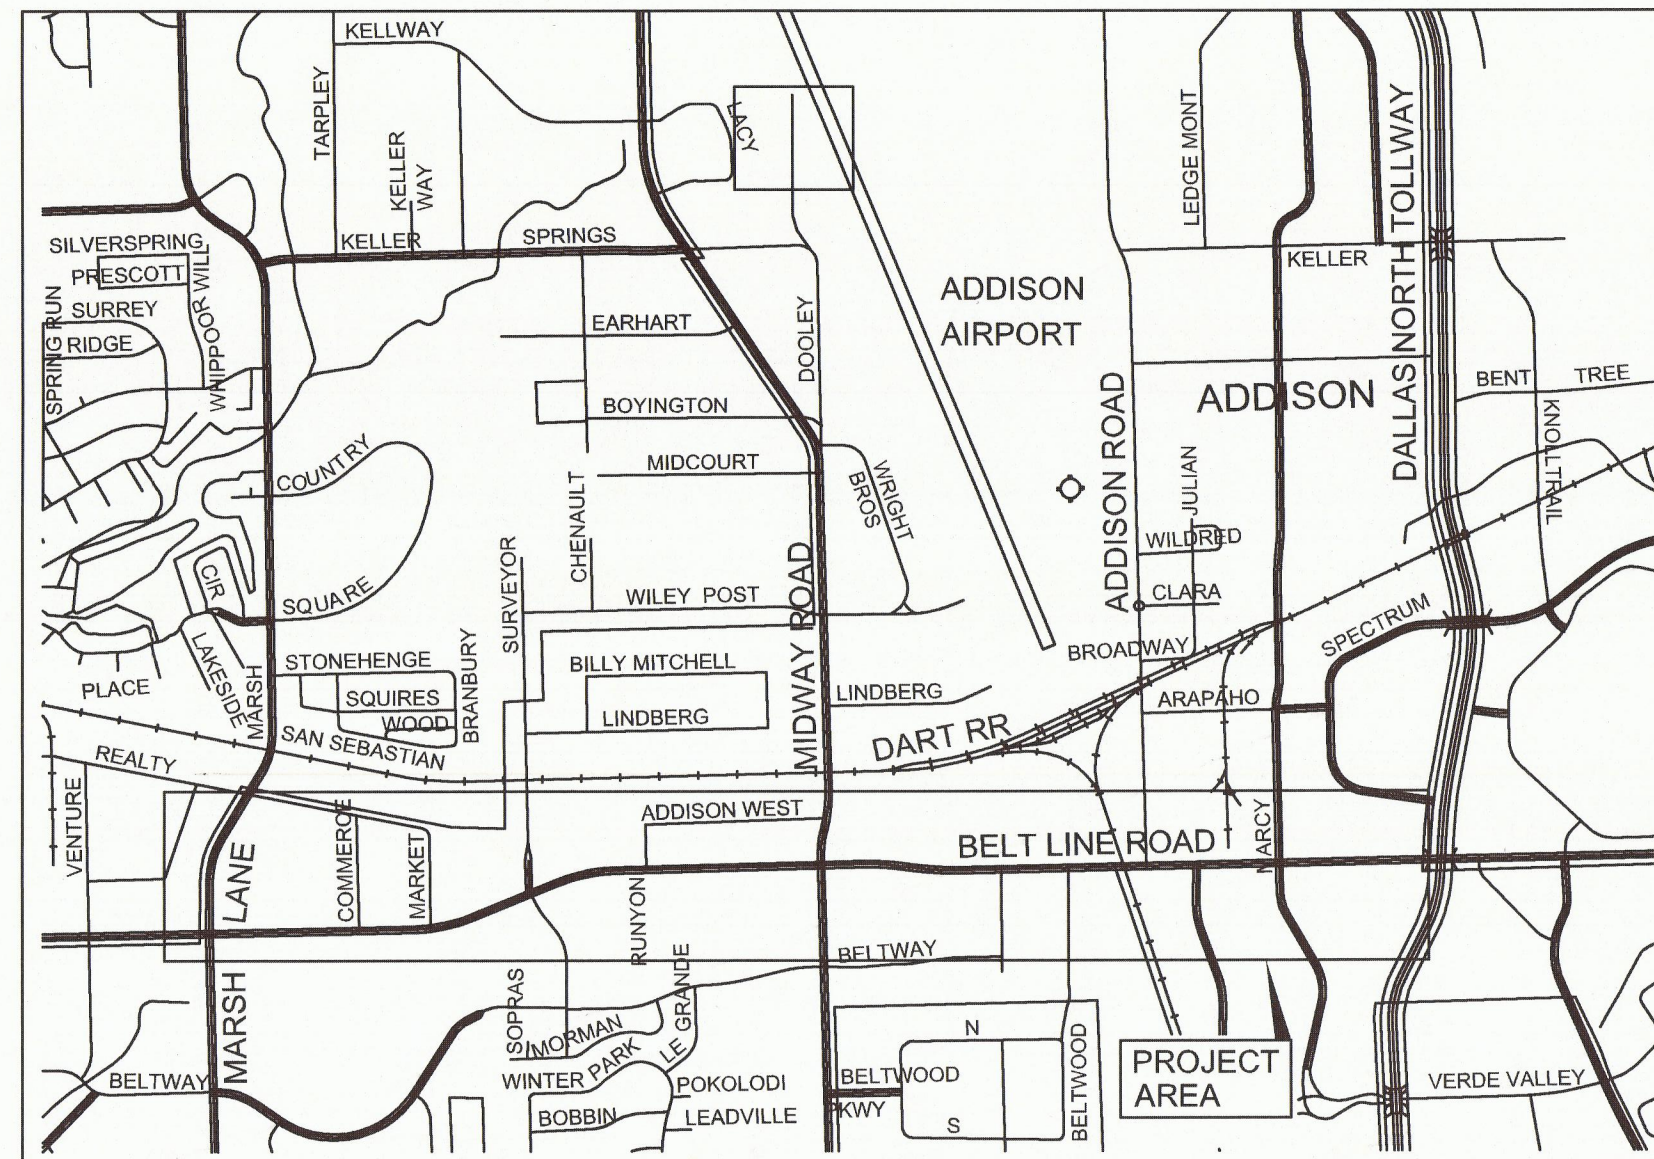

LOCATION MAP  
NOT TO SCALE



△ Addendum 1 - Revisions



OWNER:

TOWN OF ADDISON  
DEPARTMENT OF PUBLIC WORKS  
16801 WESTGROVE  
P.O. BOX 9010  
ADDISON, TEXAS 75001-9010  
(972) 450-2871

△ WARNING: Contractor must contact Texas One-Call System (dial 811) at least 48 hours prior to construction activities. HNTB Corp. is not responsible for knowing all existing utilities in the project area and not responsible for indicating the location of all existing utilities on the drawings. This note applies to all drawing sheets included for this project.