

**GENERAL NOTES:**

1. EXISTING POLES AND LUMINAIRES ARE TO BE REMOVED AND CAREFULLY HANDLED AT ALL TIMES TO LIMIT ANY DAMAGE. CONTRACTOR IS TO DELIVER ALL POLES AND LUMINAIRES TO ONCOR AT 1015 HUTTON, CARROLLTON, TX, WITH THE FOLLOWING EXCEPTIONS. FOUR OF THE EXISTING POLES AND LUMINAIRES ARE THE PROPERTY OF ADDISON AND ARE TO BE DELIVERED TO THE TOWN'S MAINTENANCE FACILITY. TWO OF THE EXISTING POLES AND LUMINAIRES ARE THE PROPERTY OF THE NTTA AND ARE TO BE DELIVERED TO NTTA MAINTENANCE CENTER AT 1080 OHIO DRIVE, PLANO, TX.
2. REMOVE ALL GROUND BOXES AND RELATED EQUIPMENT.
3. ALL EXISTING CONDUCTORS SHALL BE DISCONNECTED FROM SERVICE AND REMOVED FROM CONDUIT.
4. REMOVE EXISTING POLE BASES TO ALLOW MIN. 24" SOIL COVER.
5. THERE ARE EXISTING LIGHTING AND TRAFFIC SIGNAL CONDUCTORS THAT MUST BE PROTECTED AND REMAIN OPERATIONAL. SOME OF THESE CONDUCTORS MAY BE DIRECT BURY CABLE, NOT INSTALLED IN CONDUITS. LOCATE ALL CONDUITS AND CABLES, INCLUDING RUNS FROM MEDIAN TO EITHER SIDE OF BELT LINE ROAD AND USE EXTREME CARE WHEN EXCAVATING IN THESE LOCATIONS.


**NOTE:**

1. ALL DIMENSIONS ARE TAKEN FROM THE CENTER OF THE POLE BASE.
2. THE GENERAL NOTES ON THIS SHEET APPLY TO THIS SHEET AND THE REMAINING ROADWAY LIGHTING PLANS.

**LIGHTING LEGEND**

- FUTURE LIGHT POLE
- PROPOSED SINGLE LUMINAIRE ON CURVED 55' RADIUS POLE
- PROPOSED TWIN LUMINAIRE ON CURVED 40' RADIUS POLE
- EXISTING LIGHT POLE TO BE REMOVED
- TRENCHED CONDUIT
- BORED CONDUIT
- PROPOSED GROUND BOX
- PROPOSED LIGHTING CONTROLLER

- A 1-1**
- POLE NUMBER
  - CIRCUIT NUMBER
  - CONTROLLER
- (A)** 2"C, 2#4, 1#4 BARE GND
  - (B)** 2"C, 4#4, 1#4 BARE GND
  - (C)** 2-2"C, 8#4, 1#4 BARE GND

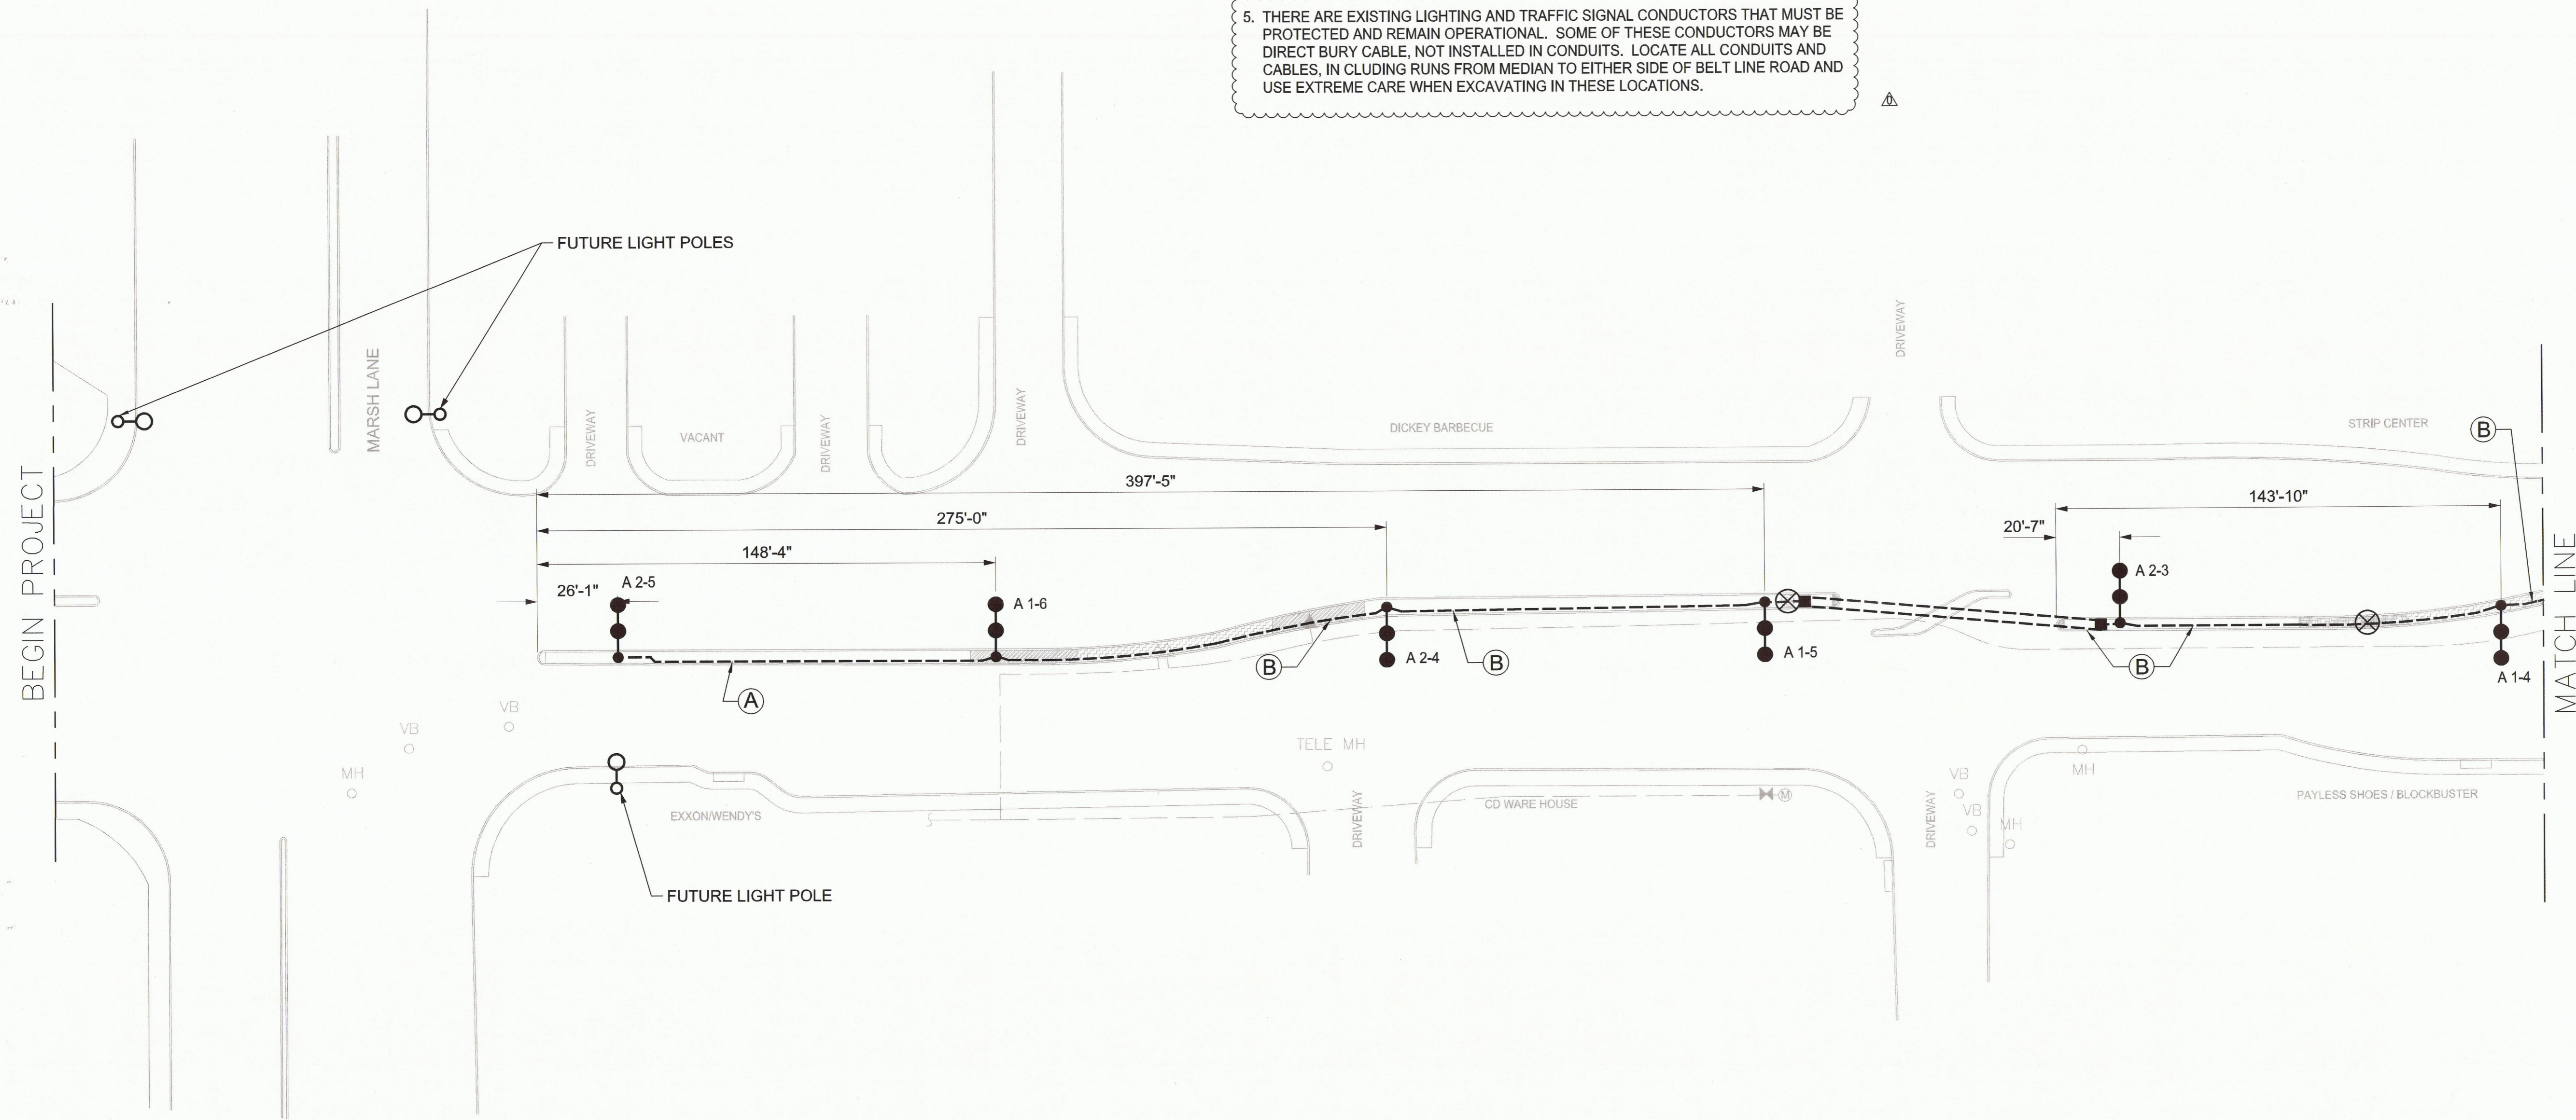

ISSUED FOR CONSTRUCTION - 6/1/11

NO.	DATE	REVISION	APPROV.
△	6/01/2011	ADDENDUM 1 REVISIONS	JGS

**HNTB** ARCHITECTS ENGINEERS PLANNERS  
The HNTB Companies - TBPE Firm No. 420  
2001 BRYAN STREET, SUITE 100  
DALLAS, TEXAS 75201 (214) 748-8400

**BELT LINE ROAD MEDIAN**  
MARSH LANE TO DALLAS N. TOLLWAY

ROADWAY LIGHTING PLAN

TOWN OF ADDISON, TEXAS

DESIGN	RS	DRAWN	FH	DATE	SCALE	HNTB NO.	SHEET NO.
CHECK	JS	CHECK	TK	30-Dec-10		48564	2

