




TYPICAL FIXTURE 'D' INSTALLATION  
SCALE: 3" = 1'-0"

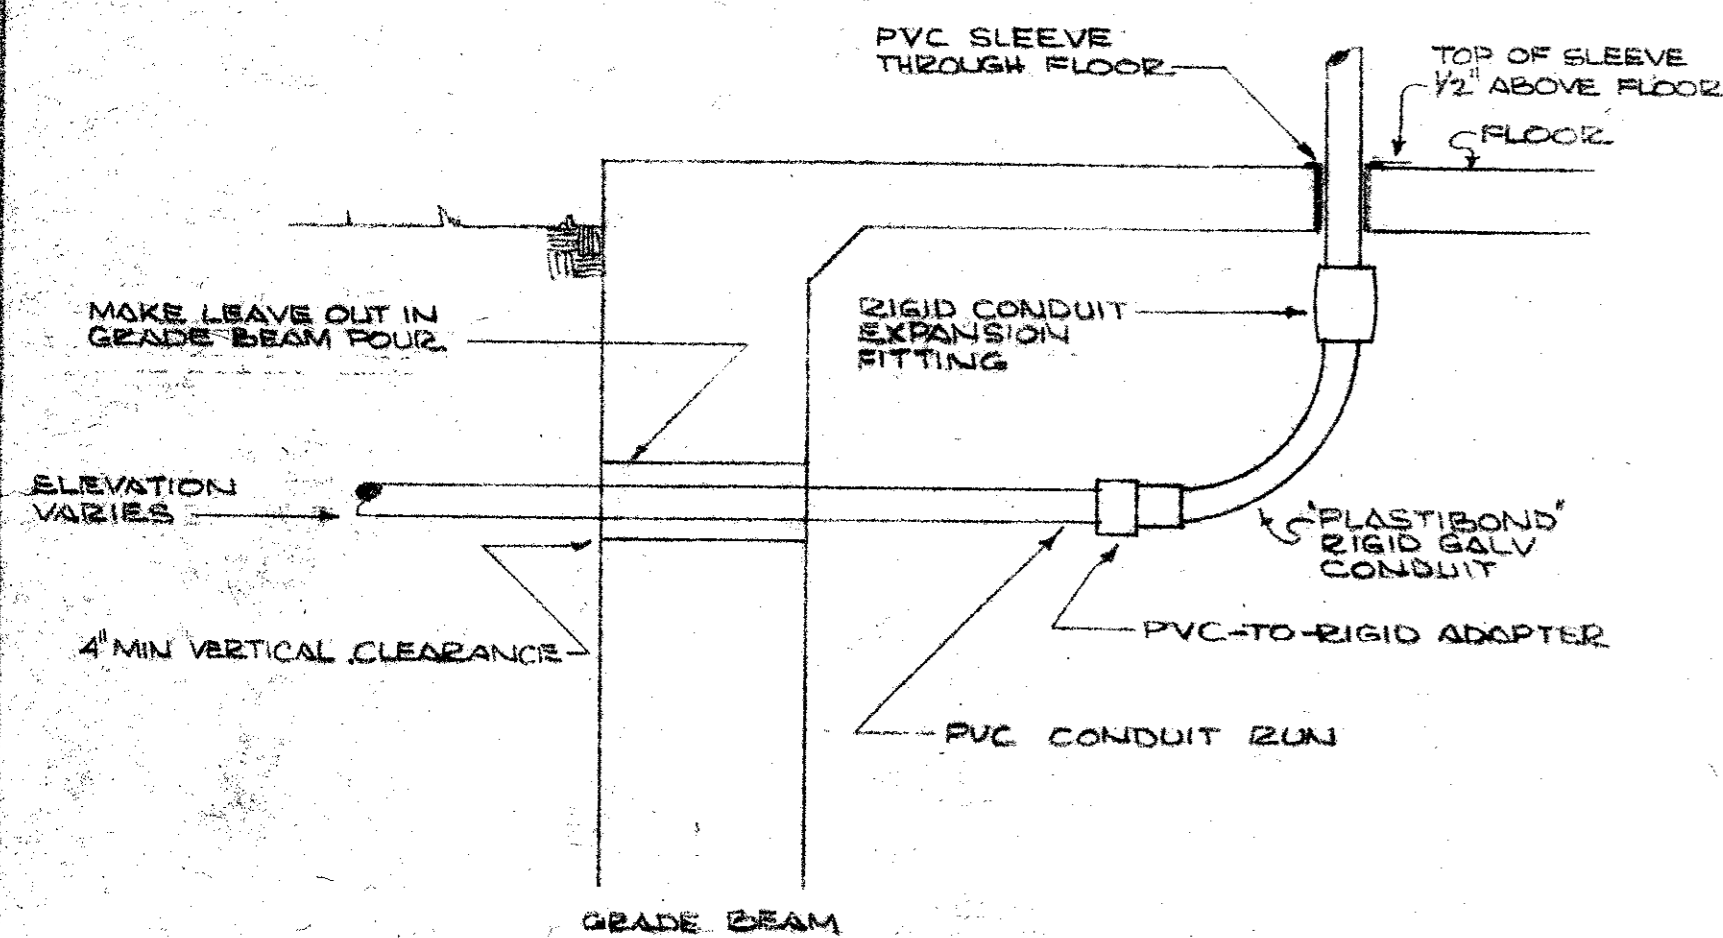


TYPICAL CONDUIT PENETRATION THROUGH BLDG, GRADE BEAM & FLOOR  
NOT TO SCALE

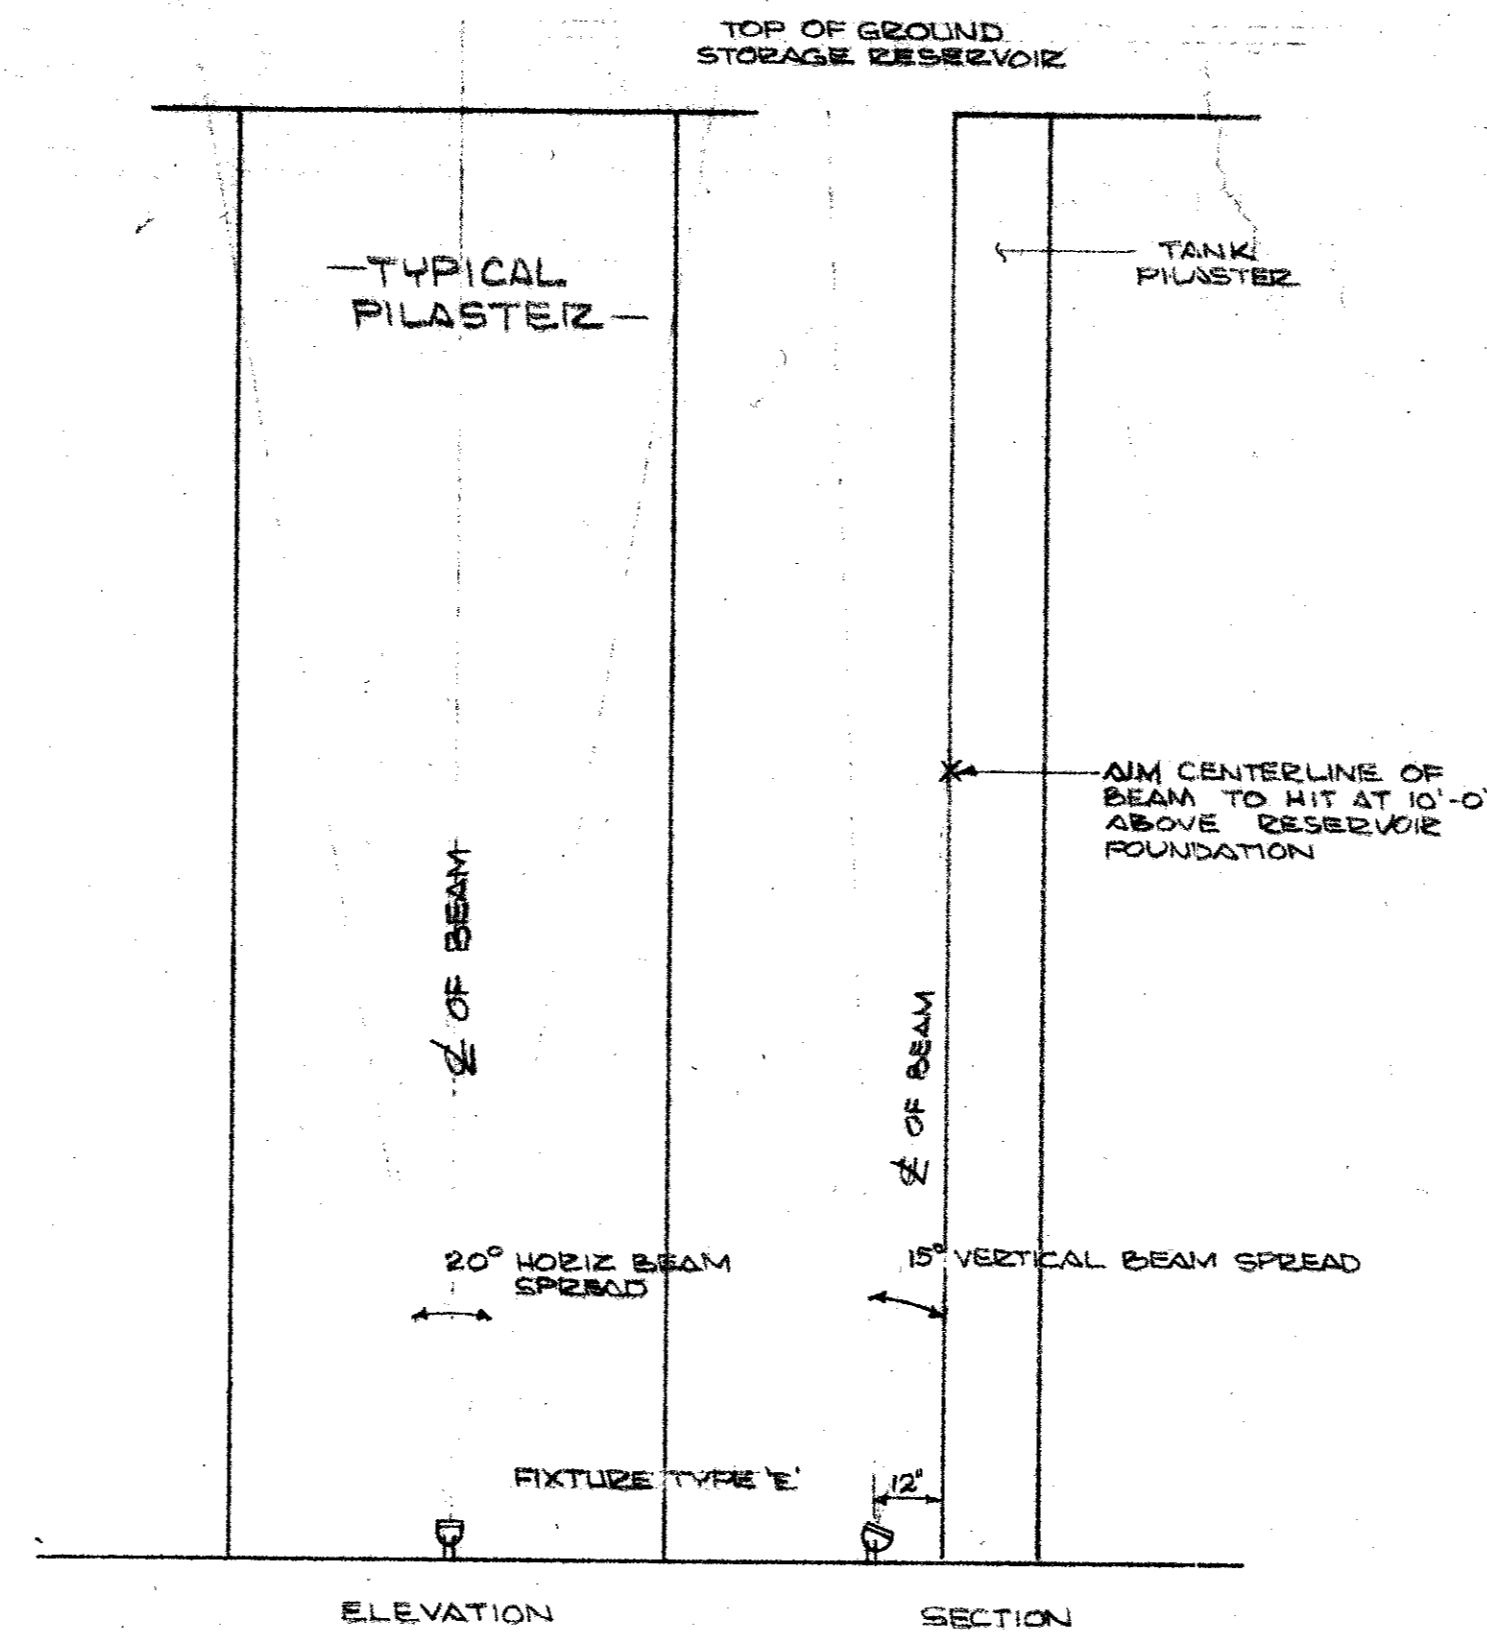


DETAIL OF FIXTURE 'D' INSTALLATION & AIMING (GROUND STORAGE RESERVOIR)  
SCALE: 3/8" = 1'-0"

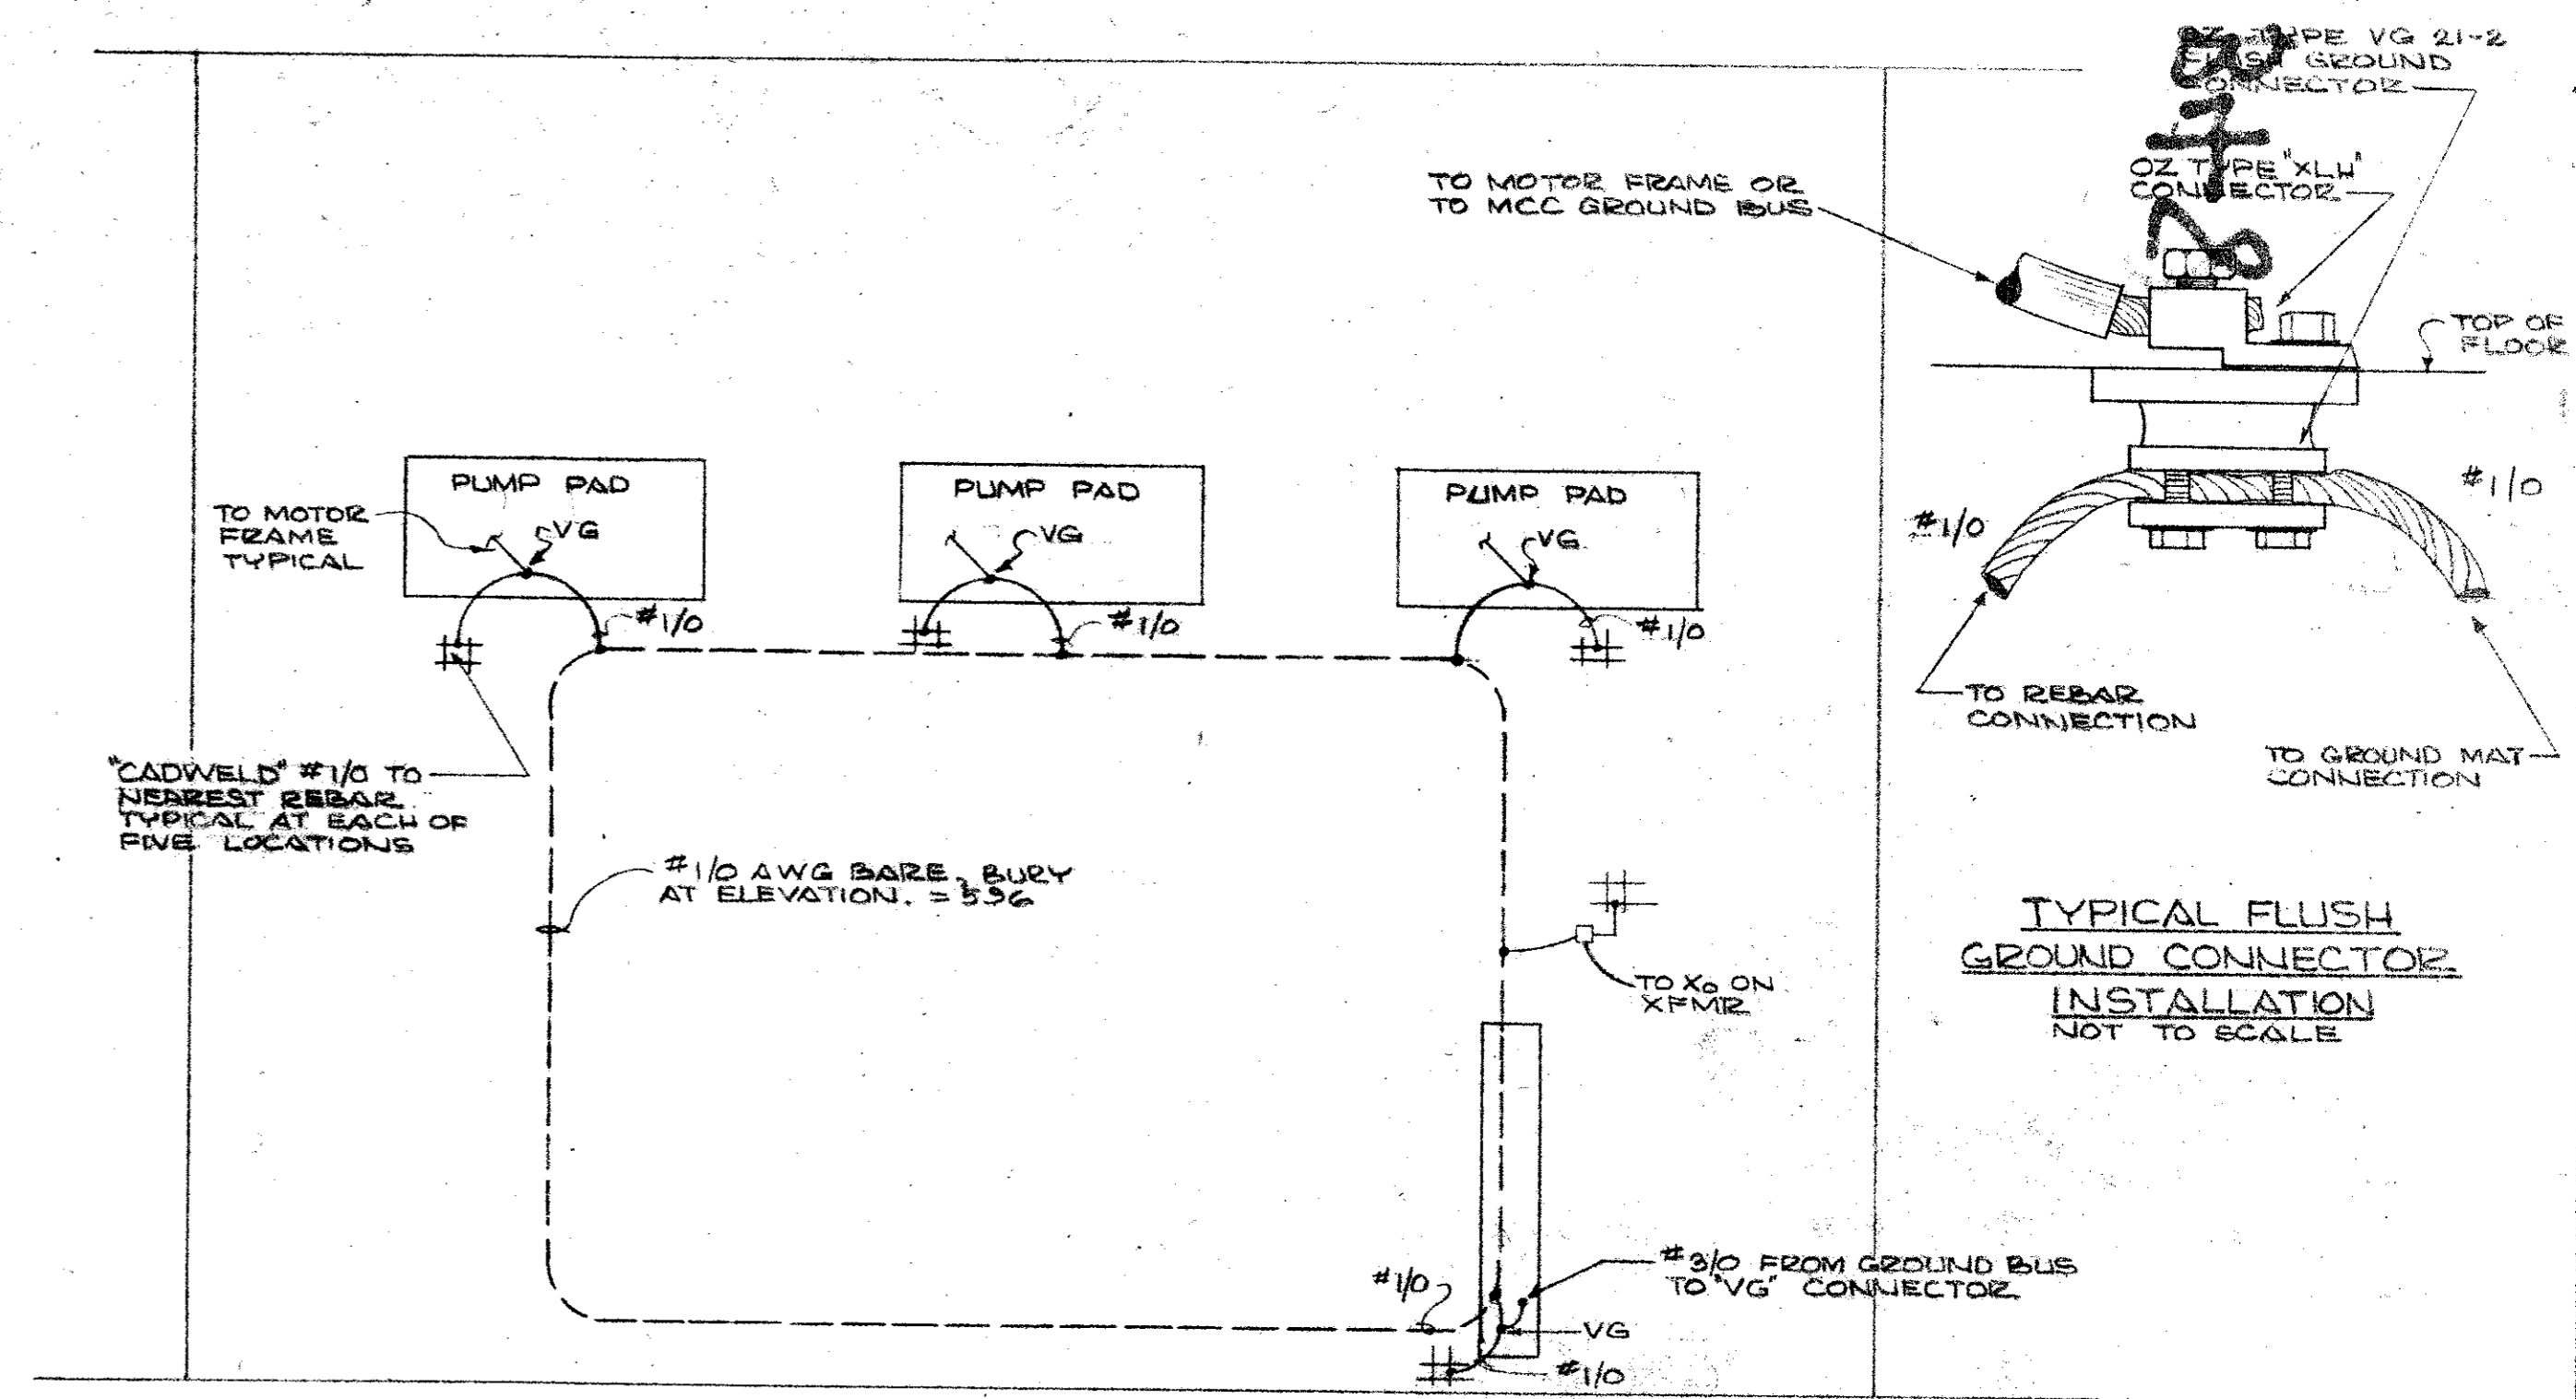

GROUNDING PLAN & DETAILS  
SCALE: 3/16" = 1'-0"

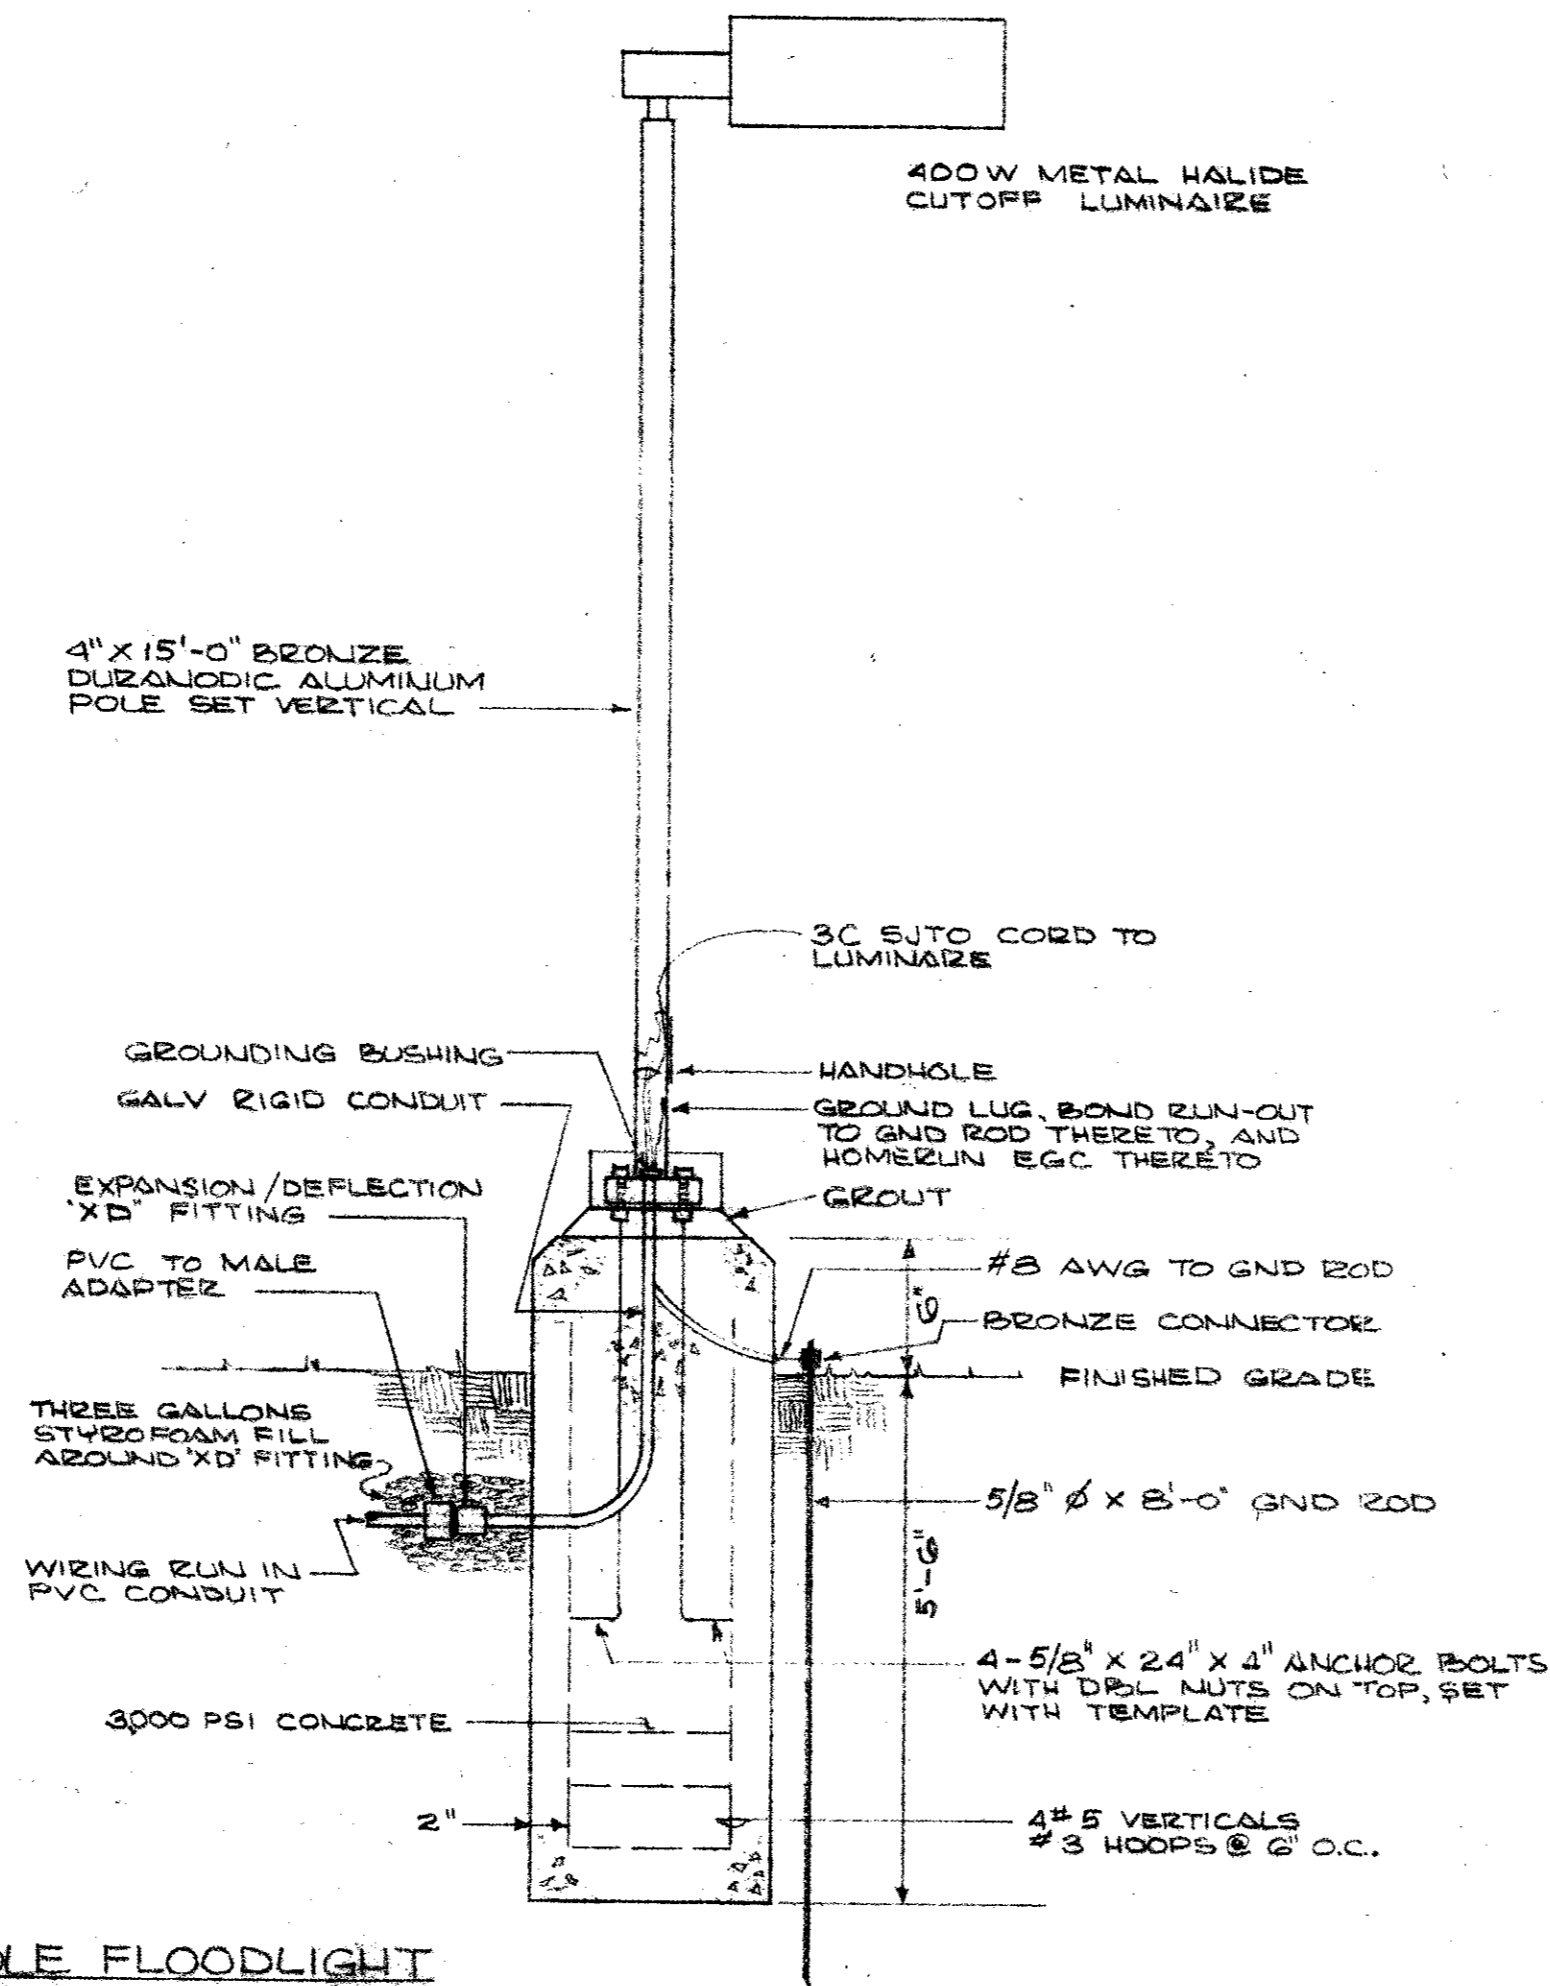

POLE FLOODLIGHT INSTALLATION DETAIL  
NOT TO SCALE

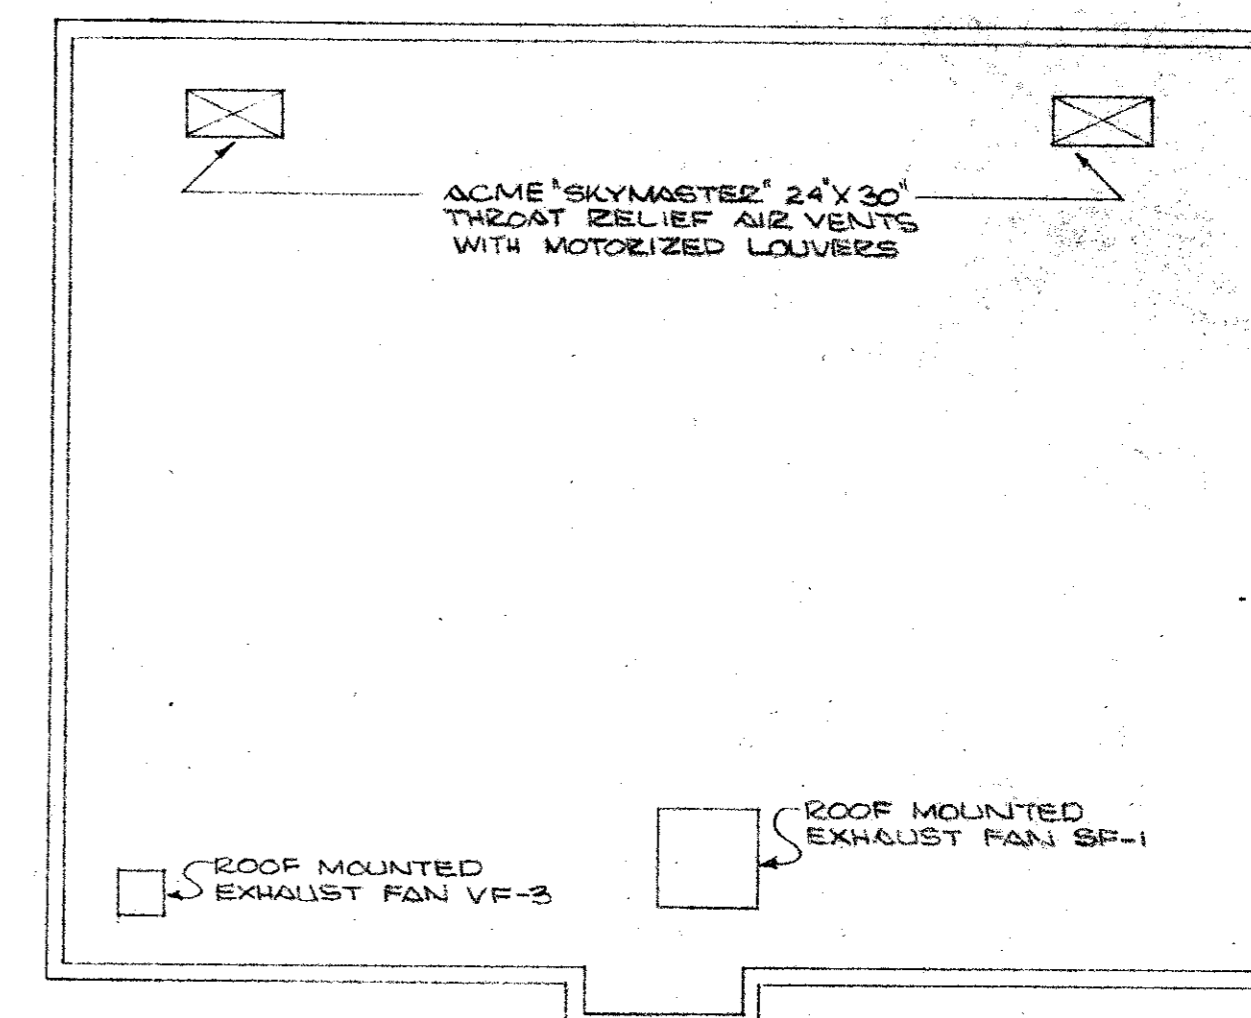

ROOF PLAN OF EXHAUST FANS AND VENTS  
SCALE: 1/8" = 1'-0"

CITY OF ADDISON  
DALLAS COUNTY, TEXAS

WATER PUMP STATION  
AND WATER MAINS

**ELECTRICAL**

GINN & STACY, INC.  
CONSULTING ENGINEERS DALLAS, TEXAS

DESIGNED BY *CSH* SCALE: *AS SHOWN*  
DRAWN BY *W.L.* DATE: *11/11/88*

Sheet 24

