




PARAPET FLASHING

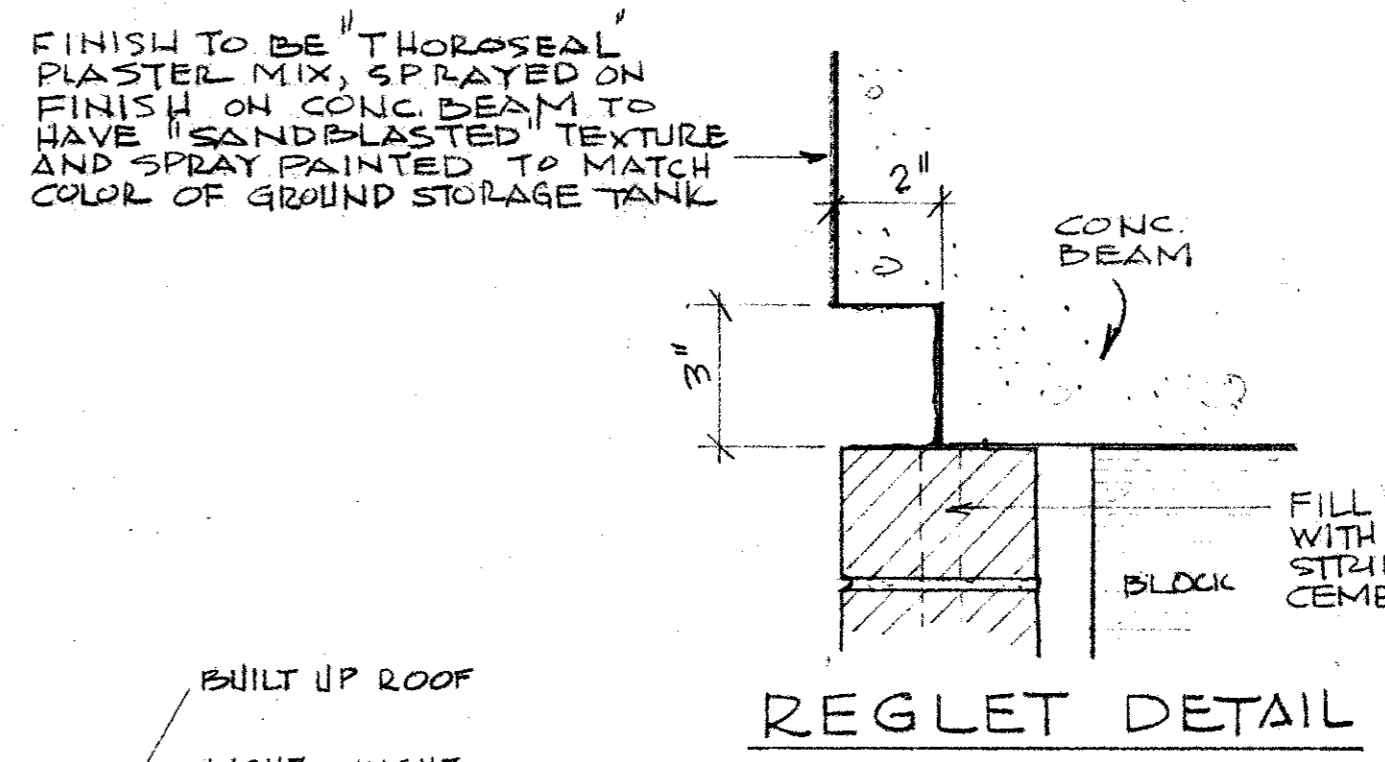


REGLET DETAIL

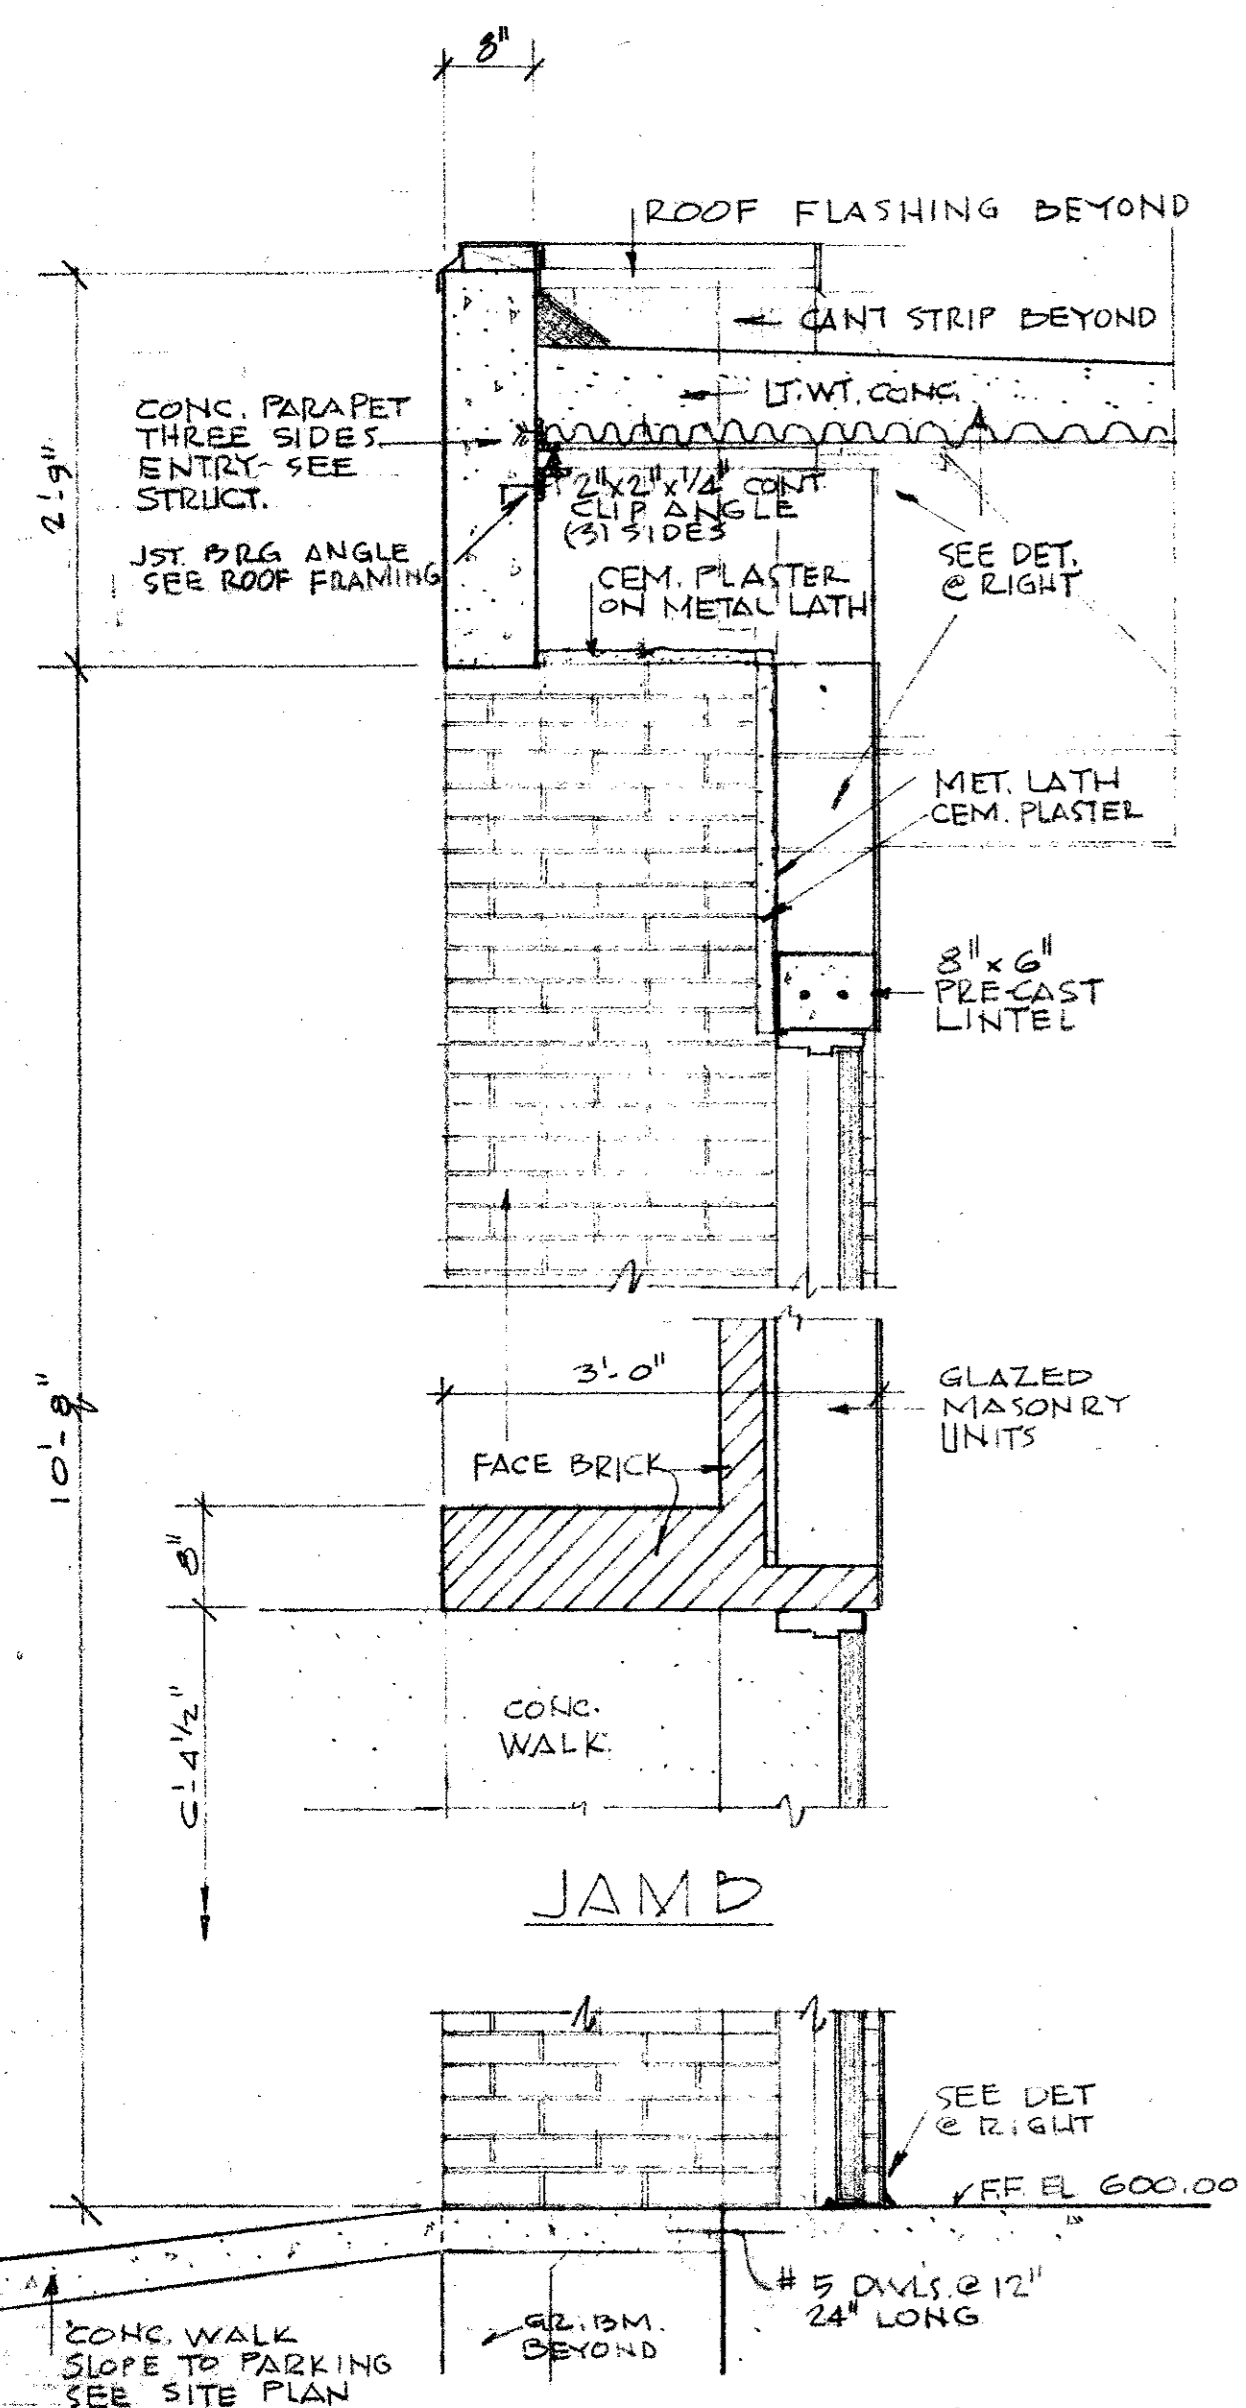


1 ENTRY  
SCALE: 3/4" = 1'-0"

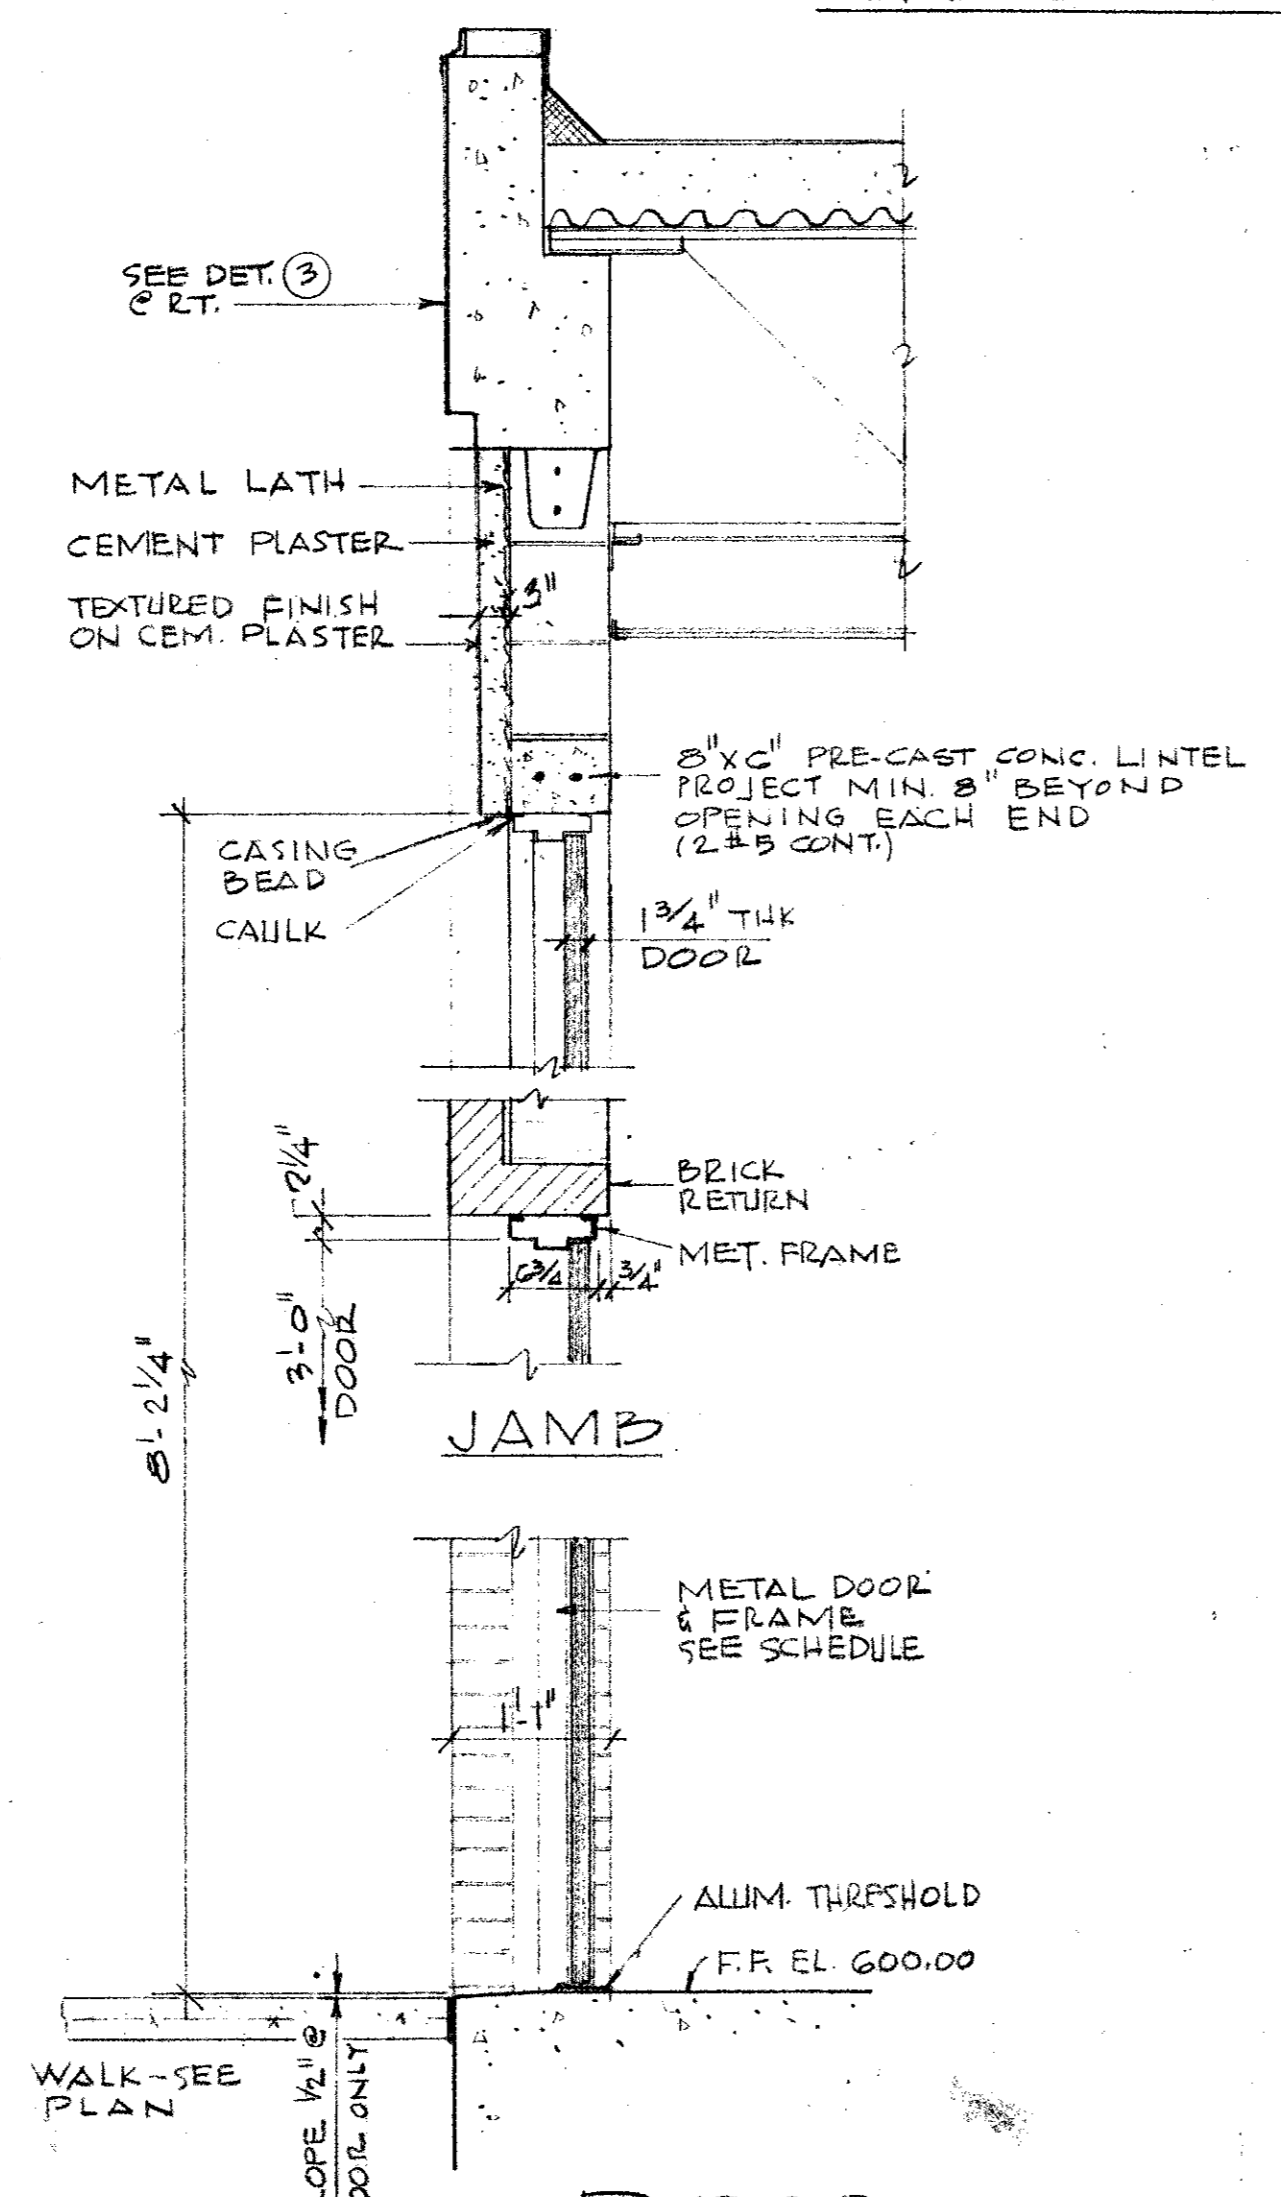

2 DOOR  
SCALE: 3/4" = 1'-0"

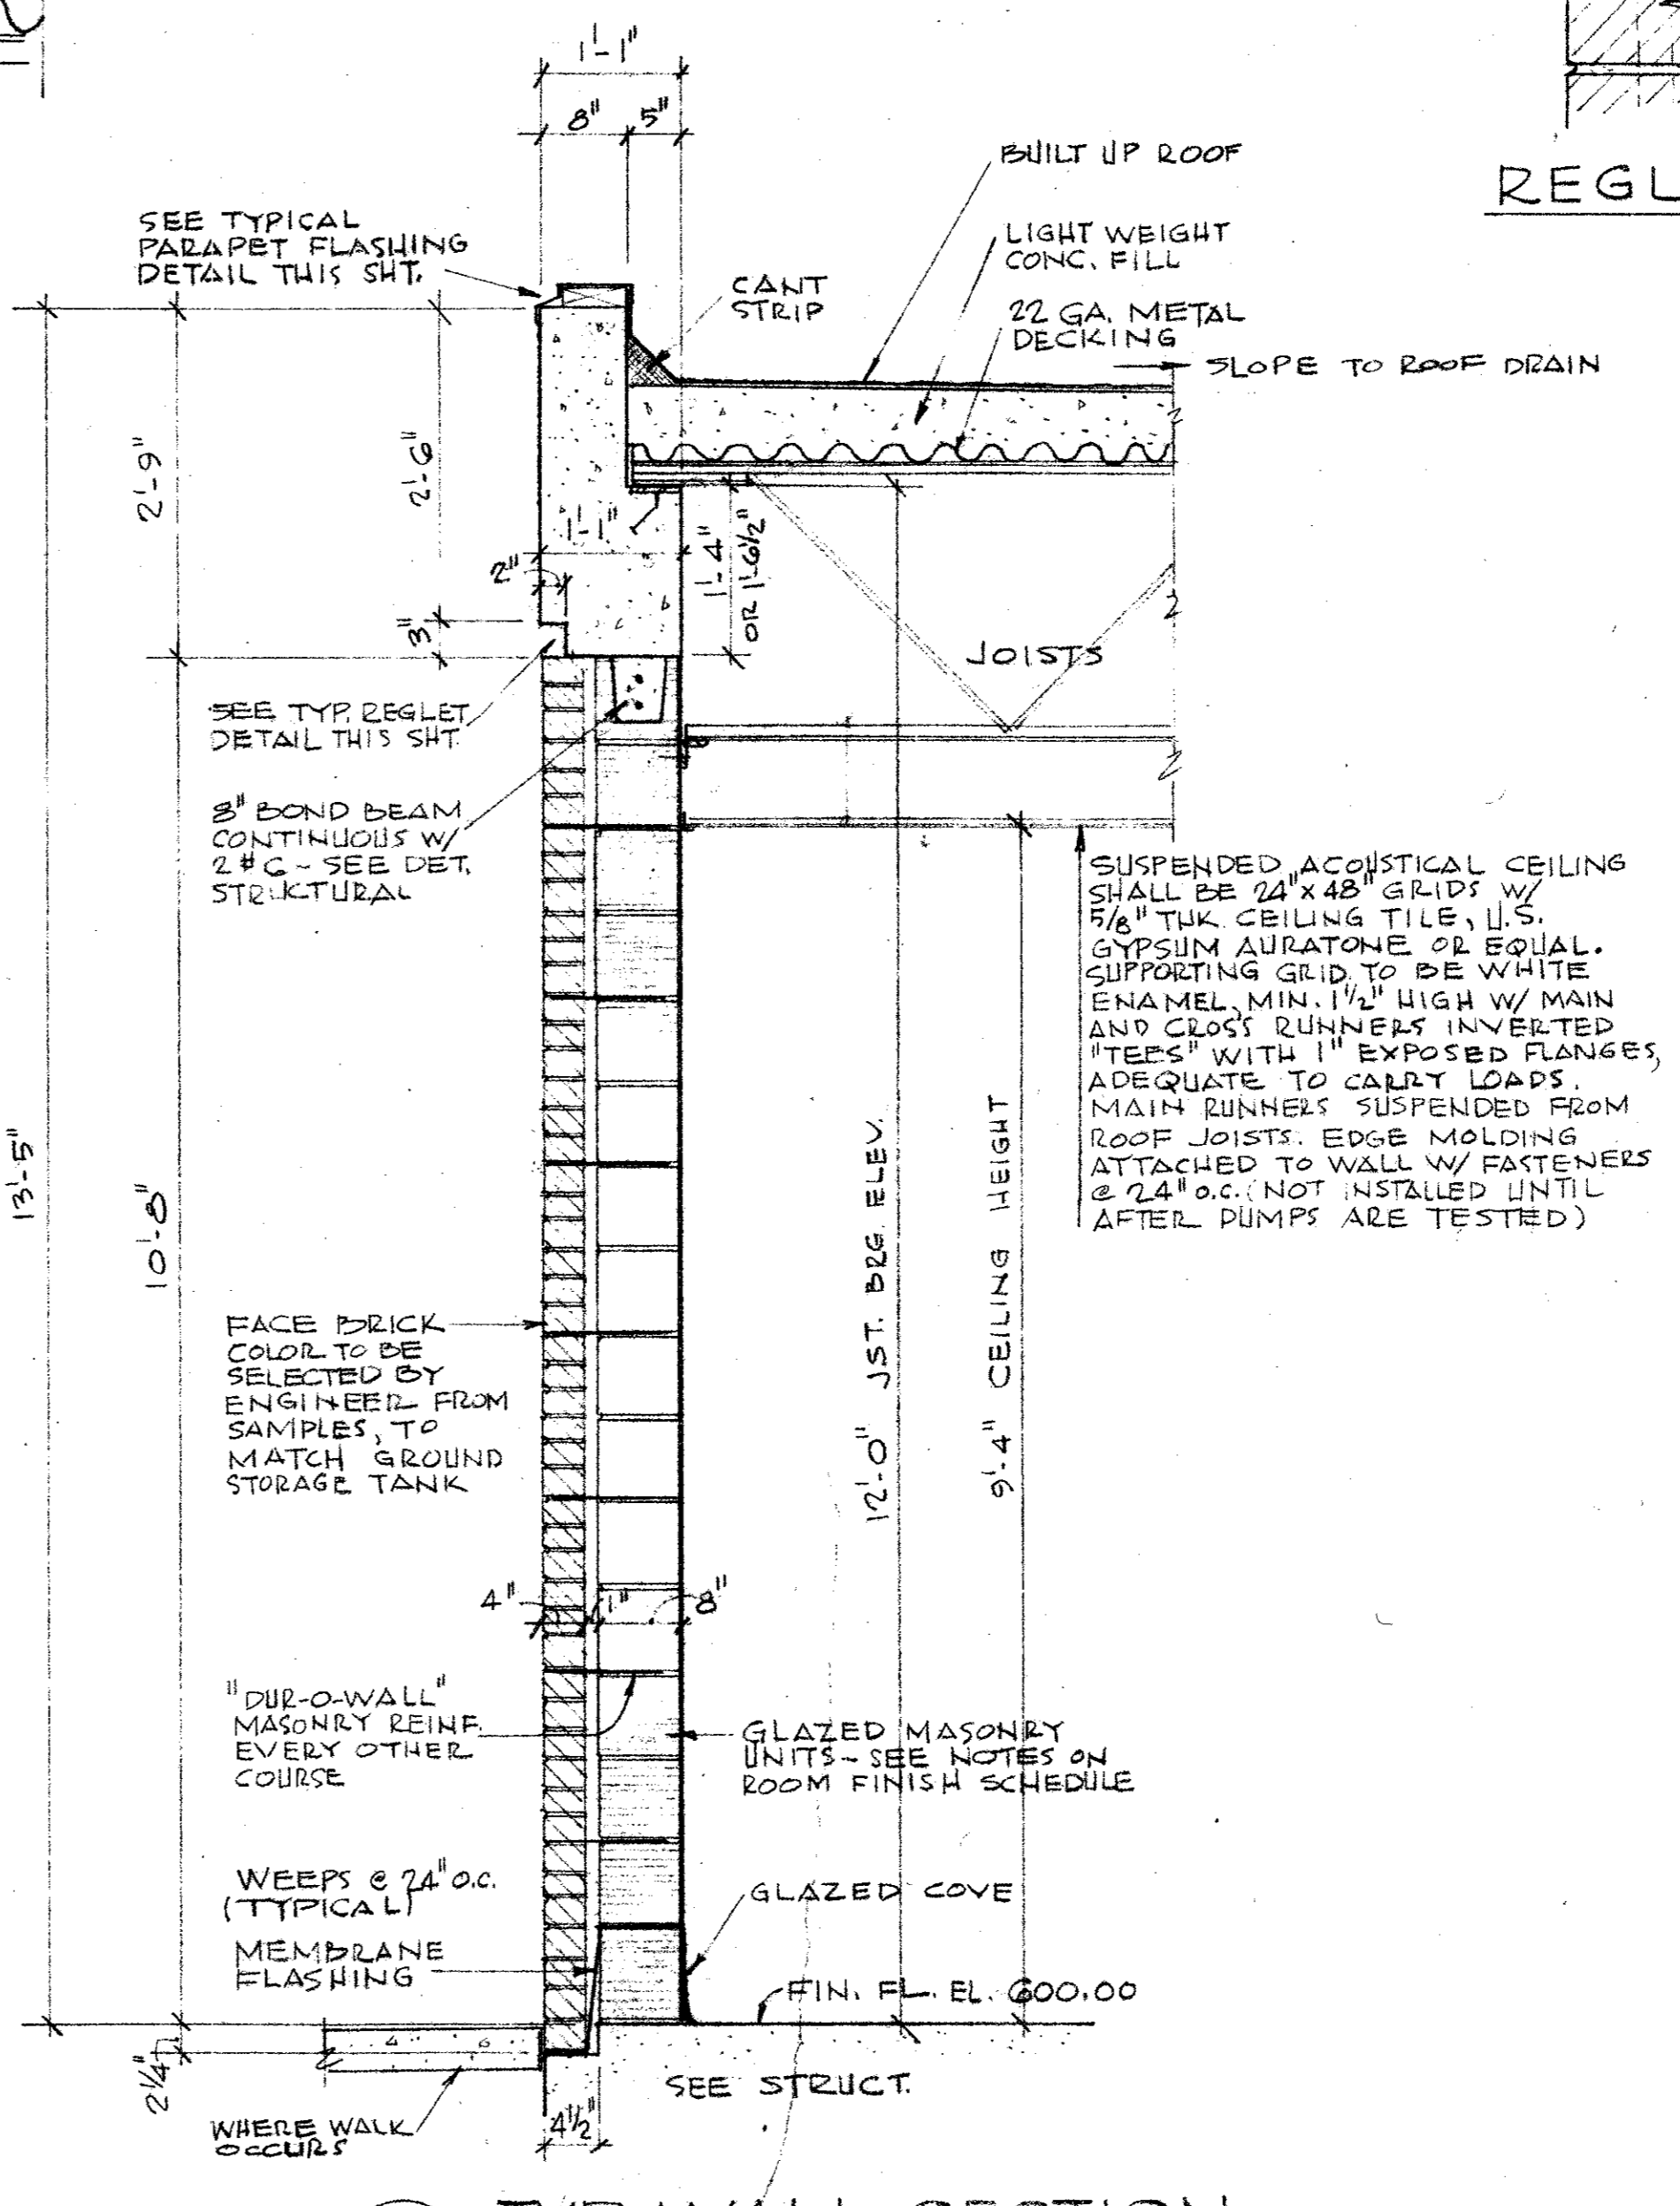


3 TYP. WALL SECTION  
SCALE: 3/4" = 1'-0"

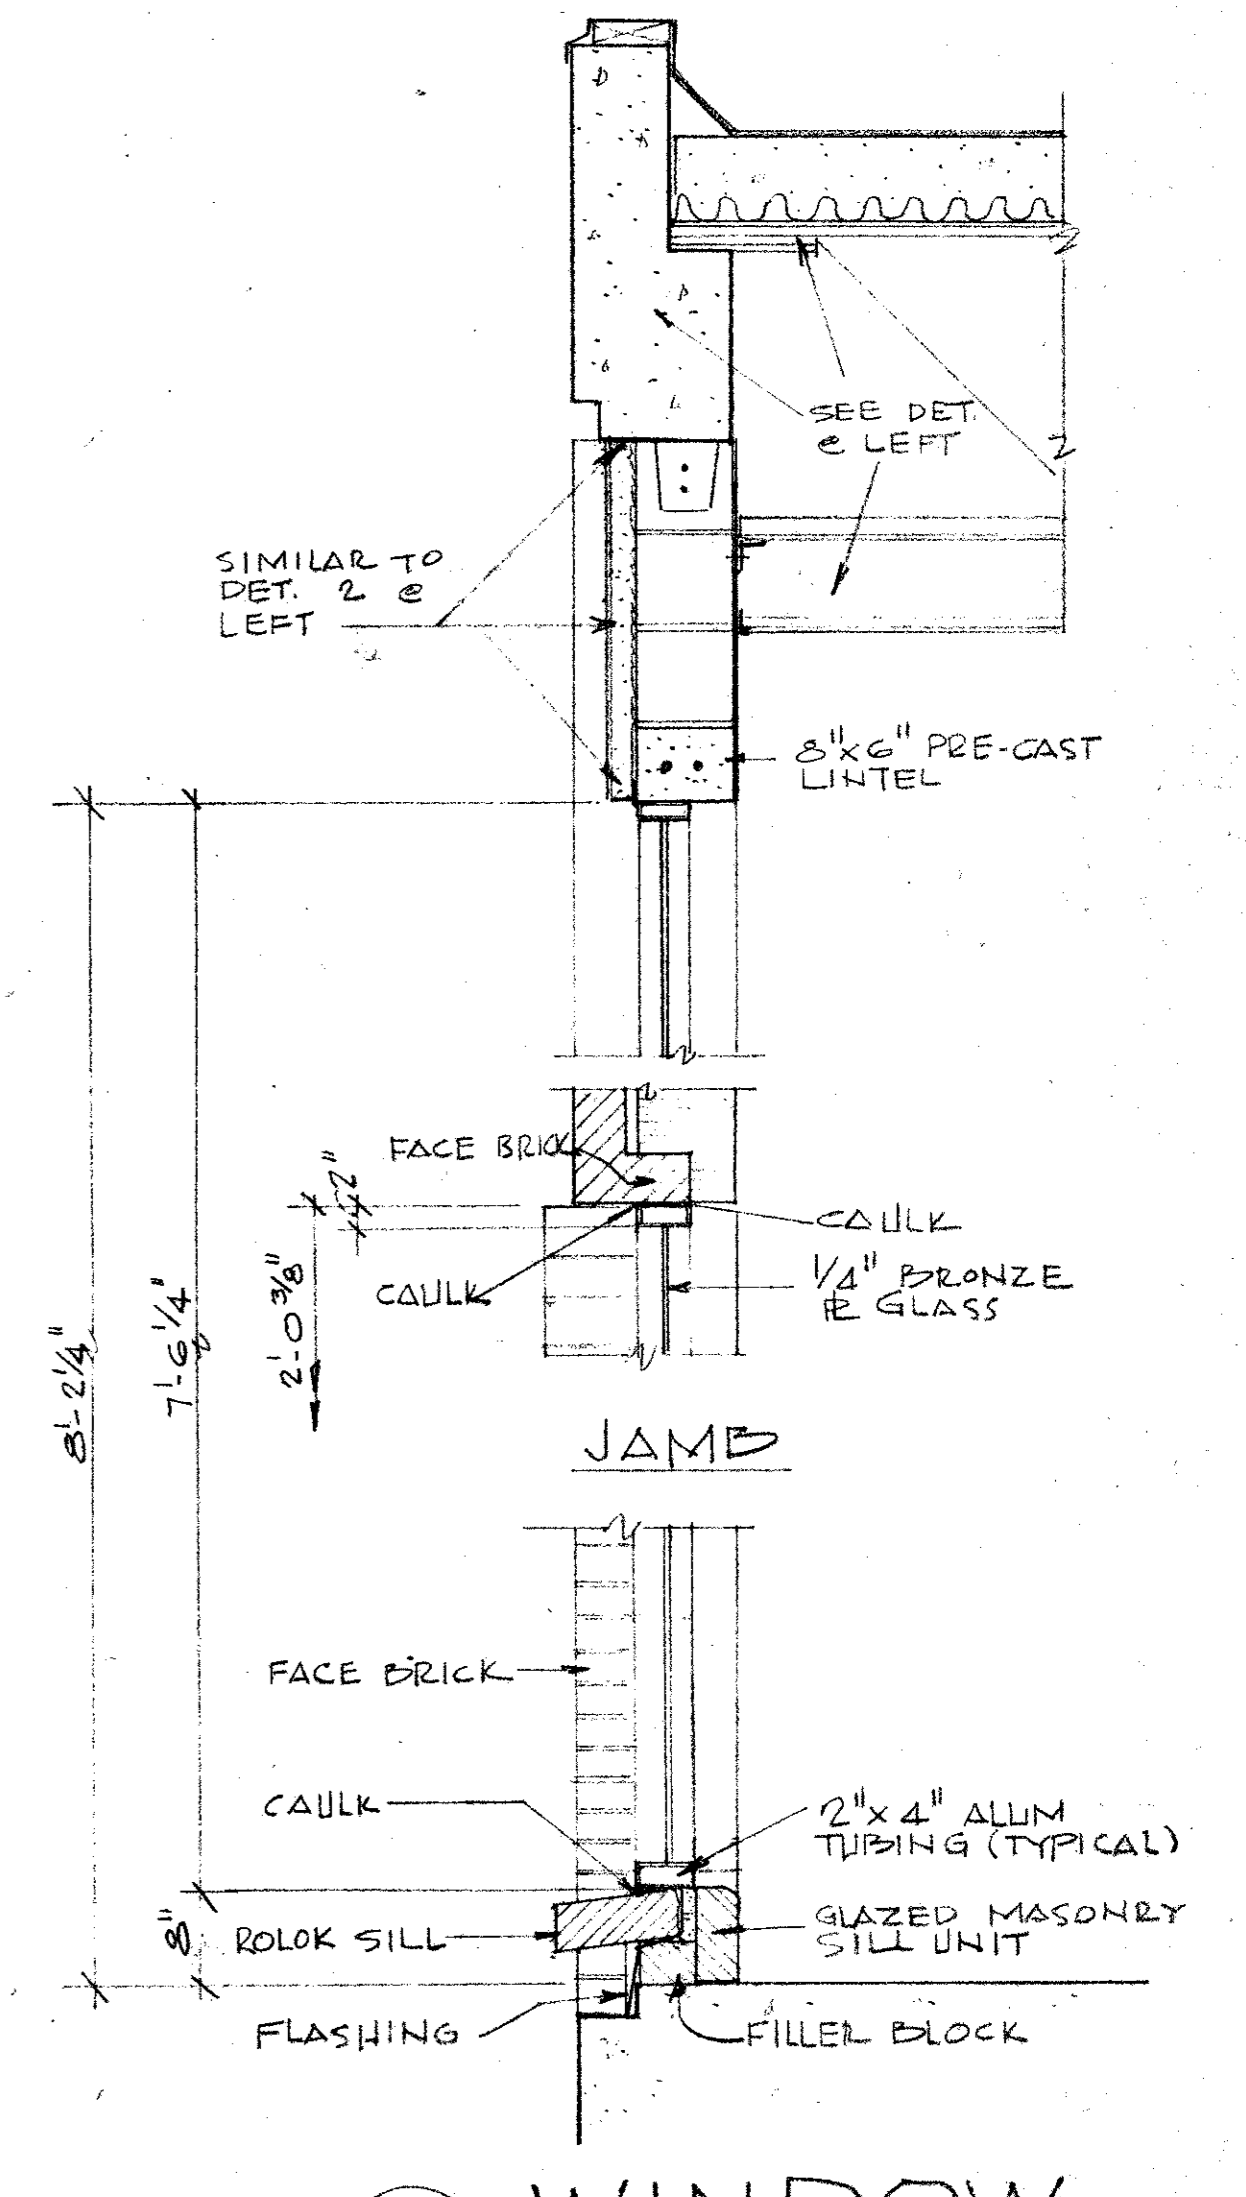

4 WINDOW  
SCALE: 3/4" = 1'-0"

NOTE: ALL DETAIL, DIMENSIONS, NOTES ETC. INDICATED THIS SECTION SHALL APPLY TO ALL OTHER SECTIONS THIS SHEET UNLESS NOTED OTHERWISE.

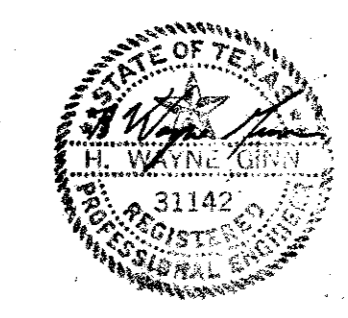

CITY OF ADDISON DALLAS COUNTY, TEXAS	
WATER PUMP STATION AND WATER MAINS	
WALL SECTIONS	
GINN & STACY, INC. CONSULTING ENGINEERS - DALLAS, TEXAS	
DESIGNED BY: <i>WNG</i>	SCALE: AS SHOWN
DRAWN BY: <i>CF</i>	DATE: AUG. 77
Sheet 17 of 24	