



FLOOR PLAN
1/2"=1'-0"

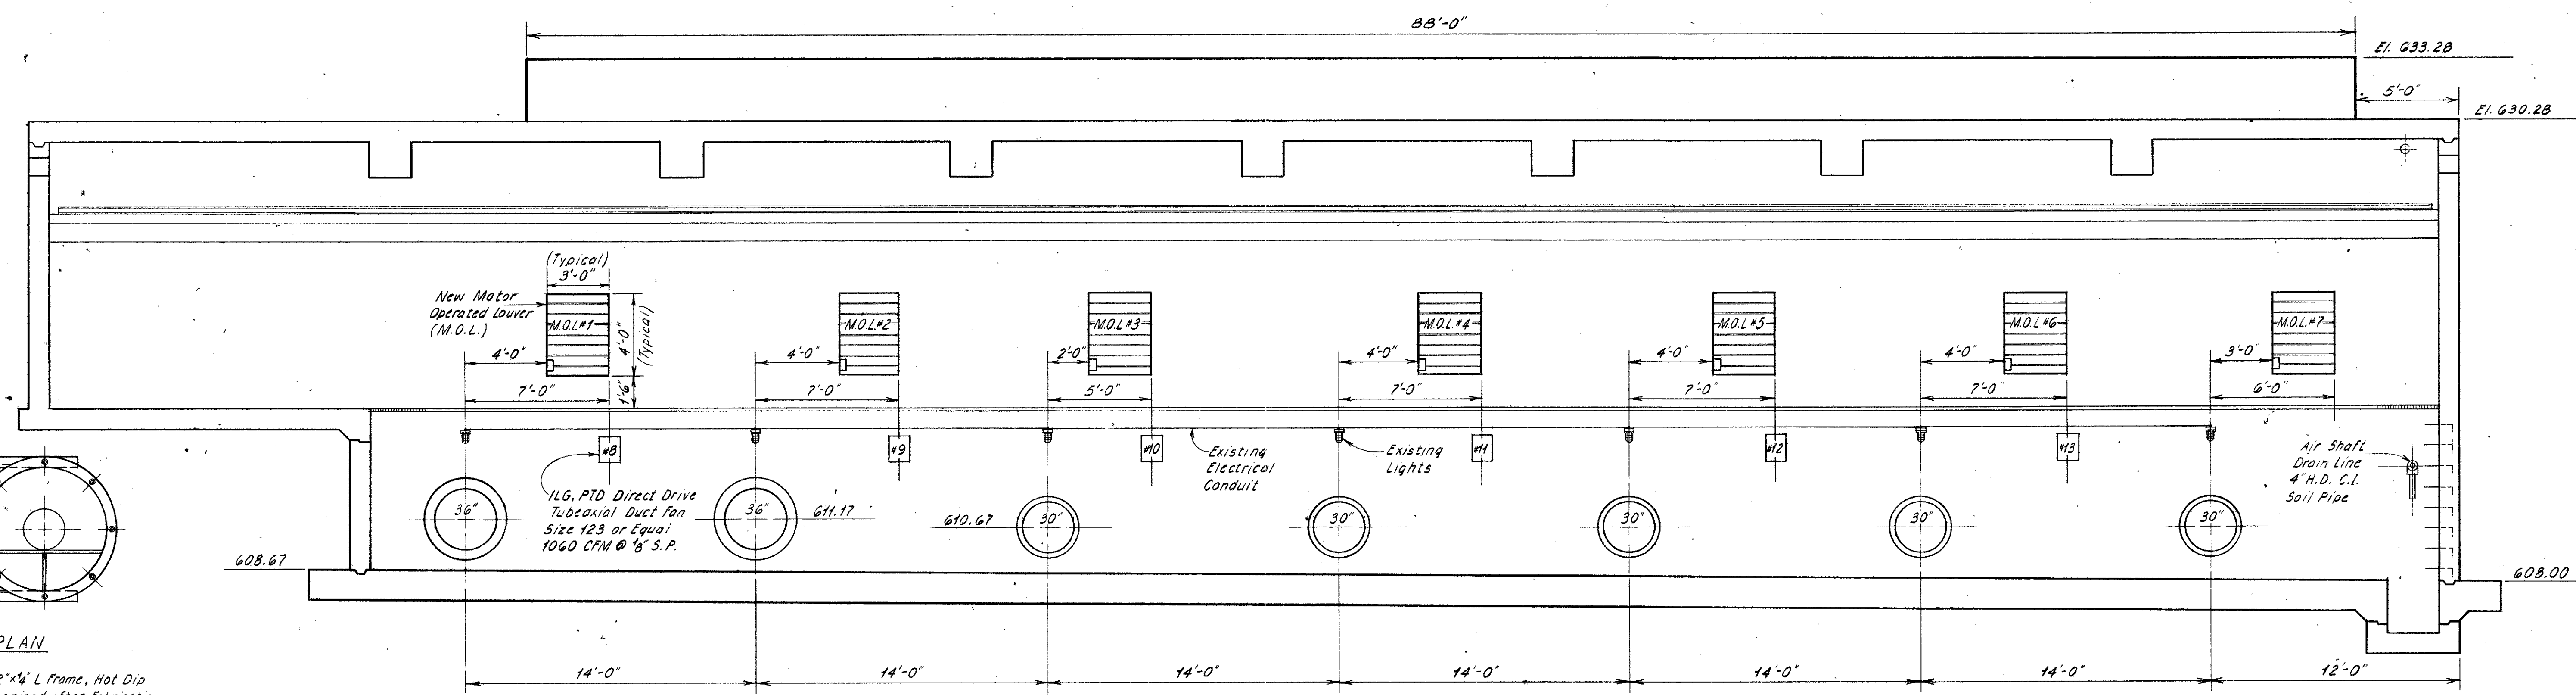

SECTION A-A
WEST WALL ELEVATION
1/2"=1'-0"

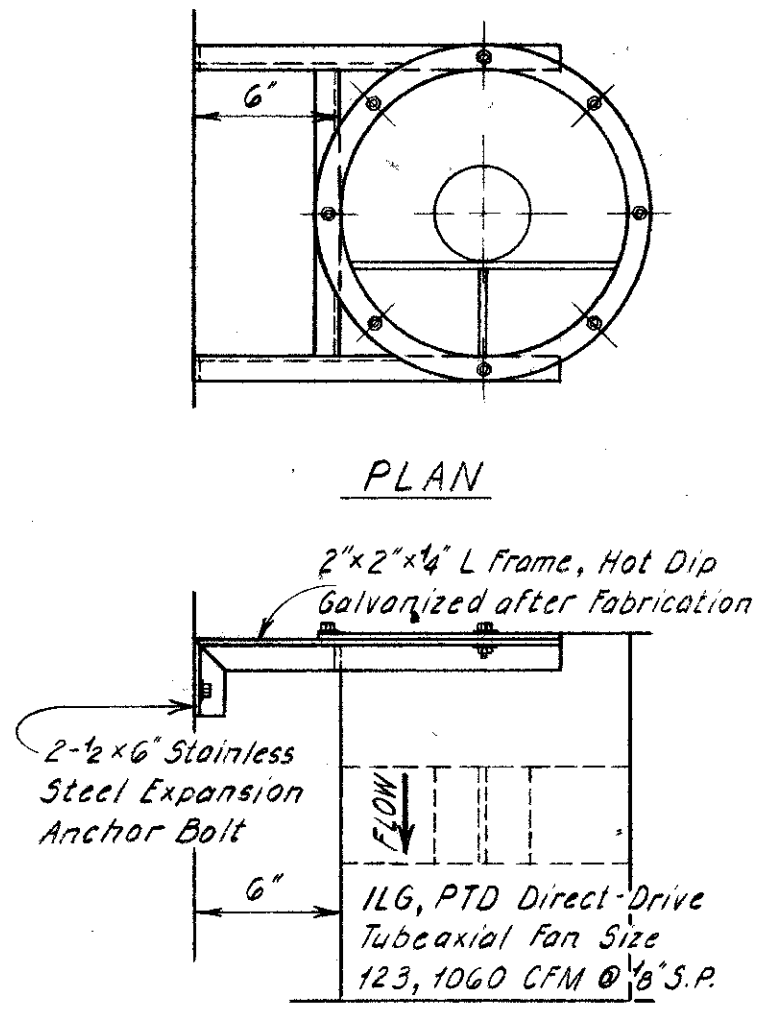

FAN INSTALLATION
1/2"=1'-0"

DATE	REVISION	BY

PUMP ROOM MECHANICAL FLOOR PLAN AND WEST WALL ELEVATION		
PUMPS 1A & 2A		
BELTWOOD PUMP STATION		
DALLAS WATER UTILITIES		
CITY OF DALLAS, TEXAS		

DESIGN	EHH	CONTRACT NO.	81-7	SHEET NO.	13
DRAWN	RME	FILE NO.	640Q-700 B	OF	20
CHECKED					
DATE	Dec. 1980				

