
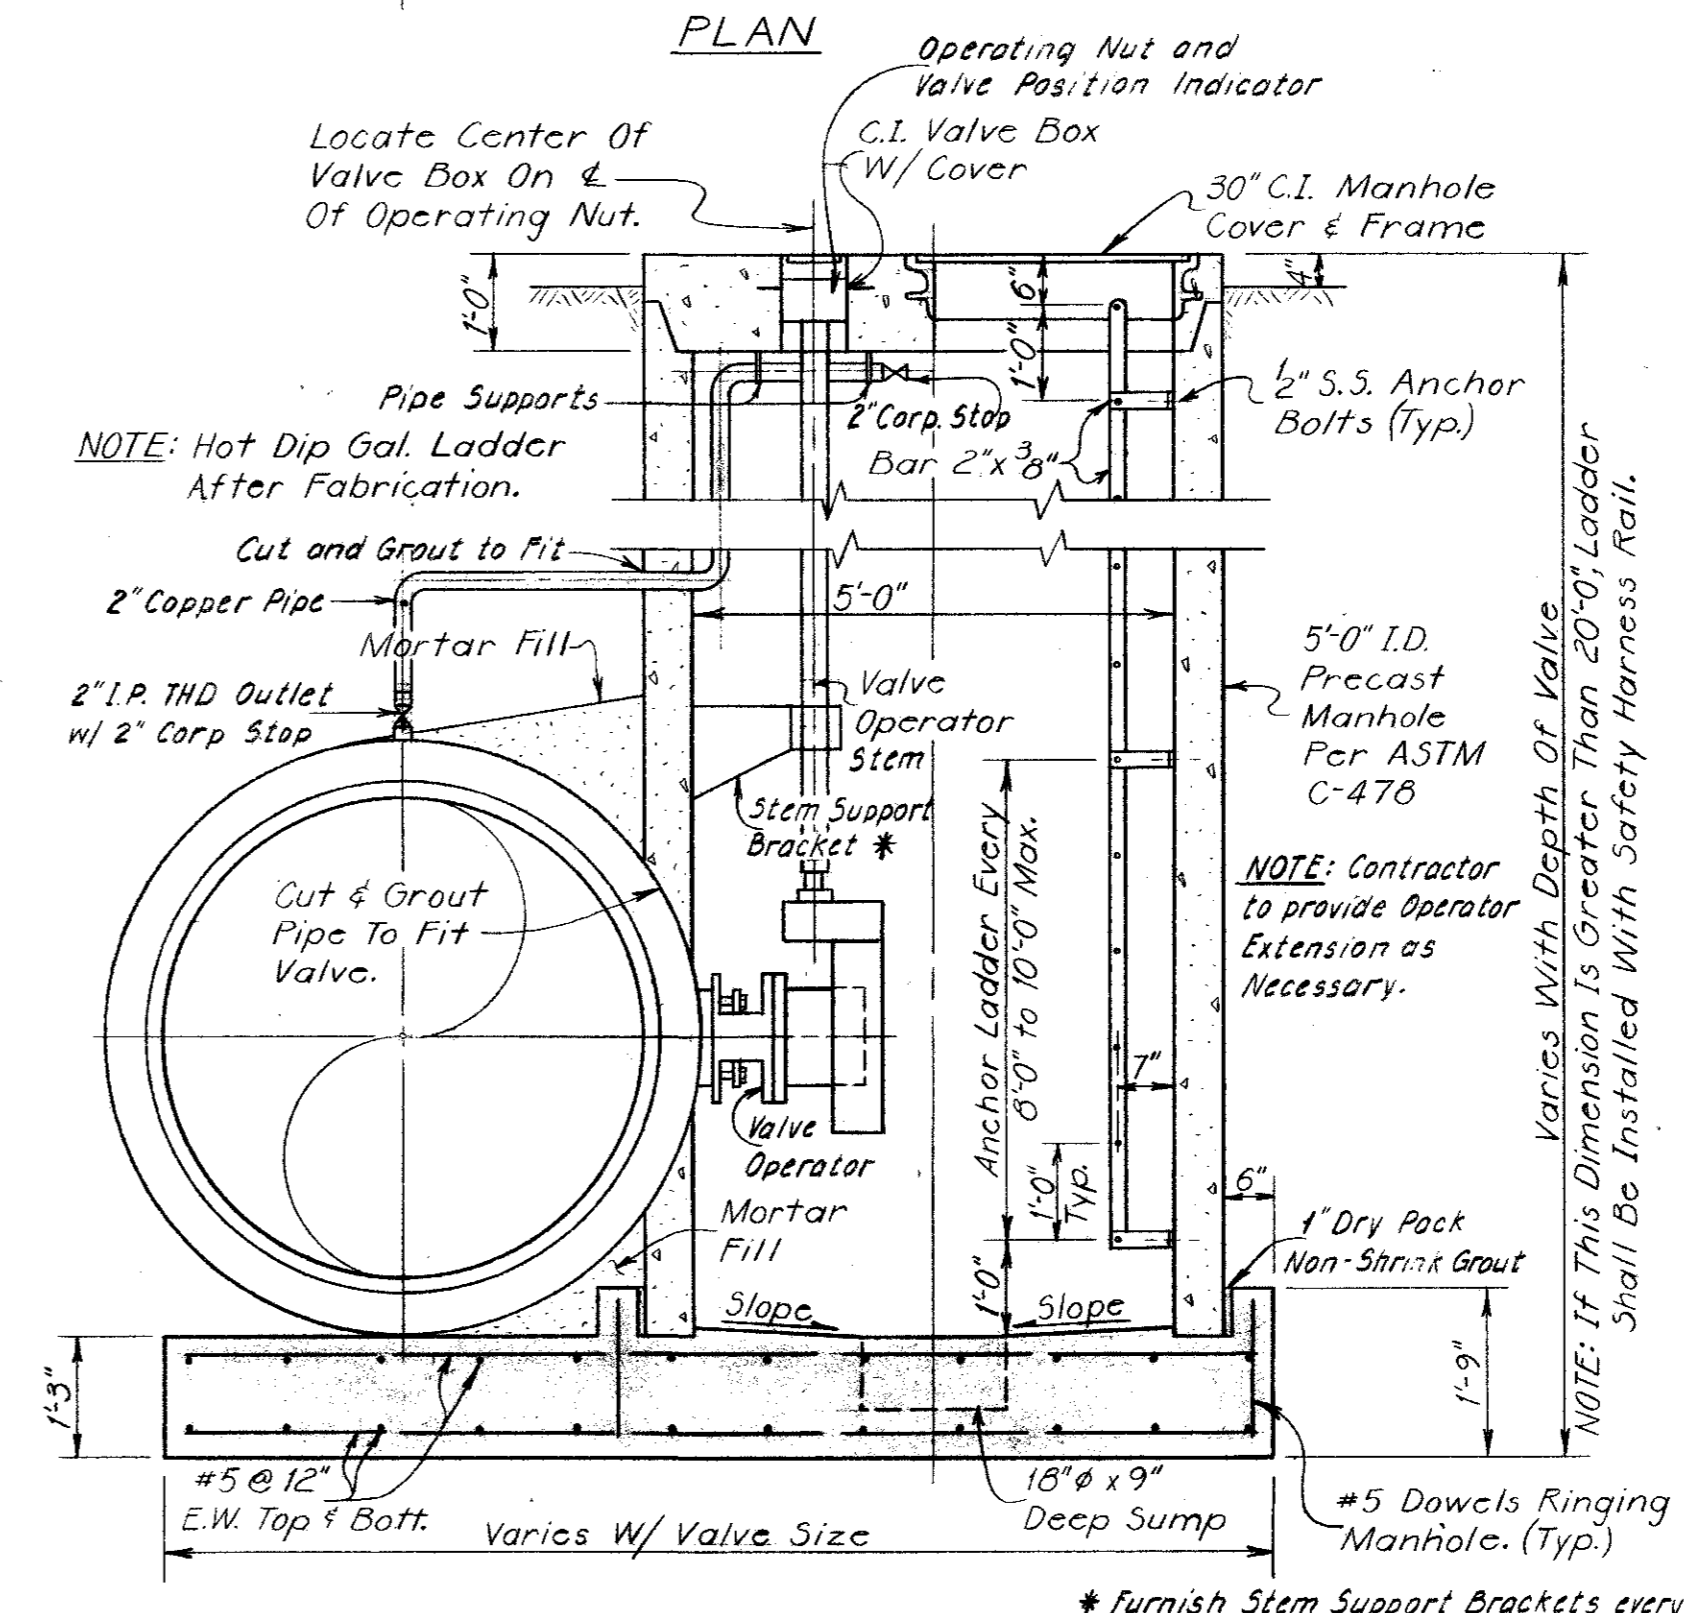


YARD PIPING PLAN
1"=20'

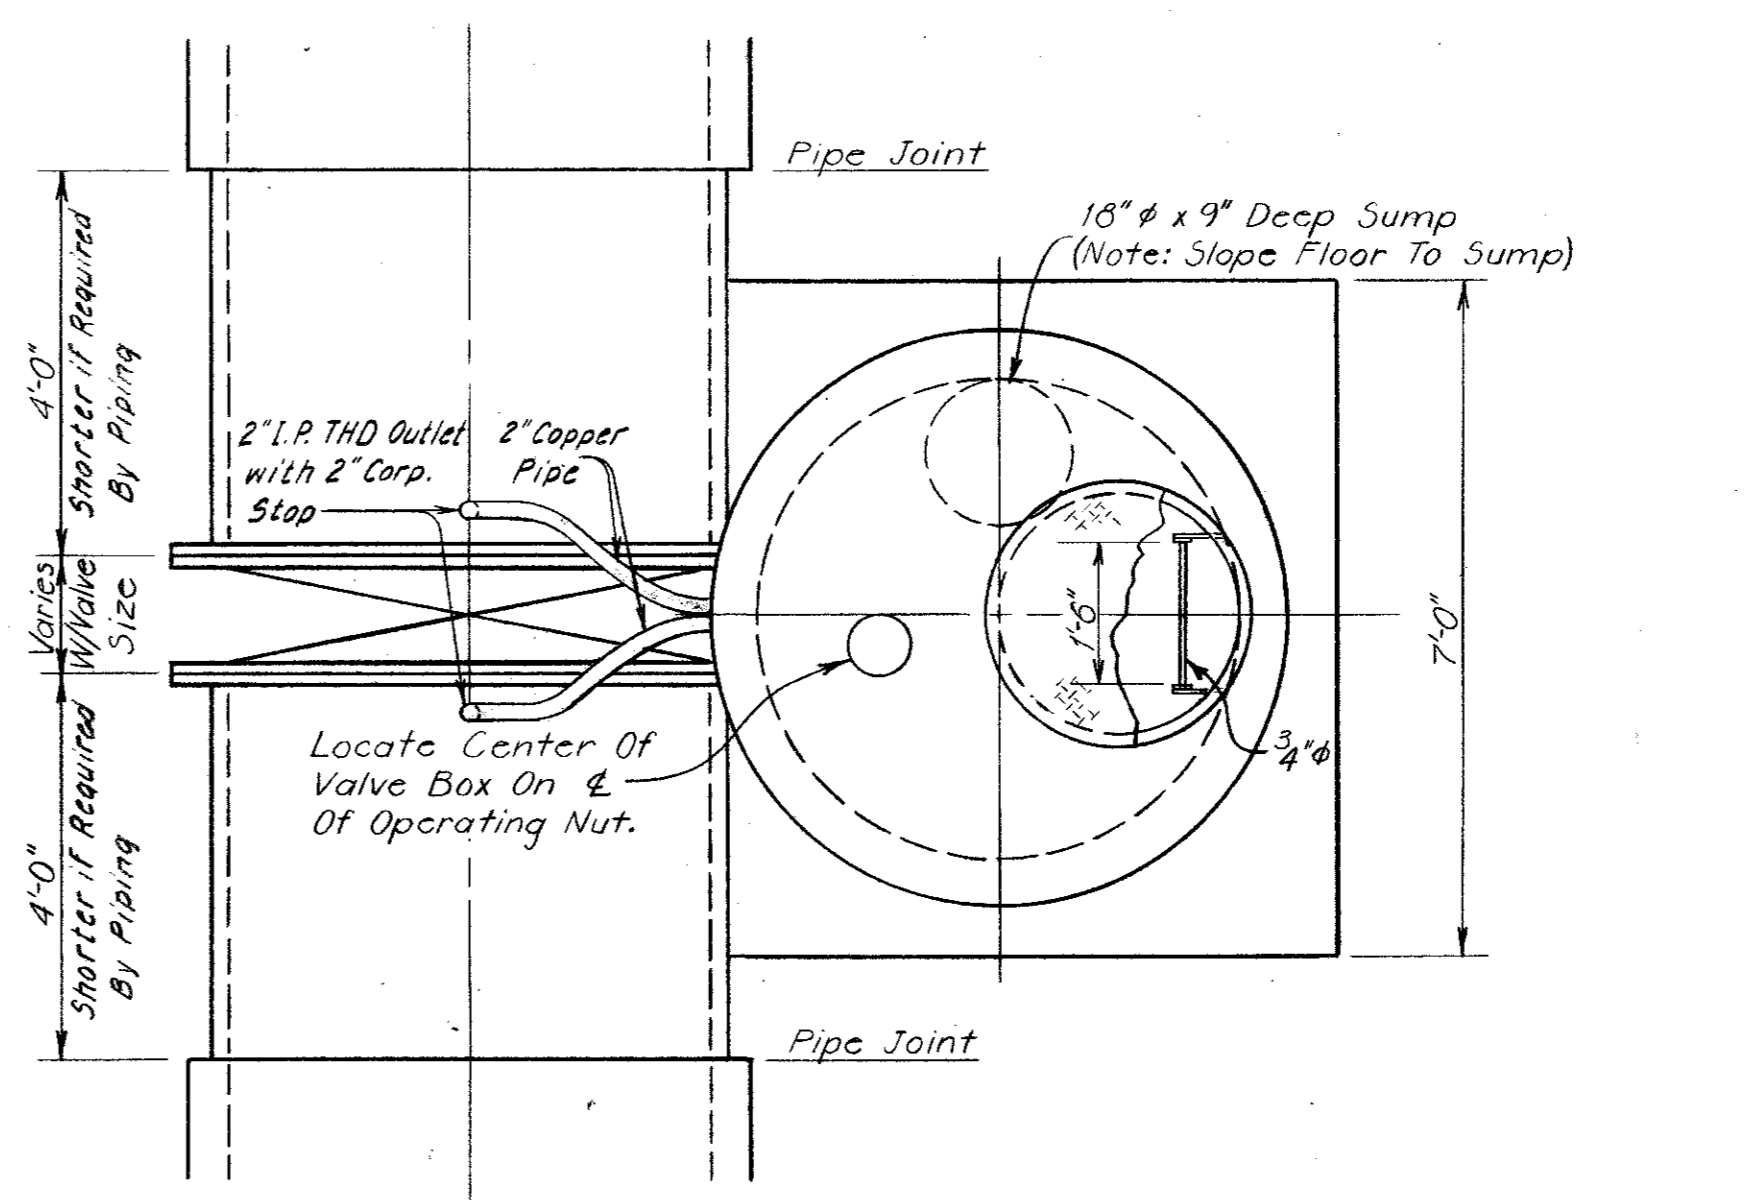

TYPICAL BUTTERFLY VALVE INSTALLATION
1/2"=1'-0"

- NOTE:**
1. Contractor to Verify location of all Yard Piping.
 2. Block all Fittings per Standard Appurtenance 414D-15.
 3. Use 48" Dish Head Plug Salvaged from Station 0+79 on 42" Bypass Line (Line A').

DATE	REVISION	BY
YARD PIPING PLAN AND DETAILS		
PUMPS 1A & 2A BELTWOOD PUMP STATION		
DALLAS WATER UTILITIES		
CITY OF DALLAS, TEXAS		
DESIGN	CONTRACT NO.	SHEET NO.
DRAWN	81-7	3
TRACED	FILE NO.	
CHECKED	640Q-700B	20
DATE	Jan. 1981	

