



1 ROOF PLAN  
SCALE 1/8"=1'-0"

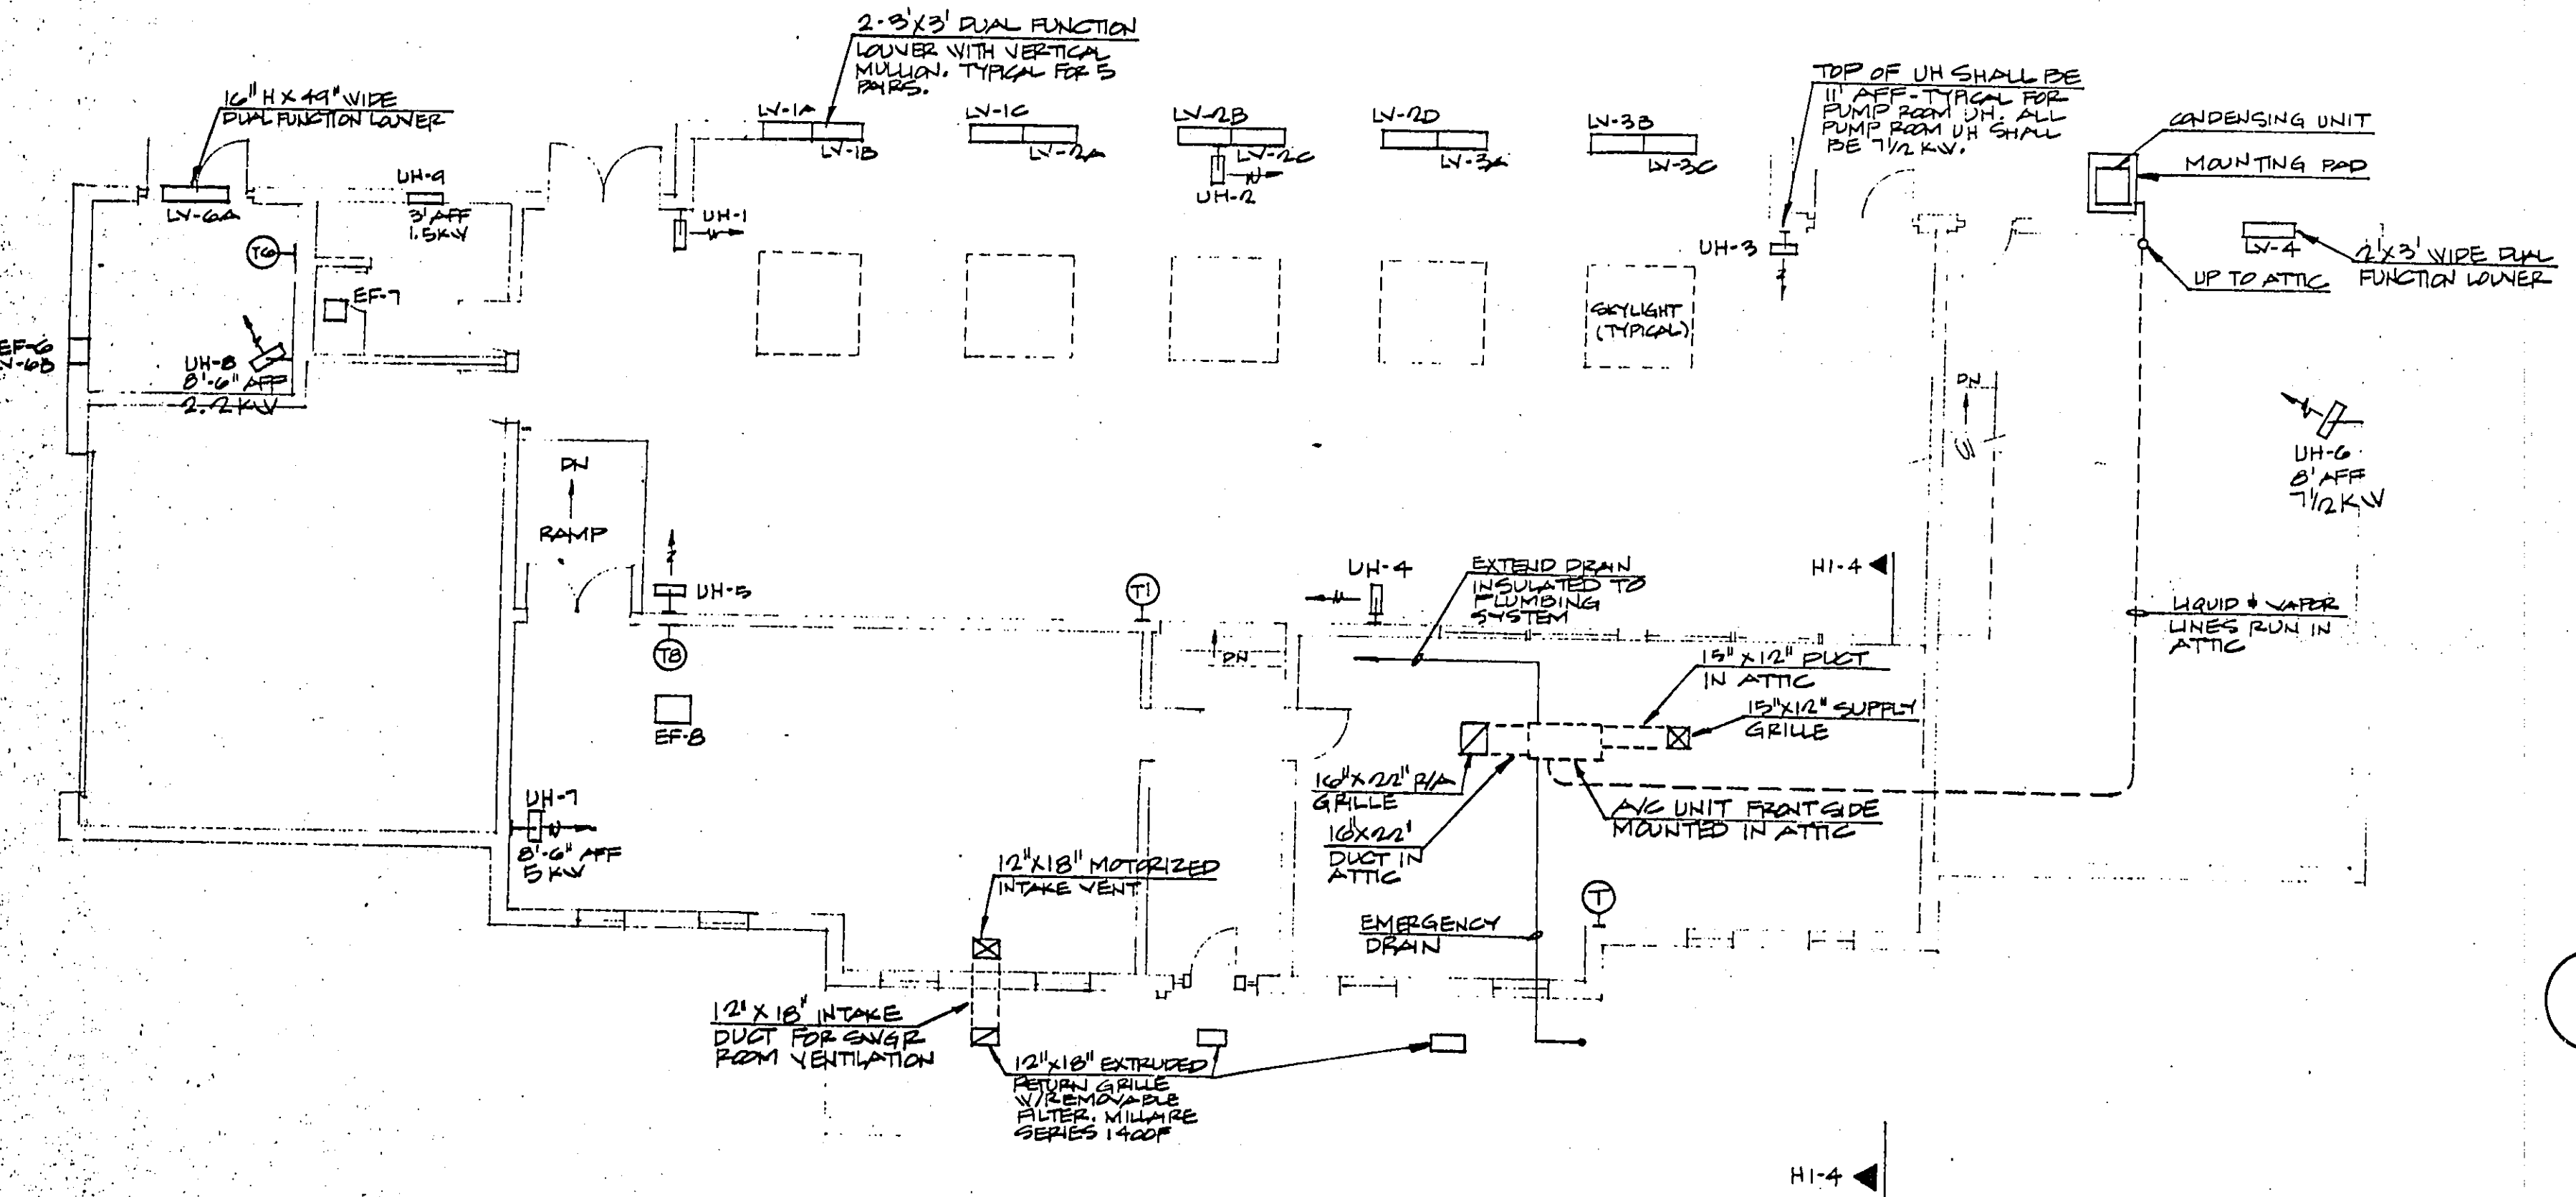


2 HVAC PLAN  
SCALE 1/8"=1'-0"

3 ATTIC PLAN  
SCALE 1/8"=1'-0"

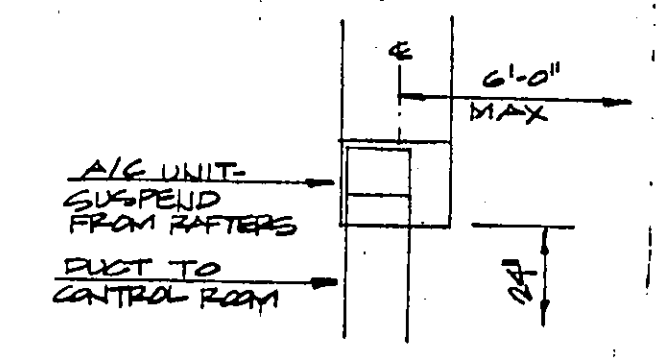

4 SECTION  
NO SCALE

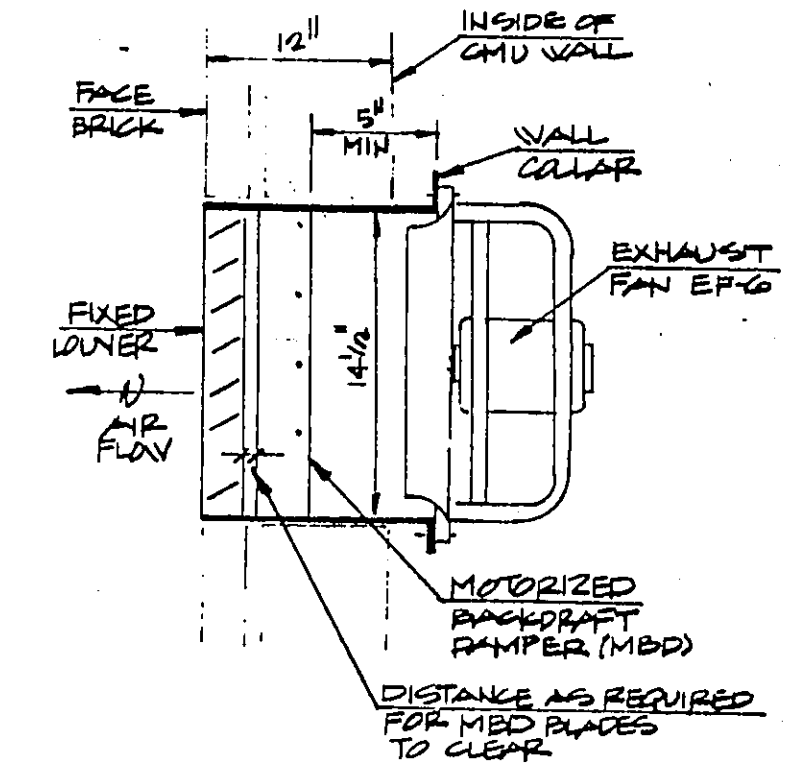

NOTE: VERIFY WALL OPENING W/MFR BEFORE CONSTRUCTION

5 DETAIL  
NO SCALE

No.	Revision	By	Date
TOWN OF ADDISON DALLAS COUNTY, TEXAS <b>CELESTIAL ROAD PUMP STATION</b>			
CHARLES R. MCCREARY & ASSOCIATES		CONSULTING ENGINEERS STATE #17 2501 LAURELWAY DALLAS, TEXAS 75240	MECHANICAL HVAC
<b>GINN, INC.</b> Consulting Engineers Dallas, Texas			
Designed - JK	Drawn - JW	Date -	Job No. -
Approved -	Checked -	Scale -	



2-18-87