



BASE OF WALLS


JOINTS WITHOUT WATER STOPS

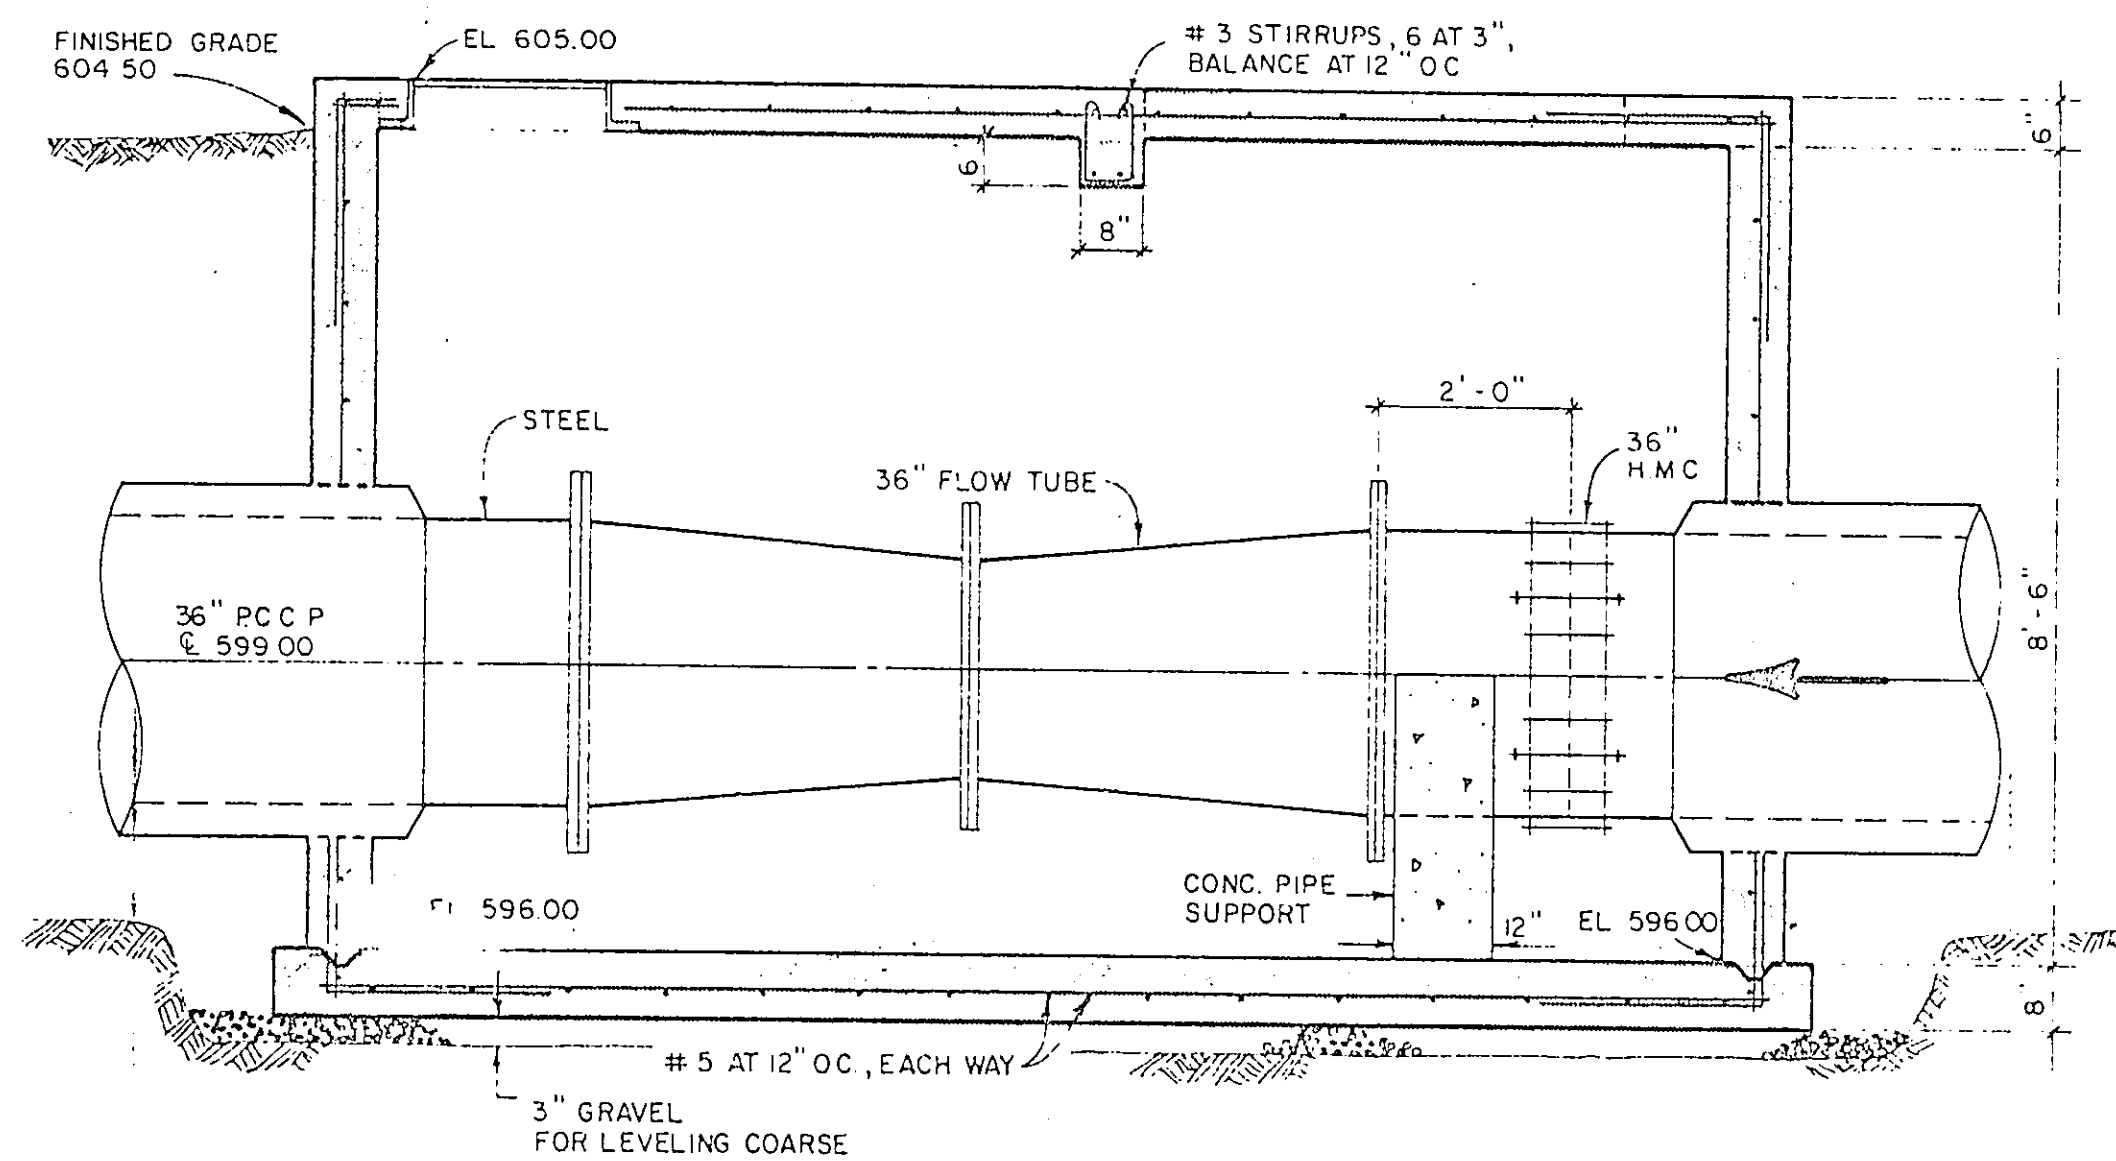


SECTION 1  
SCALE - 1/2" = 1'-0"

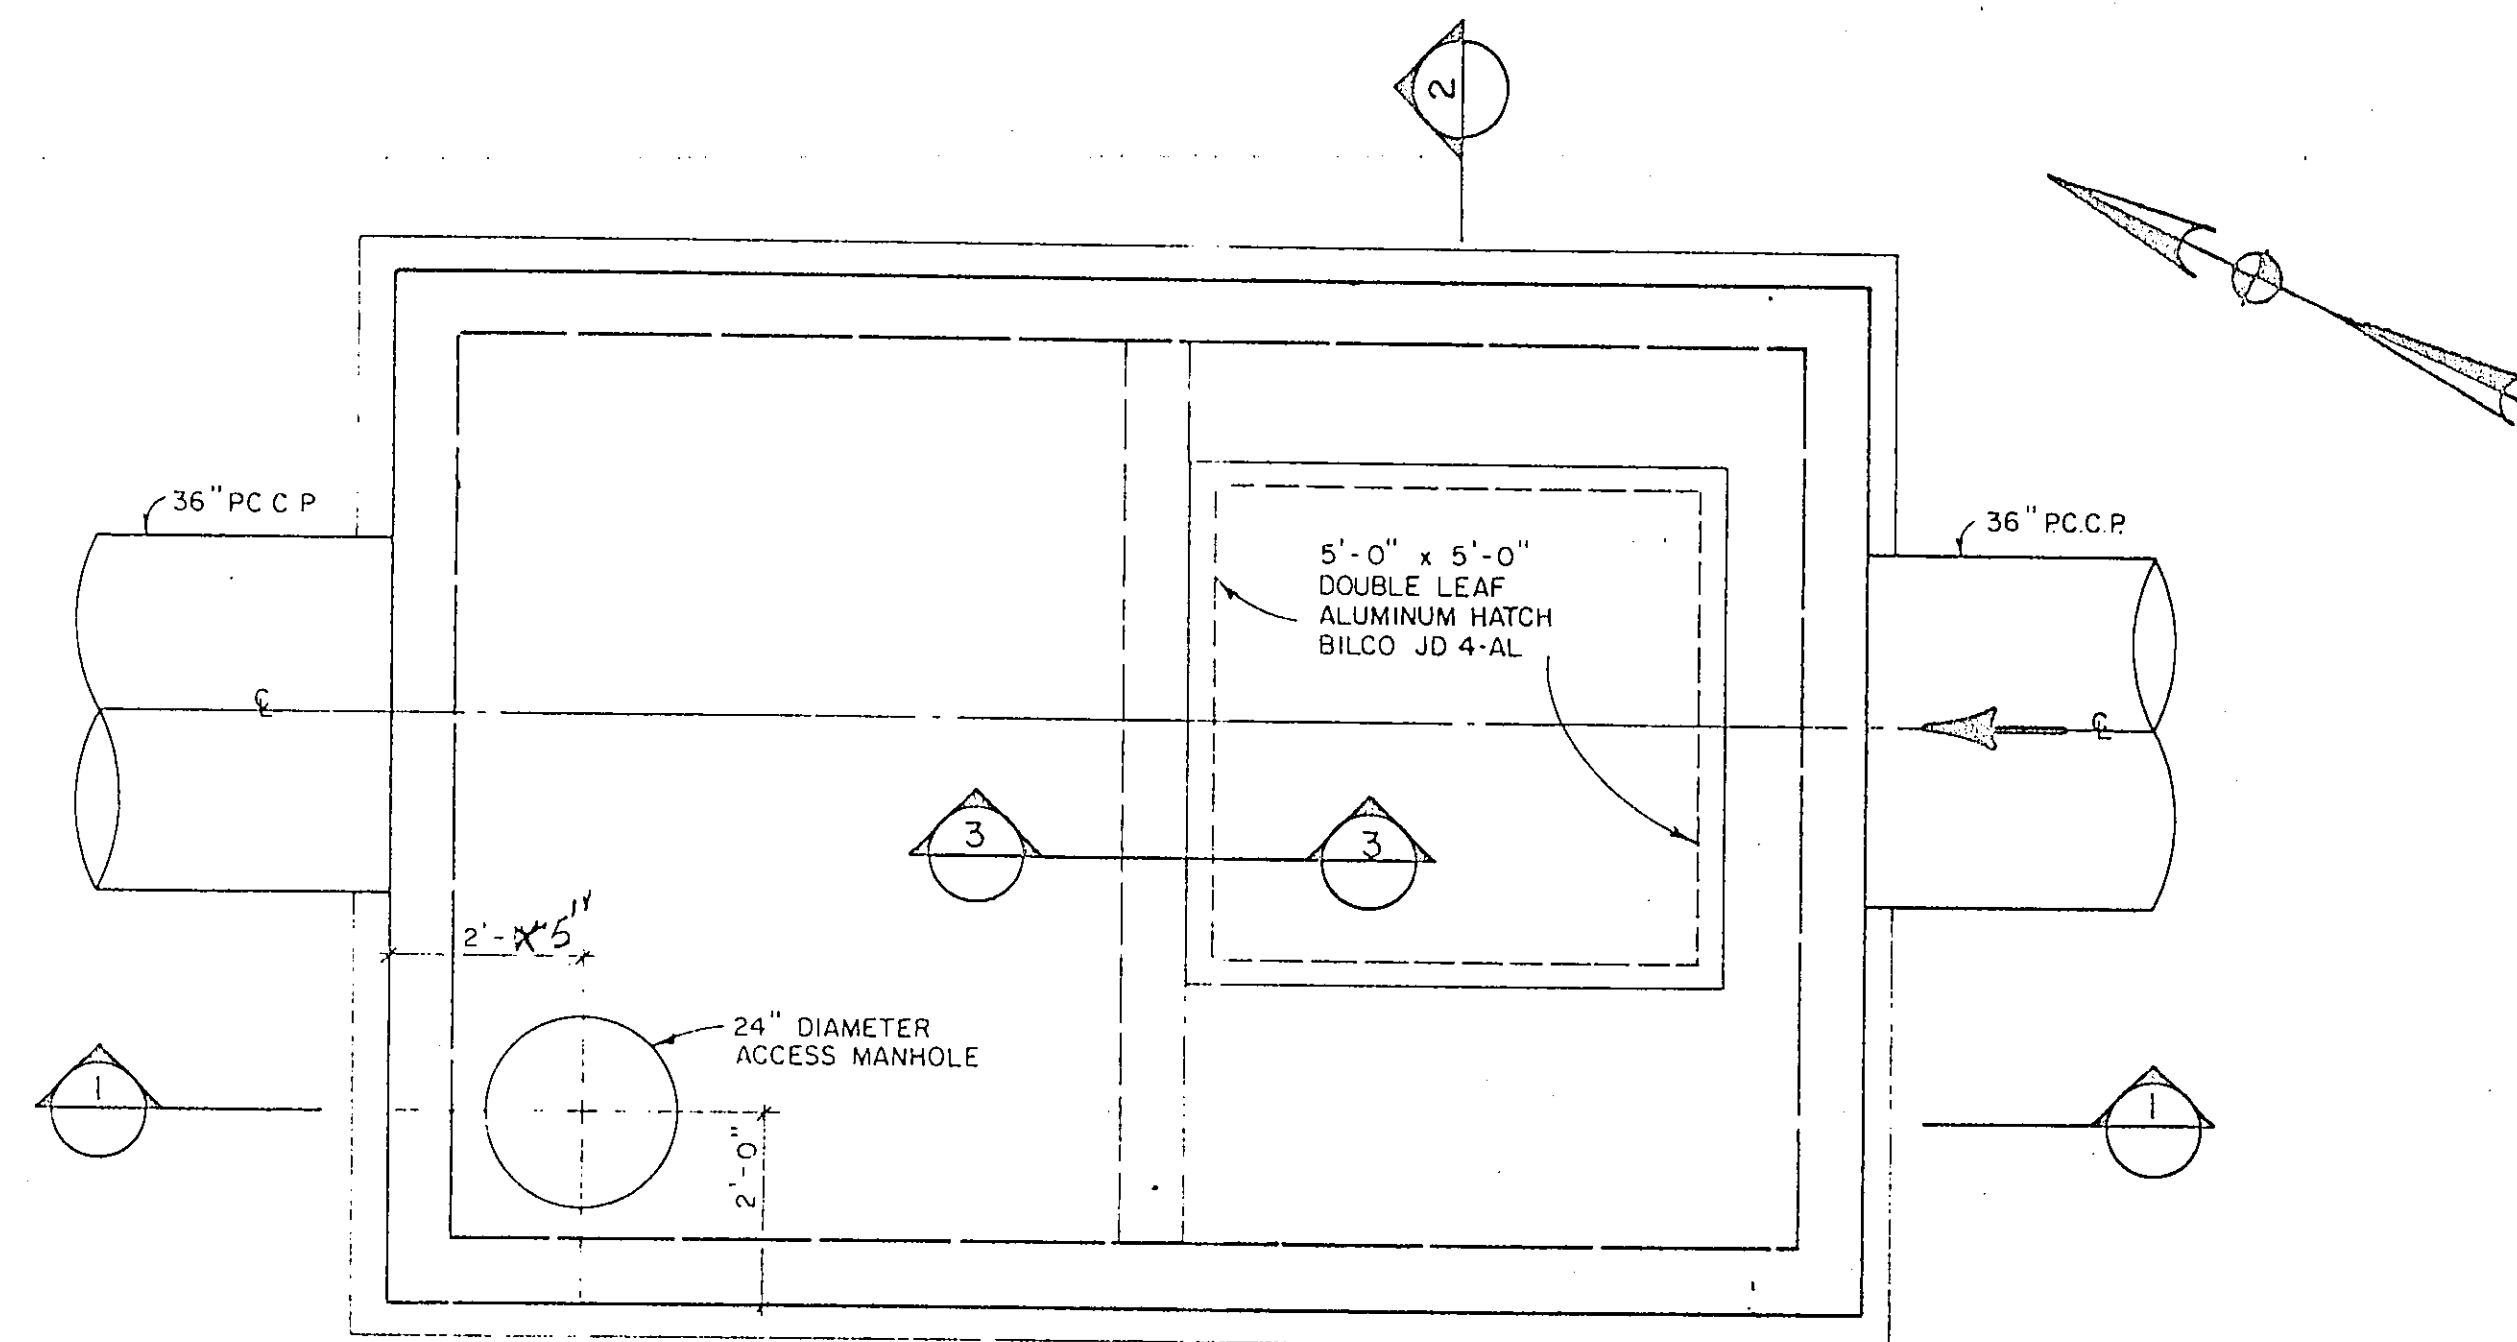


ROOF PLAN  
SCALE - 1/2" = 1'-0"

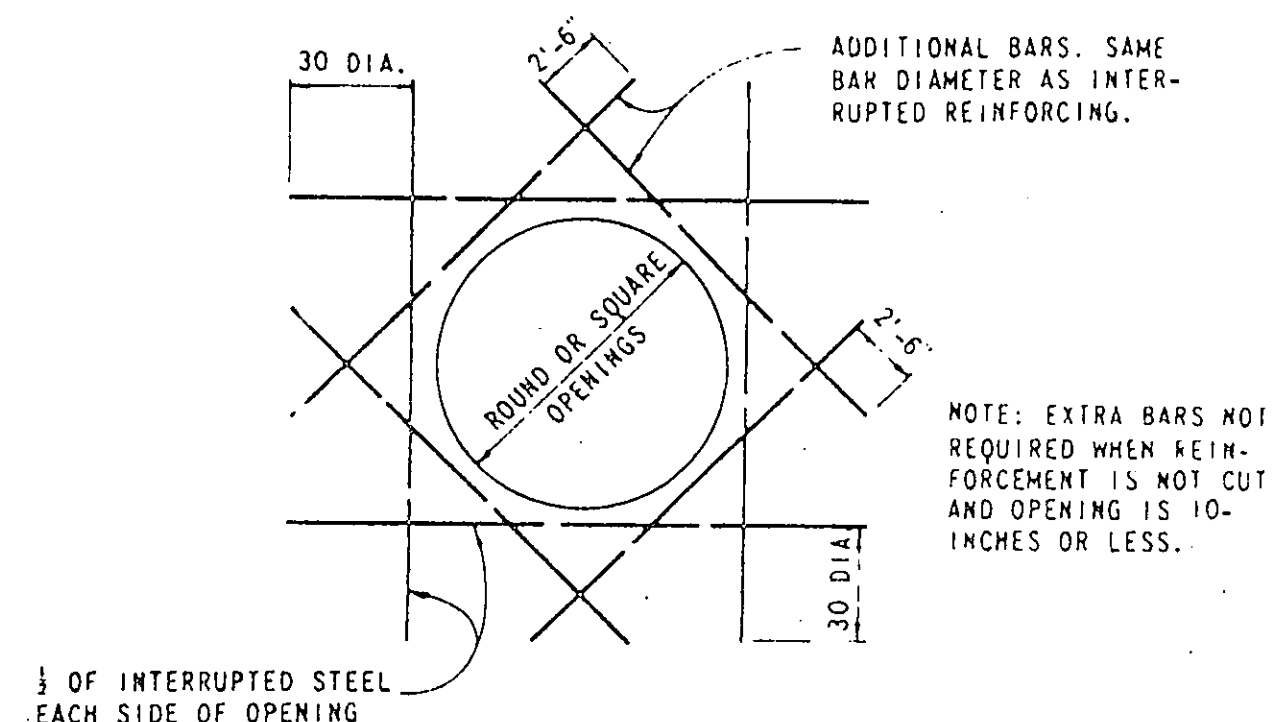


REINFORCING AT OPENINGS

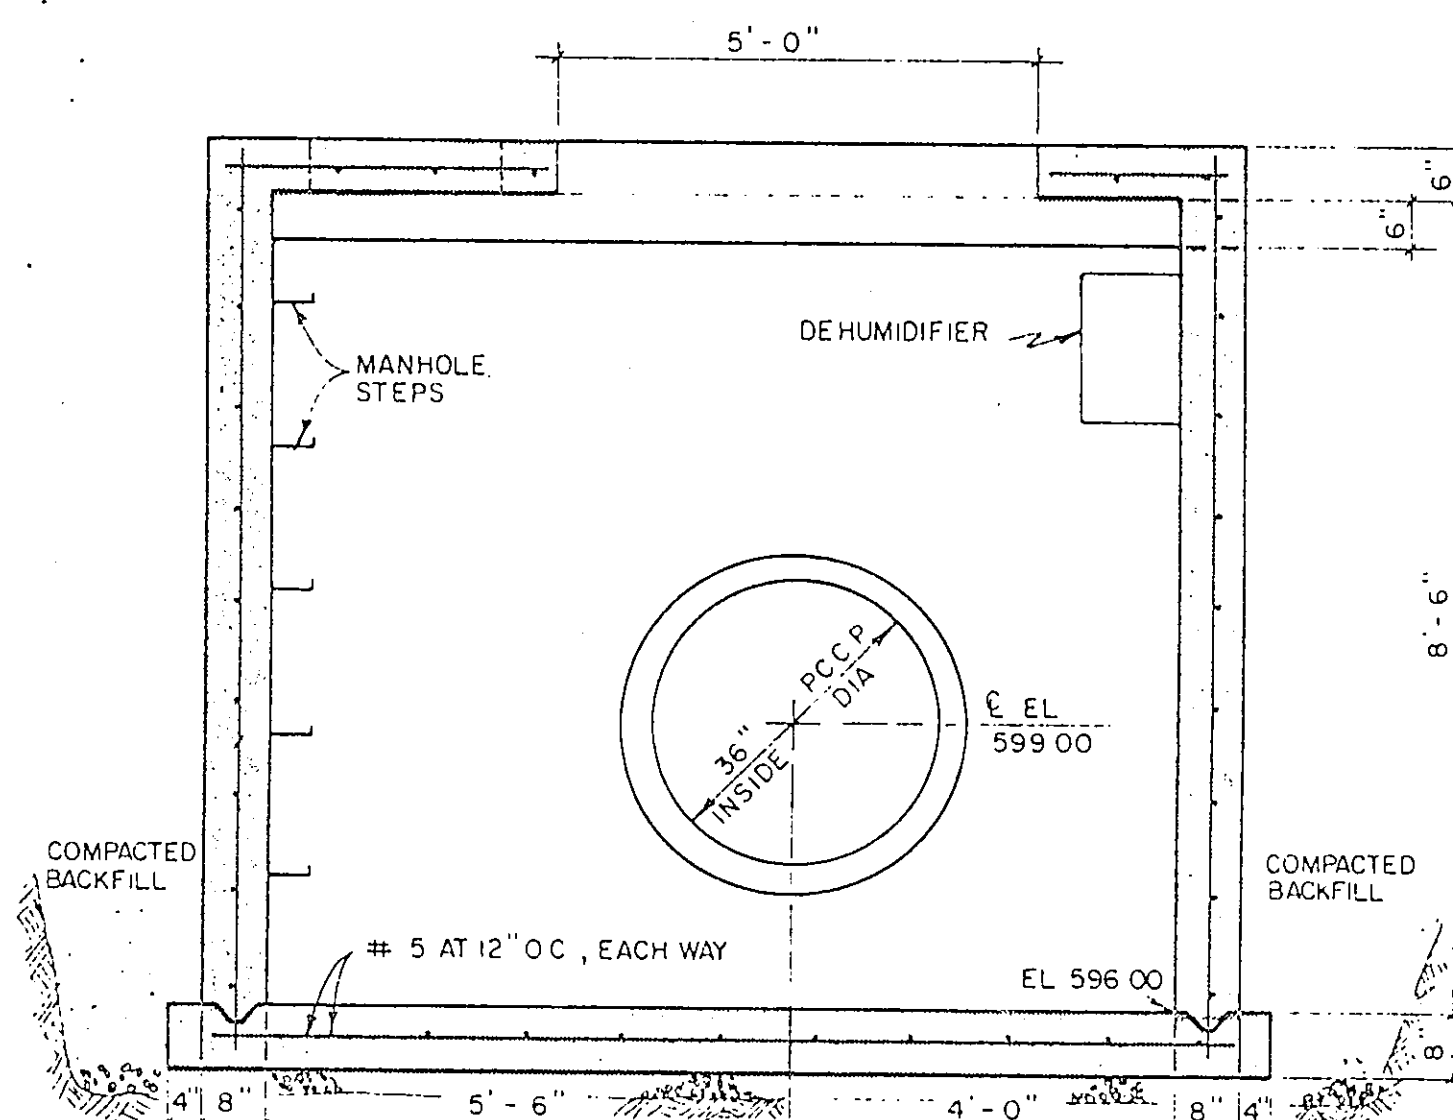

SECTION 2  
SCALE - 1/2" = 1'-0"

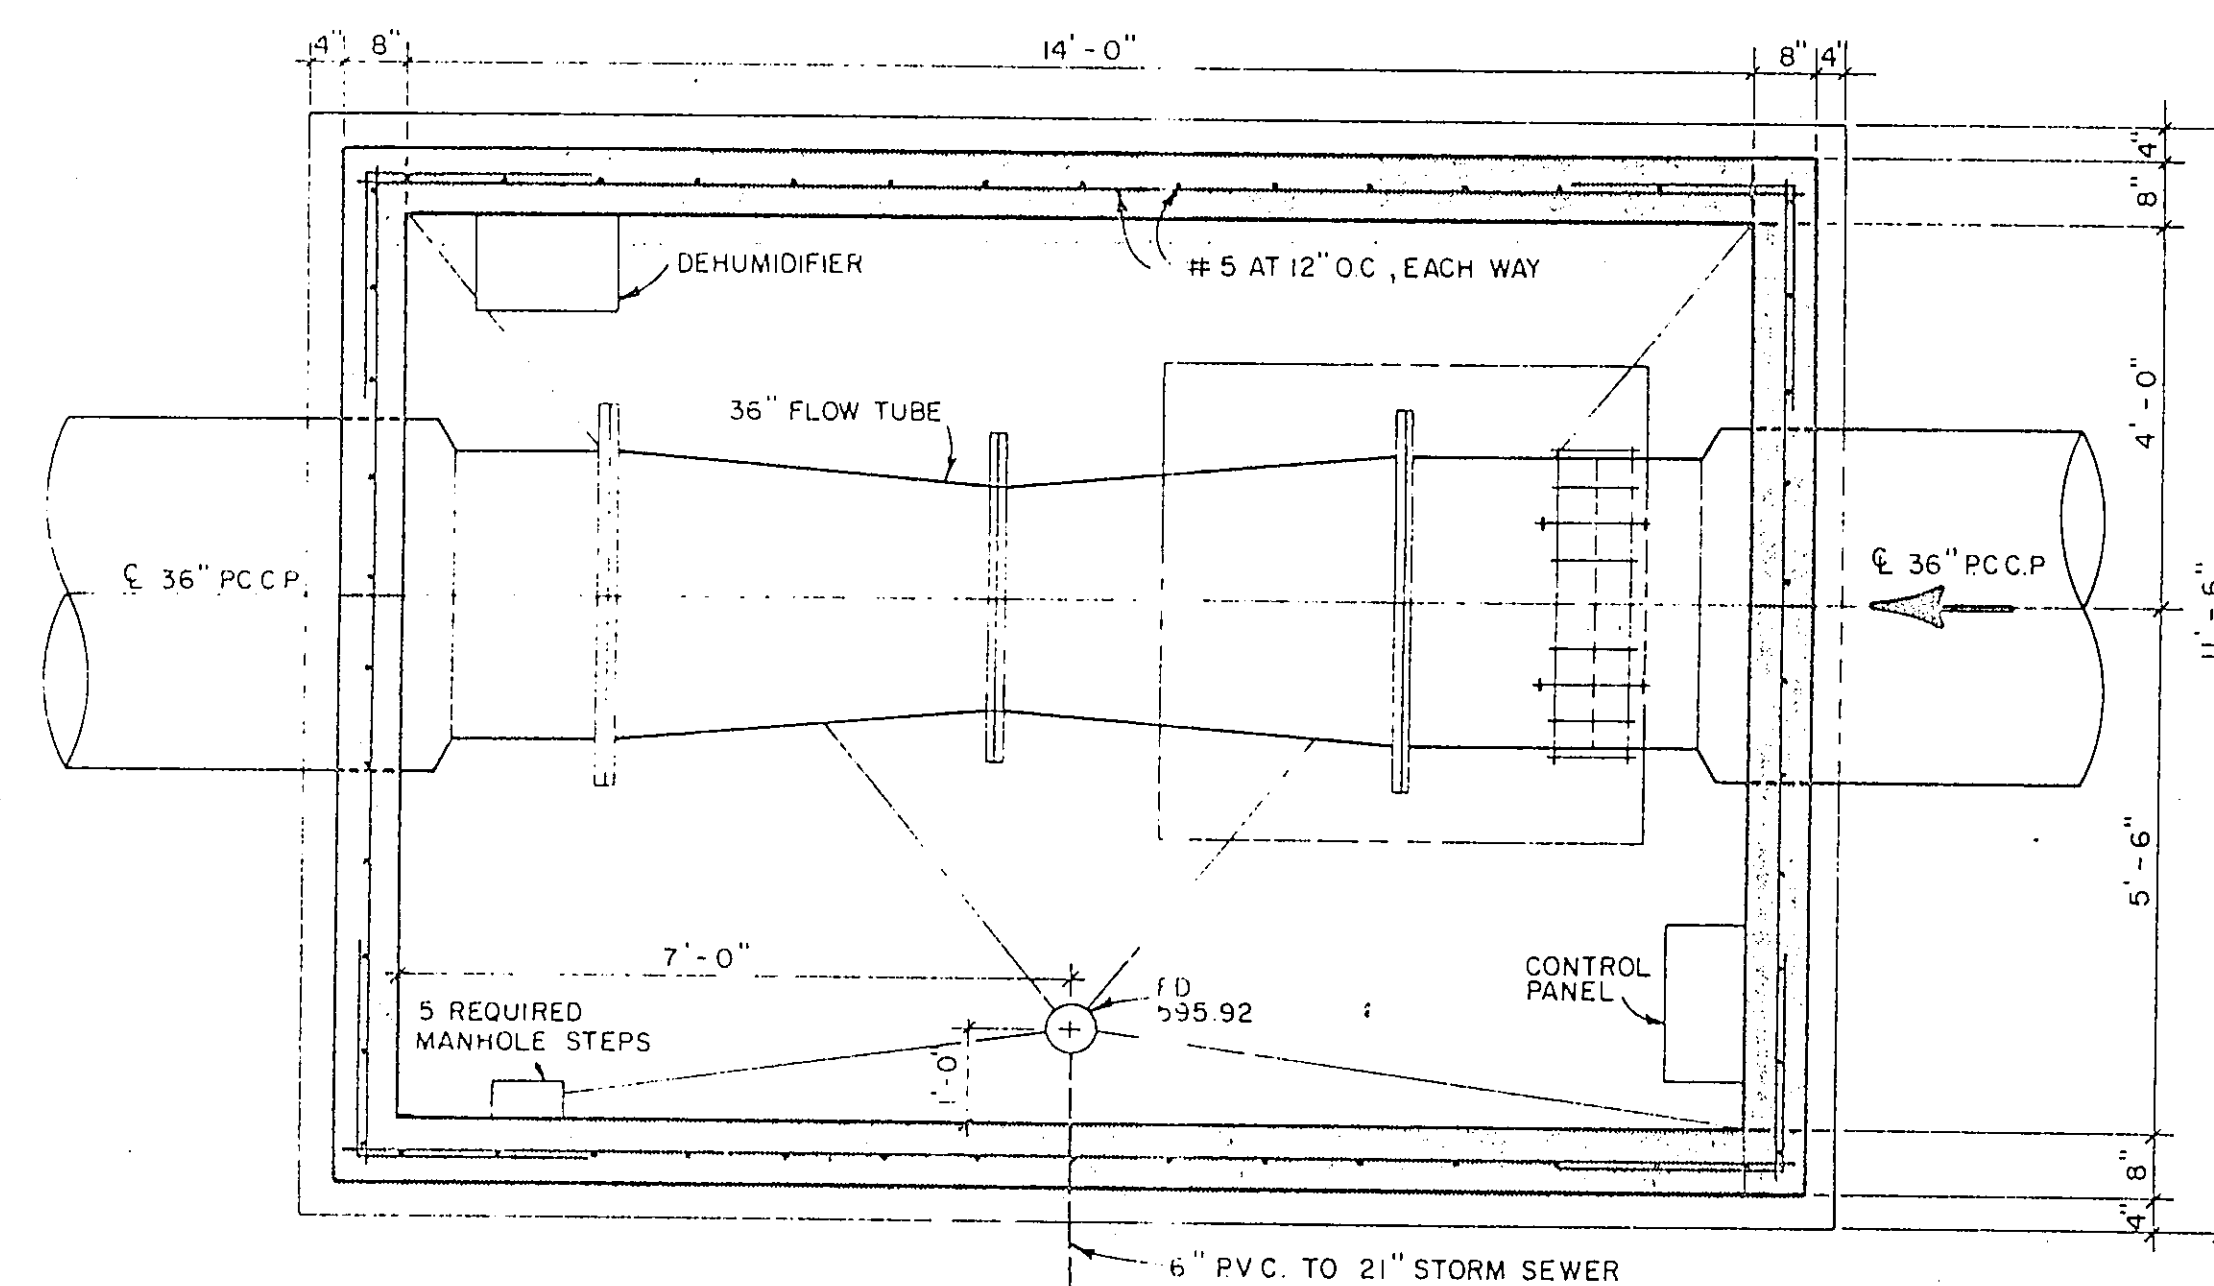


SECTIONAL PLAN  
SCALE - 1/2" = 1'-0"

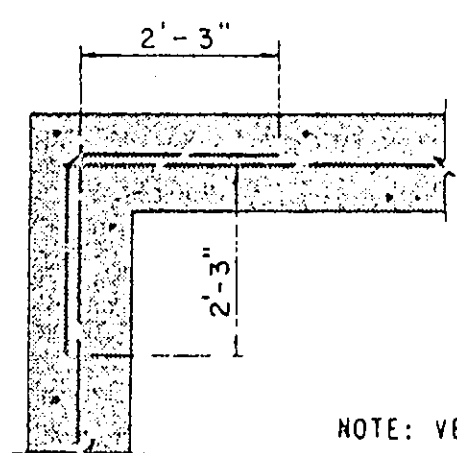

NOTE: VERTICAL REINFORCING NOT SHOWN.

TYPICAL CORNER REINFORCING DETAILS  
(PLAN VIEW)

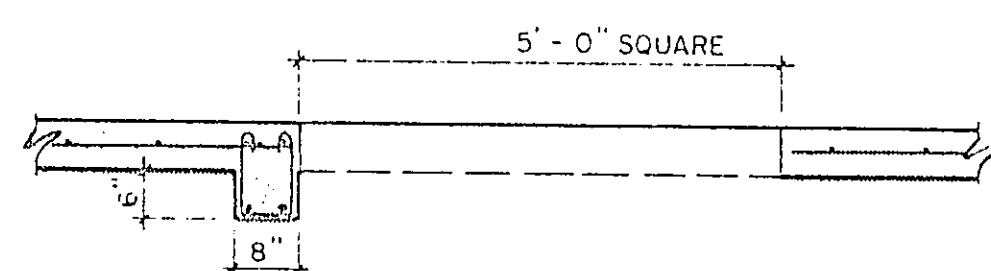

SECTION 3  
SCALE - 1/2" = 1'-0"

No.	Revision	By	Date
TOWN OF ADDISON DALLAS COUNTY, TEXAS			
<b>CELESTIAL ROAD PUMP STATION</b>			
<b>FLOW METER VAULT &amp; DETAILS</b>			
<b>GINN, INC.</b> Consulting Engineers, Dallas, Texas			
Designed - R.C.H.	Drawn - B.S.	Date - JAN., 1987	Job No - 217
Approved - HWG	Checked - G.A.F.	Scale - AS SHOWN	Sheet C7

Randall C. Hill  
2-19-87