

B8-2

Celestial Pumps + Generator 3/98

TOWN OF ADDISON, TEXAS

CONSTRUCTION PLANS FOR

CELESTIAL ROAD PUMP STATION ADDITIONS PUMPS 2 AND 4 & EMERGENCY GENERATORS


SHEET INDEX

SHEET NO.	SHEET DESCRIPTION
-	GENERAL COVER SHEET AND LOCATION MAP
-	CIVIL PUMP ROOM PIPING PLAN
1A	PIPING SECTION A-A
2A	PIPING SECTION B-B
3A	PAVING IMPROVEMENTS
4A	ELECTRICAL --DELETED--
5A	ELECTRICAL SITE PLAN
6A	ONE LINE DIAGRAM
7A	CONTROL SCHEMATICS I
8A	CONTROL SCHEMATICS II
9A	CONTROL SCHEMATICS III
10A	CONTROL SCHEMATICS IV
11A	PUMP STATION PLAN
12A	SECTION AND DETAILS
13A	ELECTRICAL DETAILS
14A	GENERATOR BUILDING
15A	GENERATOR BUILDING
A1	ARCHITECTURAL GENERATOR BUILDING
A2	GENERATOR BUILDING
S1	STRUCTURAL GENERATOR BUILDING
S2	GENERATOR BUILDING

THESE PLANS REFLECT ALL
CHANGE ORDERS AND ADDENDA
ISSUED TO THE DATE 12 FEB. 1998

▲ ADDENDUM NO. 1
● ADDENDUM NO. 2

CONSTRUCTION SET
ISSUED BY
TOWN OF ADDISON
PUBLIC WORKS DEPARTMENT
NAME: *Jeff Hankins* DATE: 3-23-98

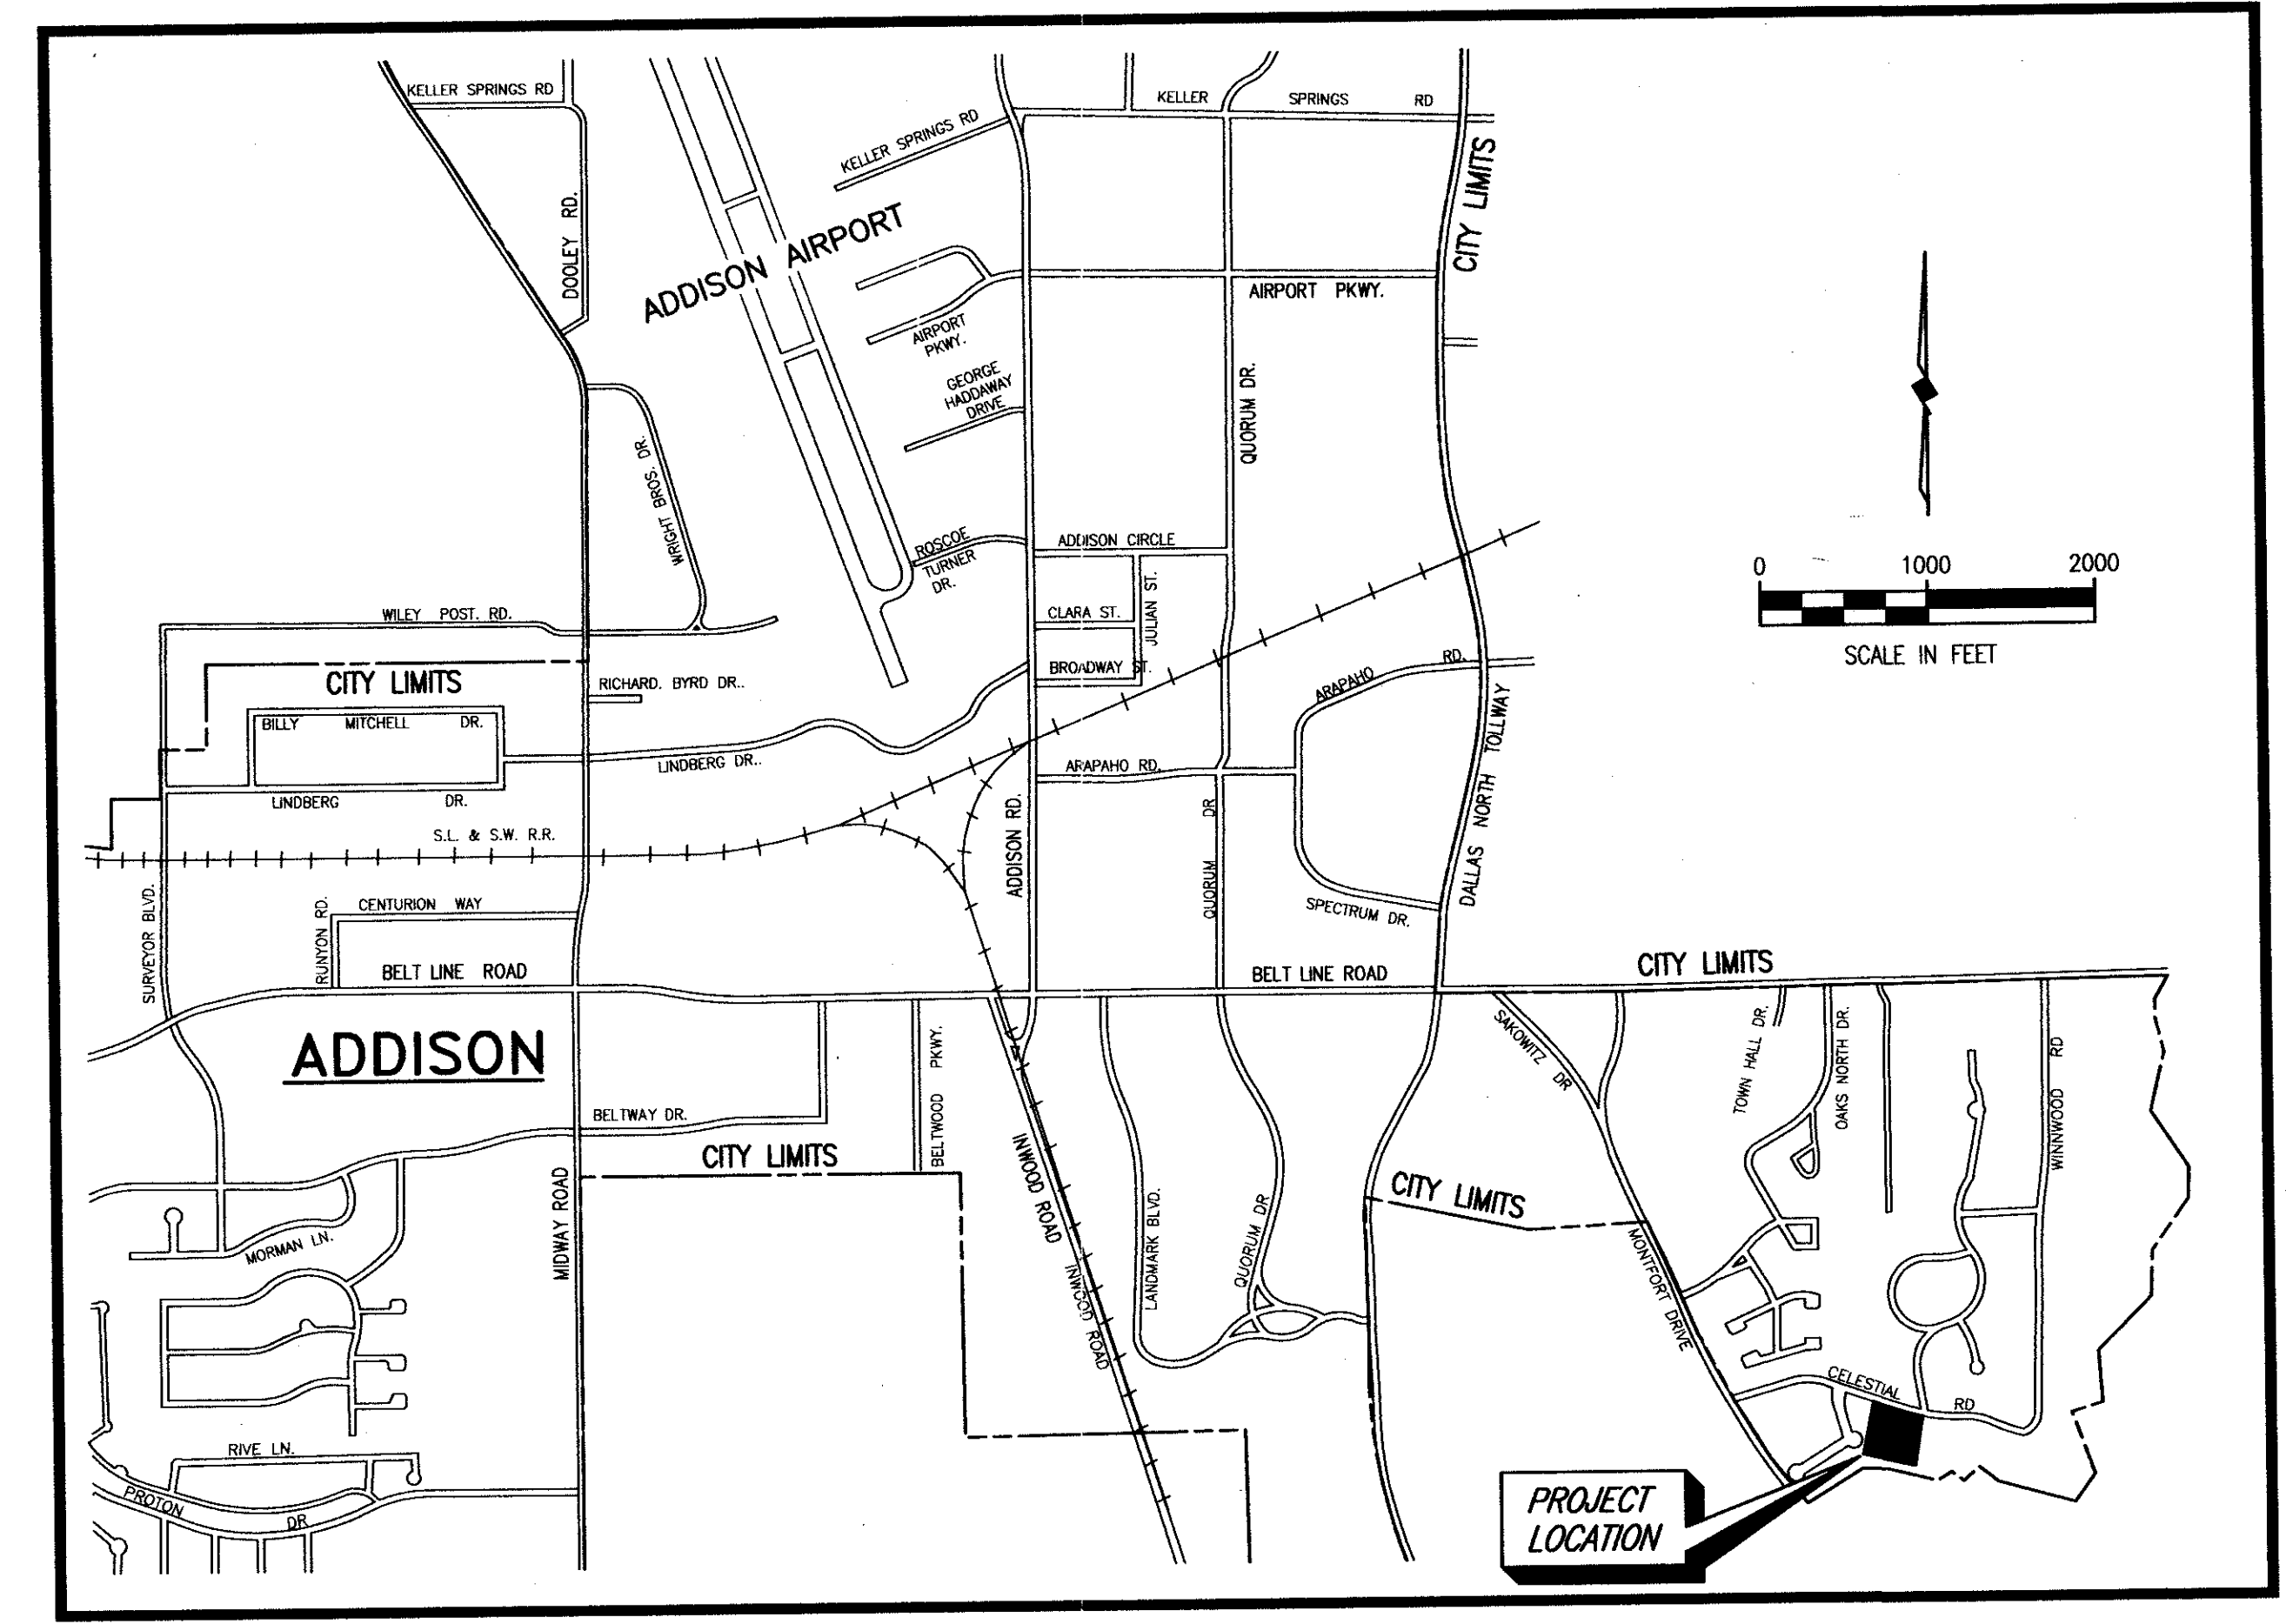


LOCATION MAP

PREPARED BY
SHIMEK, JACOBS & FINKLEA, L.L.P.
CONSULTING ENGINEERS
Dallas, Texas

JANUARY 1998

THESE DOCUMENTS ARE FOR
BIDDING, CONSTRUCTION,
AND PERMIT PURPOSES.
John W. Birkhoff
DATE: 2/11/98

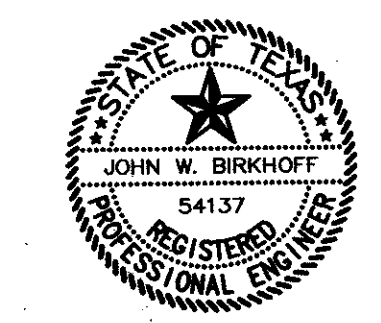

These plans and related specifications were prepared for construction of this specific project only. Reuse of these documents is not permitted without written authorization of Shimek, Jacobs & Finklea, L.L.P.

REVISED 02/12/98 GAO 97180-00.DWG SCALE: 1"=1' BLOCKS: LOCATION, INDEX

B8-2