



**ELECTRICAL RISER**

NO SCALE

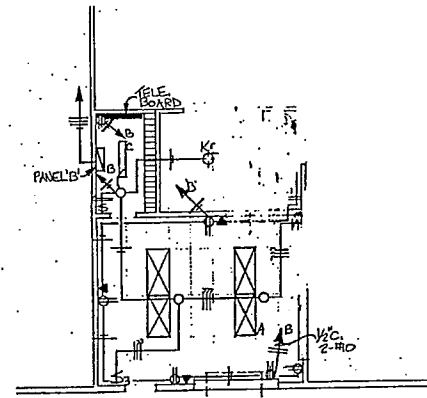

**HANGER OFFICE DETAIL**

SCALE: 1/8"=1'-0"

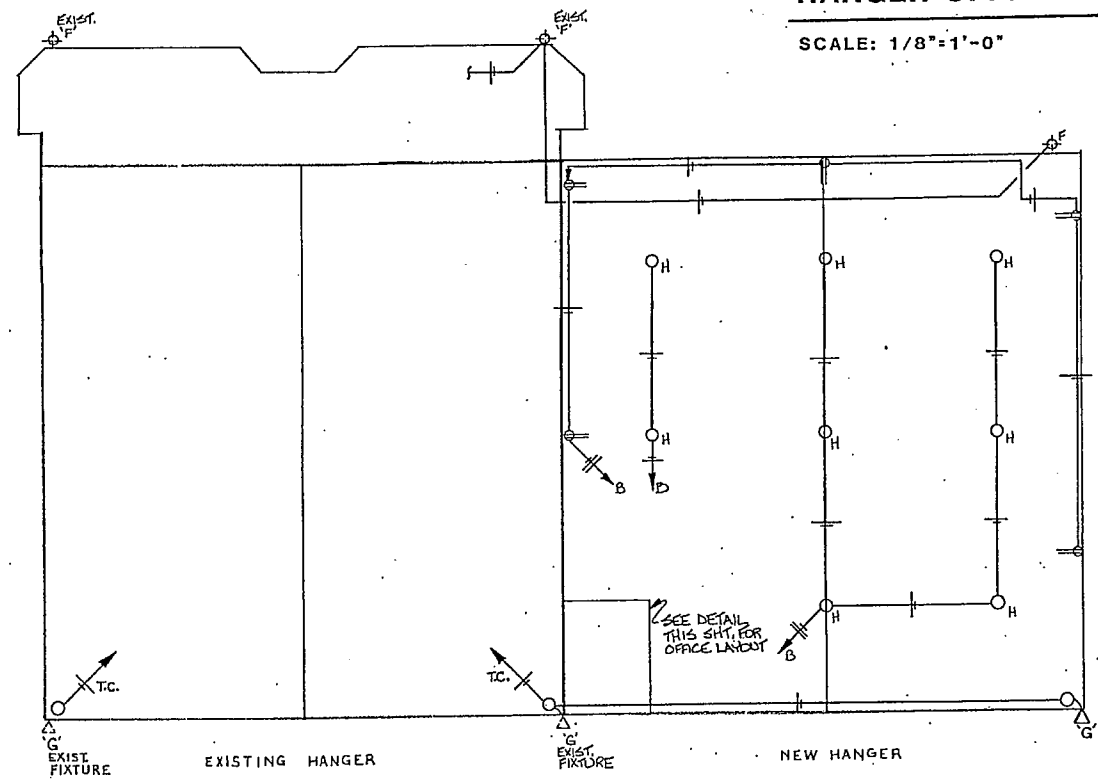

**PLAN VIEW - ELECTRICAL LAYOUT**

SCALE: 1"=20'-0"

NOTE: ALL HANGER RECEPTACLES MODIFIED 36" ABOVE FINISHED FLOOR.

**FIXTURE SCHEDULE**

- ⊠ 2x4 LAY-IN 120V
- ⊞ 150W, KEYLESS
- ⊞ 4' Z-LAMP OPEN STRIP
- ⊞ INCANDESCENT BATH BRACKET LIGHT
- H HI-BAY FIXTURE 111EC# 11400 ALS-120
- ⊞ F 175W, METAL HALIDE 120V
- ⊞ G 400W, METAL HALIDE 120V

REVISIONS:


--	--

OTHER OFFICES IN  
HOUSTON  
BAYTOWN  
110 GRAND VALLEY



PROJECT: **MISSION AIRE FACILITY**

MECHANICAL & ELECTRICAL CONTRACTORS & ENGINEERS  
11120 INDIAN TRAIL DALLAS, TEXAS 75229  
A.C. (214) 920-3800

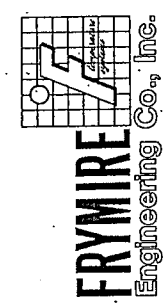

SCALE	1" = 20'-0"
DATE	6/3/83
DRAWN	D. B. / T.S.
CKD	

JOB NO.	
SHEET NO.	SEQUENCE
<b>E-1</b>	