


0 5 10 15 20 30 40 60  
SCALE (IN FEET)

Record (As-built) Certification  
 "Having checked this submission, we certify that it conforms to the requirements of the contract in all respects, except as otherwise indicated."  
 Contract Number: 97000136  
 Company Name: HALFF  
 Officer of Firm Signature: [Signature]  
 Title: [Signature]  
 Title of Officer (Typed): TOM KANDER, PRESIDENT  
 Seal of Professional Engineer of Construction Contractor, including signature and a clear, legible reading record (as built) drawing for accuracy of as-built construction reflected herein, must be placed below.

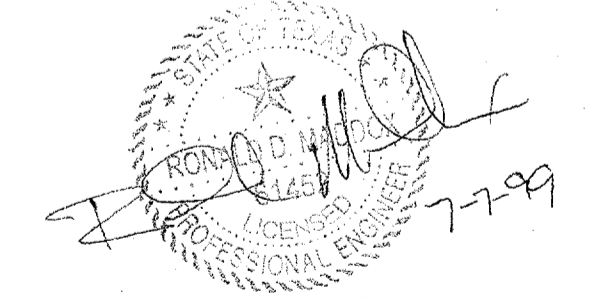

**CONFORMED**

**HALFF ASSOCIATES, INC.**  
 IRRIGATION CONSULTANTS

CONTRACT SHEET No. 46 OF 95


ADDISON TRANSIT CENTER IRRIGATION PLAN

CONTRACT C-97000136 DWG No. CC5-0014 REV 0

THE SEAL APPEARING ON THIS DOCUMENT WAS AUTHORIZED BY E. BRIAN BRISTOW, L.L. 4639 ON AUG. 13, 1997. ALTERATION OF A SEALED DOCUMENT WITHOUT PROPER NOTIFICATION TO THE RESPONSIBLE LICENSED IRRIGATOR IS AN OFFENSE UNDER THE TEXAS LICENSED IRRIGATORS ACT. THE RECORD COPY OF THIS DRAWING IS ON FILE AT THE OFFICES OF HALFF ASSOCIATES, INC., 8616 NORTHWEST PLAZA DRIVE, DALLAS TEXAS 75225


MATCH LINE SHT. DWG CC5-0012  
 MATCH LINE SHT. DWG CC5-0014

REV	DATE	DESCRIPTION	BY	ENG	CHK	APP	REV	DATE	DESCRIPTION	BY	ENG	CHK	APP

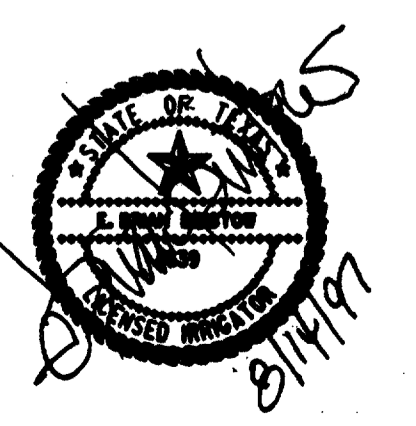

**SWA Group**  
 2211 North Lamar  
 Dallas, Texas 75202  
 214-954-0016  
 Landscape Architecture  
 Site Planning  
 Urban Design

**WLA**  
 WENDY LOPEZ & ASSOCIATES, INC.  
 ARCHITECTURE • SURVEYING • CONSTRUCTION SERVICES  
 300 MARKET CENTER BLVD - SUITE 20  
 DALLAS, TEXAS 75201  
 (214) 748-7777

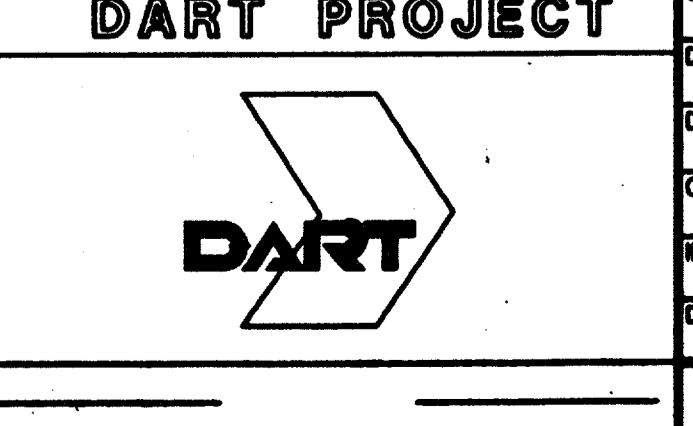

SCALE 1"=20'-0"  
 DRAWN L. HUGHES  
 DESIGNED B. BRISTOW  
 CHECKED B. BRISTOW  
 IN CHARGE V. STEVENS  
 DATE 14 AUGUST 97



FILED  
 FILE7  
 FILE8  
 FILE9  
 FILE10  
 PRF ROT  
 PENS  
 USERNAME  
 REV DATE DESCRIPTION BY ENG CHK APP REV DATE DESCRIPTION BY ENG CHK APP