


\$\$\$\$\$\$SPECIFICATION\$\$\$\$\$\$
 \$\$\$\$SYTIME\$\$\$\$\$\$
 \$\$\$PRF\$\$\$
 \$\$\$USERNAME\$\$\$
 \$\$\$PRF ROT\$\$\$
 \$\$\$PEN\$\$\$
 \$\$\$FILE6\$\$\$
 \$\$\$FILE7\$\$\$
 \$\$\$FILE8\$\$\$
 \$\$\$FILE9\$\$\$
 \$\$\$FILE10\$\$\$
 ABTCELO3.004 ELEC
 ABTCELR3.008 ELEC
 ABTCCACR1.DGN RCP
 \$\$\$FILE4\$\$\$
 \$\$\$FILE5\$\$\$

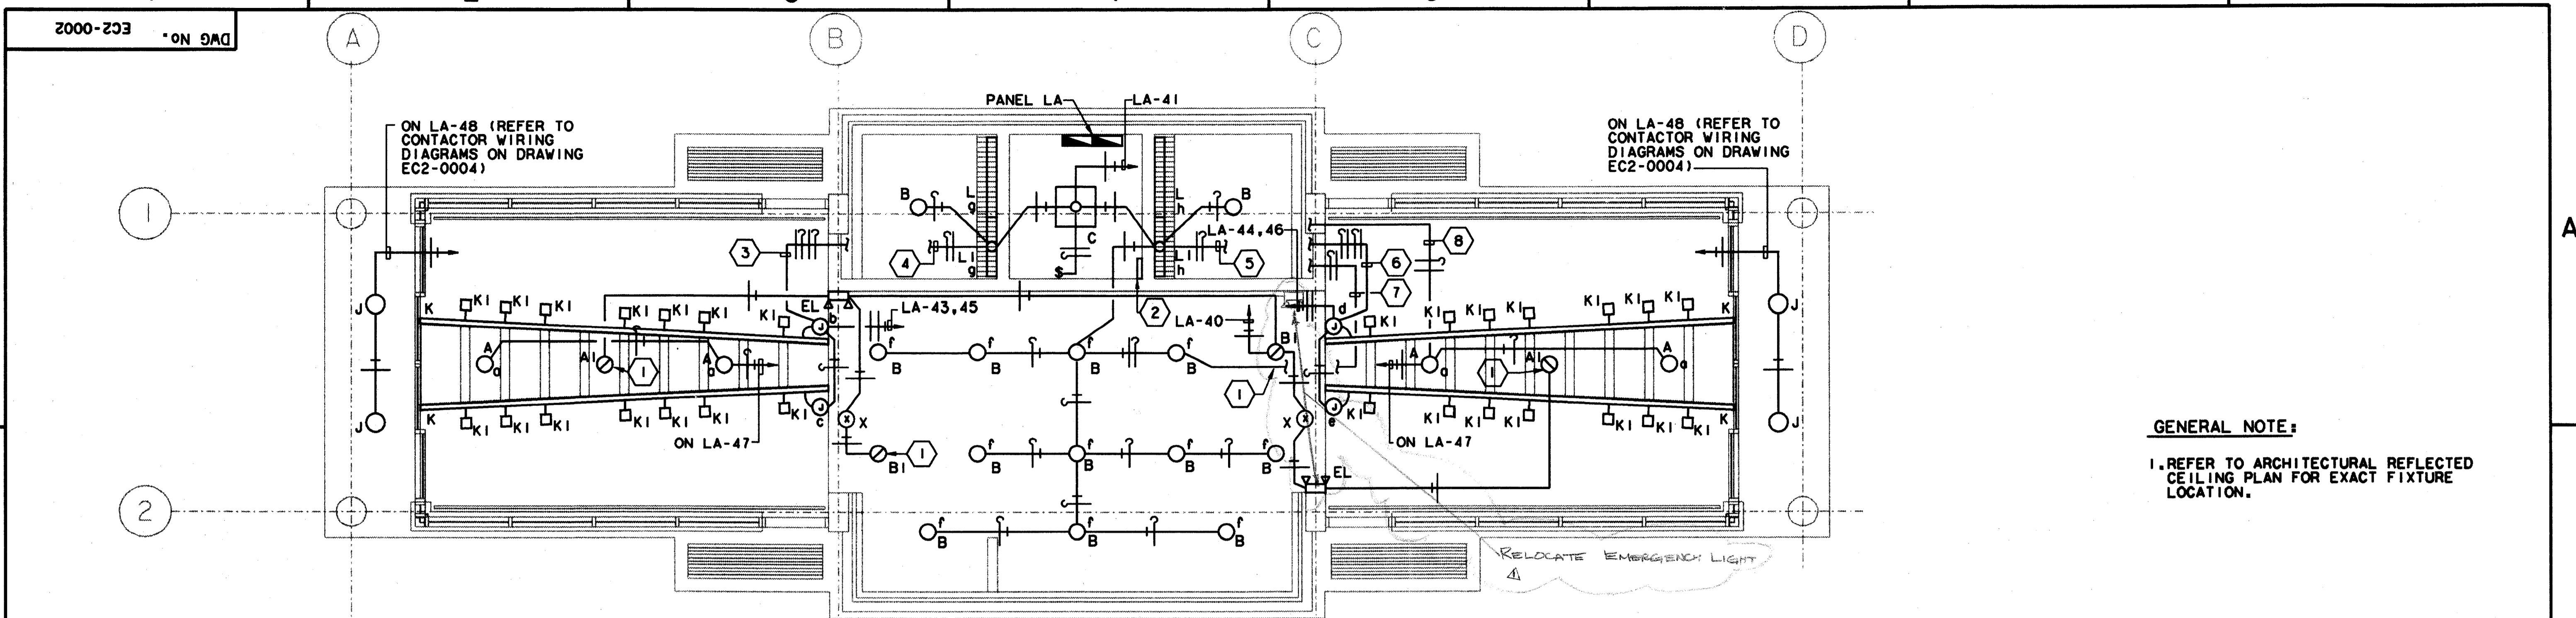

ENCLOSURE LIGHTING PLAN 01
SCALE: 1/4" = 1'-0"

GENERAL NOTE:
1. REFER TO ARCHITECTURAL REFLECTED CEILING PLAN FOR EXACT FIXTURE LOCATION.

- KEY NOTE:**
- 1 SECURITY LIGHT FIXTURE.
 - 2 LOCATION OF SWITCHES a, b, c, d, e, f, g & h. ARRANGE SWITCHES IN TWO ROWS OF FOUR.
 - 3 TO SWITCHES b & c. REFER TO KEY NOTE #2.
 - 4 TO SWITCH g. REFER TO KEY NOTE #2.
 - 5 TO SWITCH h. REFER TO KEY NOTE #2.
 - 6 TO SWITCHES d & e. REFER TO KEY NOTE #2.
 - 7 TO SWITCH f. REFER TO KEY NOTE #2.
 - 8 TO SWITCH a. REFER TO KEY NOTE #2.

LIGHT FIXTURE SCHEDULE

TYPE	DESCRIPTION	LAMPS	NOTES	TYPE	DESCRIPTION	LAMPS	NOTES
A	6" ROUND RECESSED INCANDESCENT DOWN LIGHT PRESCOLITE NO. INC600-ST1602	150W A21 38	WAITING AREA	G	42" VANDAL RESISTANT BOLLARD LIGHT FIXTURE. KIM NO. VRB1/100MH120/DB-P	100 W MH	SITE
A1	SAME AS TYPE A EXCEPT USED FOR SECURITY.			H	WALL MOUNTED H.I.D. LIGHT FIXTURE. KIM NO. WD14D2/175MH208/WHP	175 W MH	MOUNTED ON CANOPY COLUMN FOR 100% UPLIGHT AT 40 DEGREE ANGLE FROM VERTICAL. NO. J-27H/DB-P HARDWARE.
B	4" ROUND RECESSED INCANDESCENT DOWN LIGHT PRESCOLITE NO. 1222-262	100W A19	VENDING, TELEPHONE, DRINKING & MANAGER AREAS	EL	WALL MOUNTED EMERGENCY BATTERY PACK. PRESCOLITE NO. EMAX.	INCLUDED	GENERAL AREA.
B1	SAME AS TYPE B EXCEPT USED FOR SECURITY.			J	RECESSED ROUND COMPACT FLUORESCENT LIGHT FIXTURE. PRESCOLITE NO. CF1013RD-F8.	2-13WPL	EXTERIOR CANOPY.
C	RECESSED 10" SQUARE COMPACT FLUORESCENT LIGHT FIXTURE. PRESCOLITE NO. CF85Q25-2	2-9W PL	JANITOR'S CLOSET	K	SINGLE CIRCUIT LIGHT TRACK. PRESCOLITE TS SERIES	-	WAITING AREA. LENGTH AS SHOWN ON PLAN. WHITE FINISH
D	POLE MOUNTED H.I.D. LIGHT FIXTURE. KIM NO. AR5/175-208	MS-175/HOR	PARKING LOTS. 12' POLE	KI	FLAT BACK CYLINDRICAL LIGHT TRACK FIXTURE HEAD. PRESCOLITE NO. T104	150W PAR 38 R40	WAITING AREA. WHITE FINISH.
D1	SAME AS TYPE D EXCEPT USED FOR SECURITY.			L	4' FLUORESCENT STRIP LIGHT FIXTURE. COLUMBIA CS240-120 ES	2-F32T8	RESTROOMS. ELECTRONIC BALLAST
E	POLE MOUNTED H.I.D. LIGHT FIXTURE. KIM NO. AR3/175-208	MS-175/HOR	PARKING LOTS. 12' POLE	LI	3' FLUORESCENT STRIP LIGHT FIXTURE. COLUMBIA NO. CS3-230-120ES.	2-F25T8	RESTROOMS. ELECTRONIC BALLAST
E1	SAME AS TYPE E EXCEPT USED FOR SECURITY.			M	STANCHION MOUNTED ADJUSTABLE H.I.D. FLOODLIGHT WITH WIDE FLOOD DISTRIBUTION AND FIXED HOOD SHIELD ACCESSORY. KIM NO. AFL1/175MH/FH/208.	175 W MH ED-17 MEDIUM BASE	MOUNTED 8' FROM EITHER SIDE OF DART SIGN AT MIDPOINT OF SIGN.
F	POLE MOUNTED H.I.D. LIGHT FIXTURE. KIM NO. AR5/175-208	MS-175/HOR	PARKING LOTS. 12' POLE	X	UNIVERSAL MOUNTED EXIT LIGHT. PRESCOLITE NO. LEDR-1-NB-W.	INCLUDED	EXITS.
F1	SAME AS TYPE F EXCEPT USED FOR SECURITY.						

Record (As-built) Certification
 "Having checked this submission, we certify that it conforms to the requirements of the contract in all respects, except as otherwise indicated."
 Contract Number:
 Company Name:
 Officer of Firm Signature:
 Date:
 Officer of Firm Name (typed):
 Title of Officer (typed):
 Seal of Professional Engineer of Construction Contractors, including signature and date, thereby attesting record (as-built) drawings for accuracy of as-built condition reflected herein, must be placed below:

7-7-99

CONFORMED

CONTRACT SHEET No. 93 OF 95

**ADDISON
 TRANSIT CENTER
 ENCLOSURE LIGHTING
 PLAN**

REV	DATE	DESCRIPTION	BY	ENG	CHK	APP	REV	DATE	DESCRIPTION	BY	ENG	CHK	APP
1	8/30/99	Revised As-Built Schedule		RDM		JLM							

GERARD & ASSOCIATES
 CONSULTING ENGINEERS
 Mechanical Electrical Plumbing
 Systems Design
 409 Centre Dallas, Texas 75208 (214)946-6404

WENDY LOPEZ & ASSOCIATES, INC.
 ENGINEERING • SURVEYING • CONSTRUCTION SERVICES
 100 MARKET CENTER BLVD - SUITE 510
 DALLAS, TEXAS 75207
 (214) 746-7777

DART PROJECT

SCALE 1/4" = 1'-0"
 DRAWN P. LLOYD
 DESIGNED V. GERARD
 CHECKED V. GERARD
 IN CHARGE V. STEVENS
 DATE 14 AUG 97

CONTRACT C-97000136
 DWG No. EC2-0002
 REV 01