


FOUNDATION PLAN
SCALE: 1" = 20'-0"

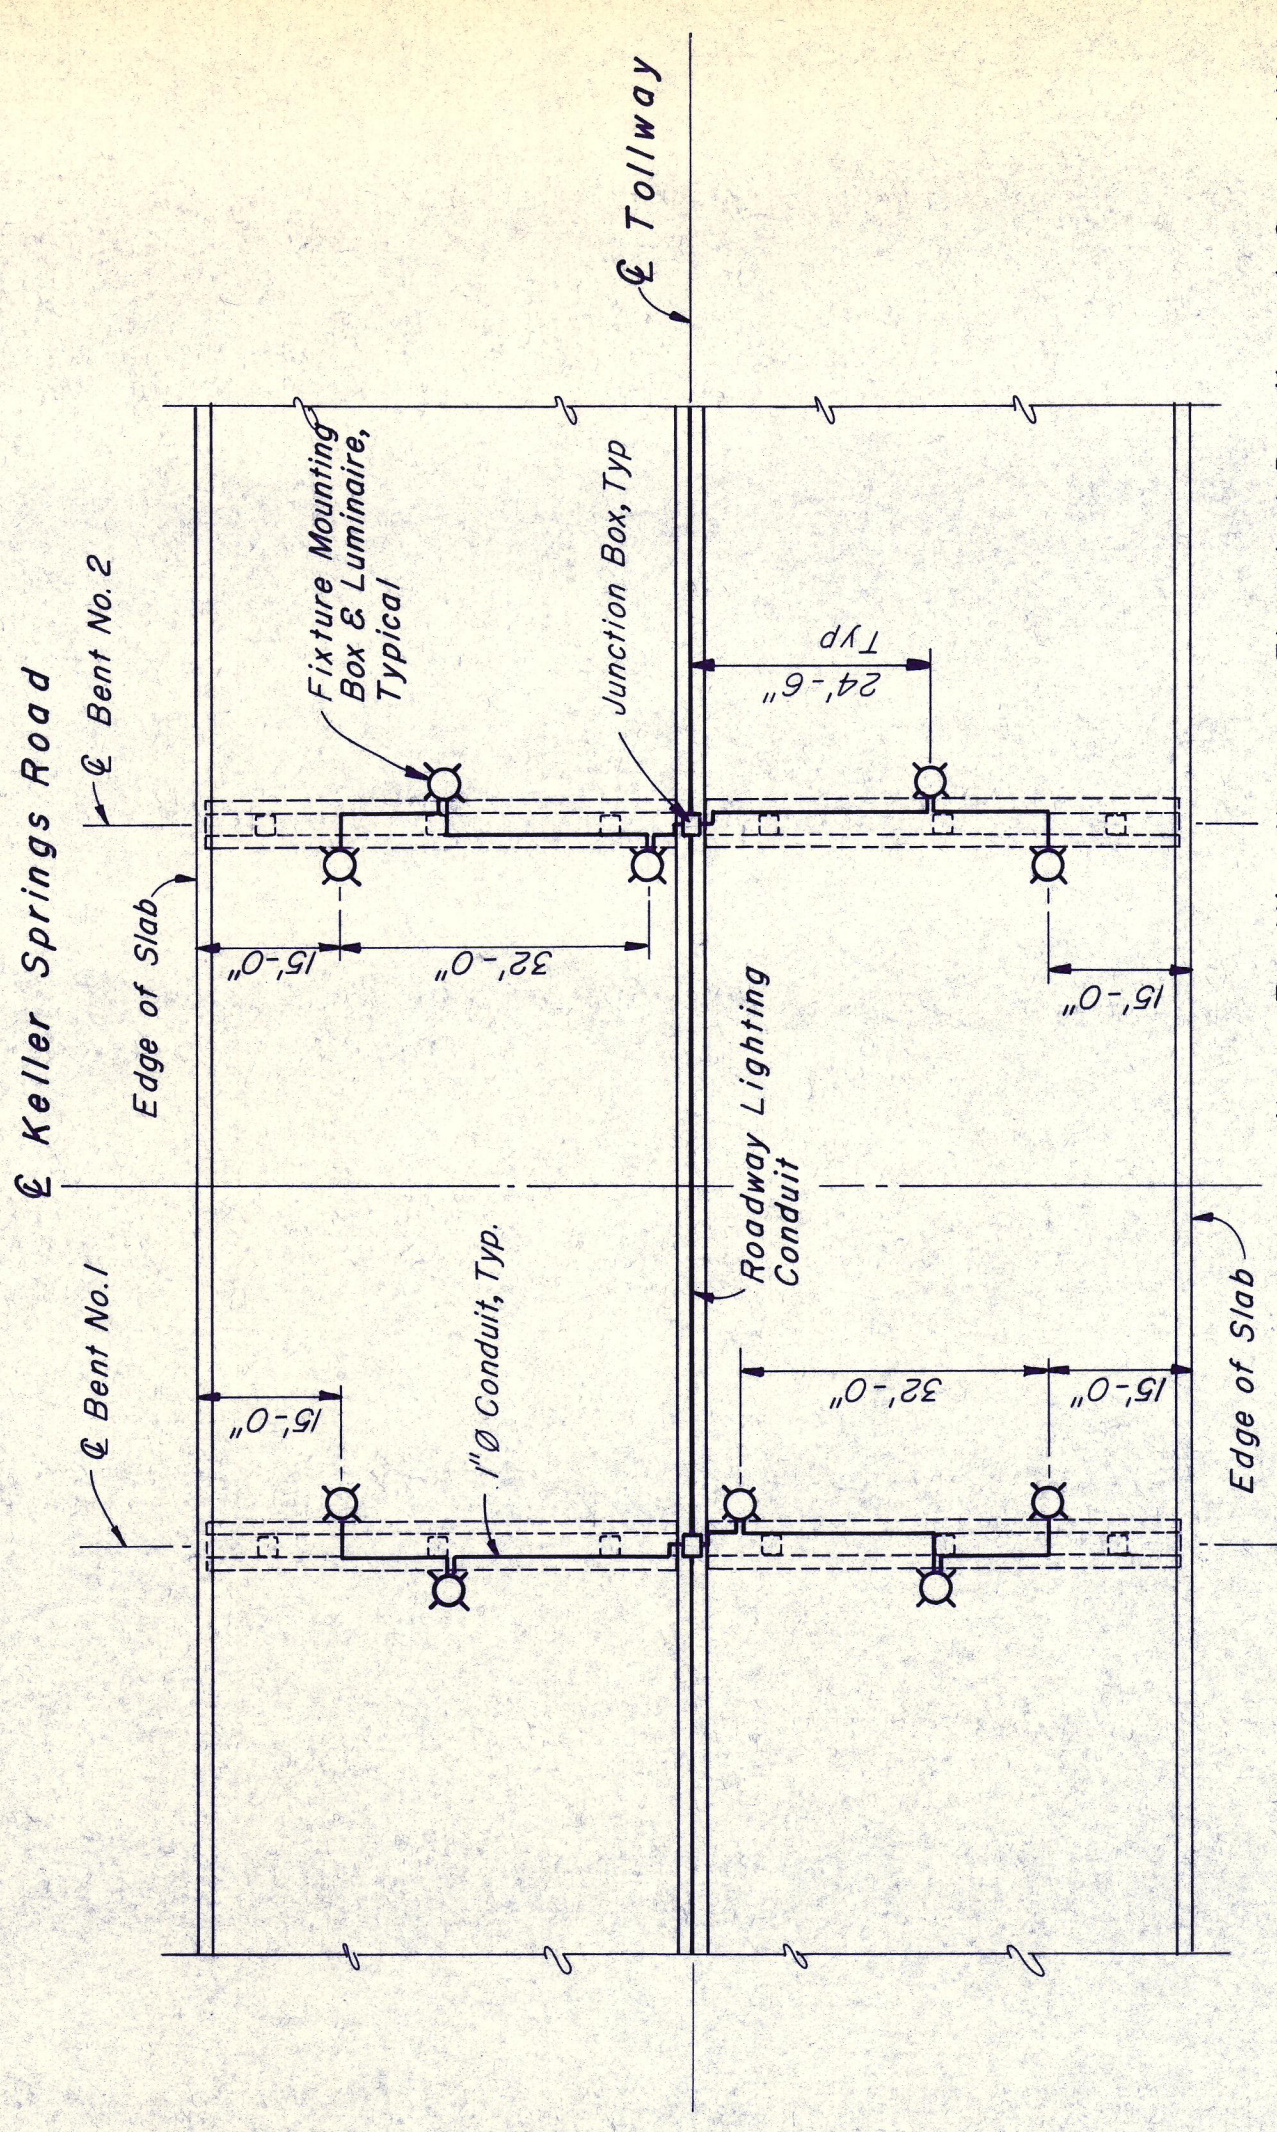

Note: For Miscellaneous Electrical Details and General Notes, See STD Dwg No. 36 & 37. Only Embedded Materials Shall Be Paid For In This Contract.

UNDERBRIDGE LIGHTING PLAN
SCALE: 1" = 20'-0"

NO.	REVISION	BY	DATE
TEXAS TURNPIKE AUTHORITY DALLAS NORTH TOLLWAY KELLER SPRINGS ROAD OVERPASS FOUNDATION PLAN			
Gibbs & Hill, Inc. ENGINEERS DESIGNERS CONSTRUCTORS DALLAS		SECTION VII	
DRAWN	VER	DATE	DESIGNED
CHECKED	REF	DATE	SCALE
CONTRACT NO. DNT-115			SHEET S2 OF S21