

HORIZONTAL SECTION



ELEVATION

ABUTMENT DETAIL

OVERPASS BRIDGE ROADWAY LIGHTING CONDUIT

VERTICAL SECTION

UNDERPASS BRIDGE UNDERBRIDGE LIGHTING - ABUTMENT MOUNTING

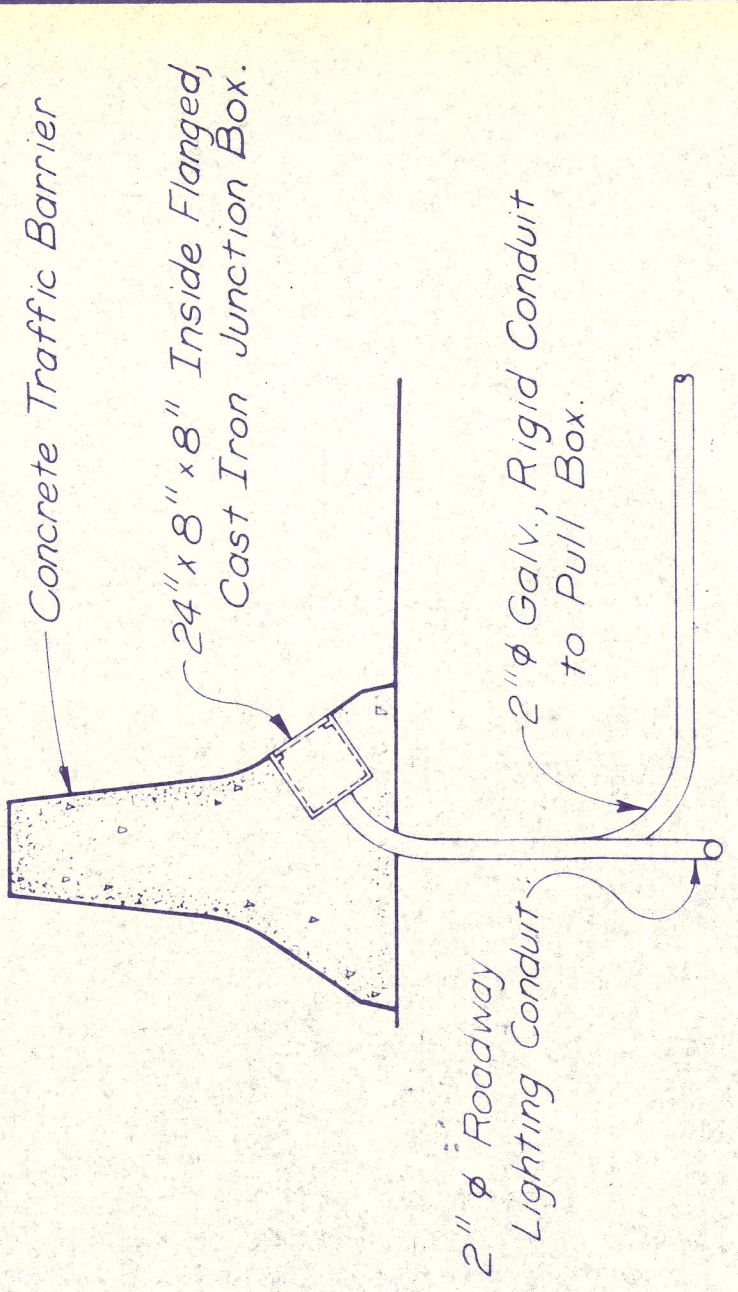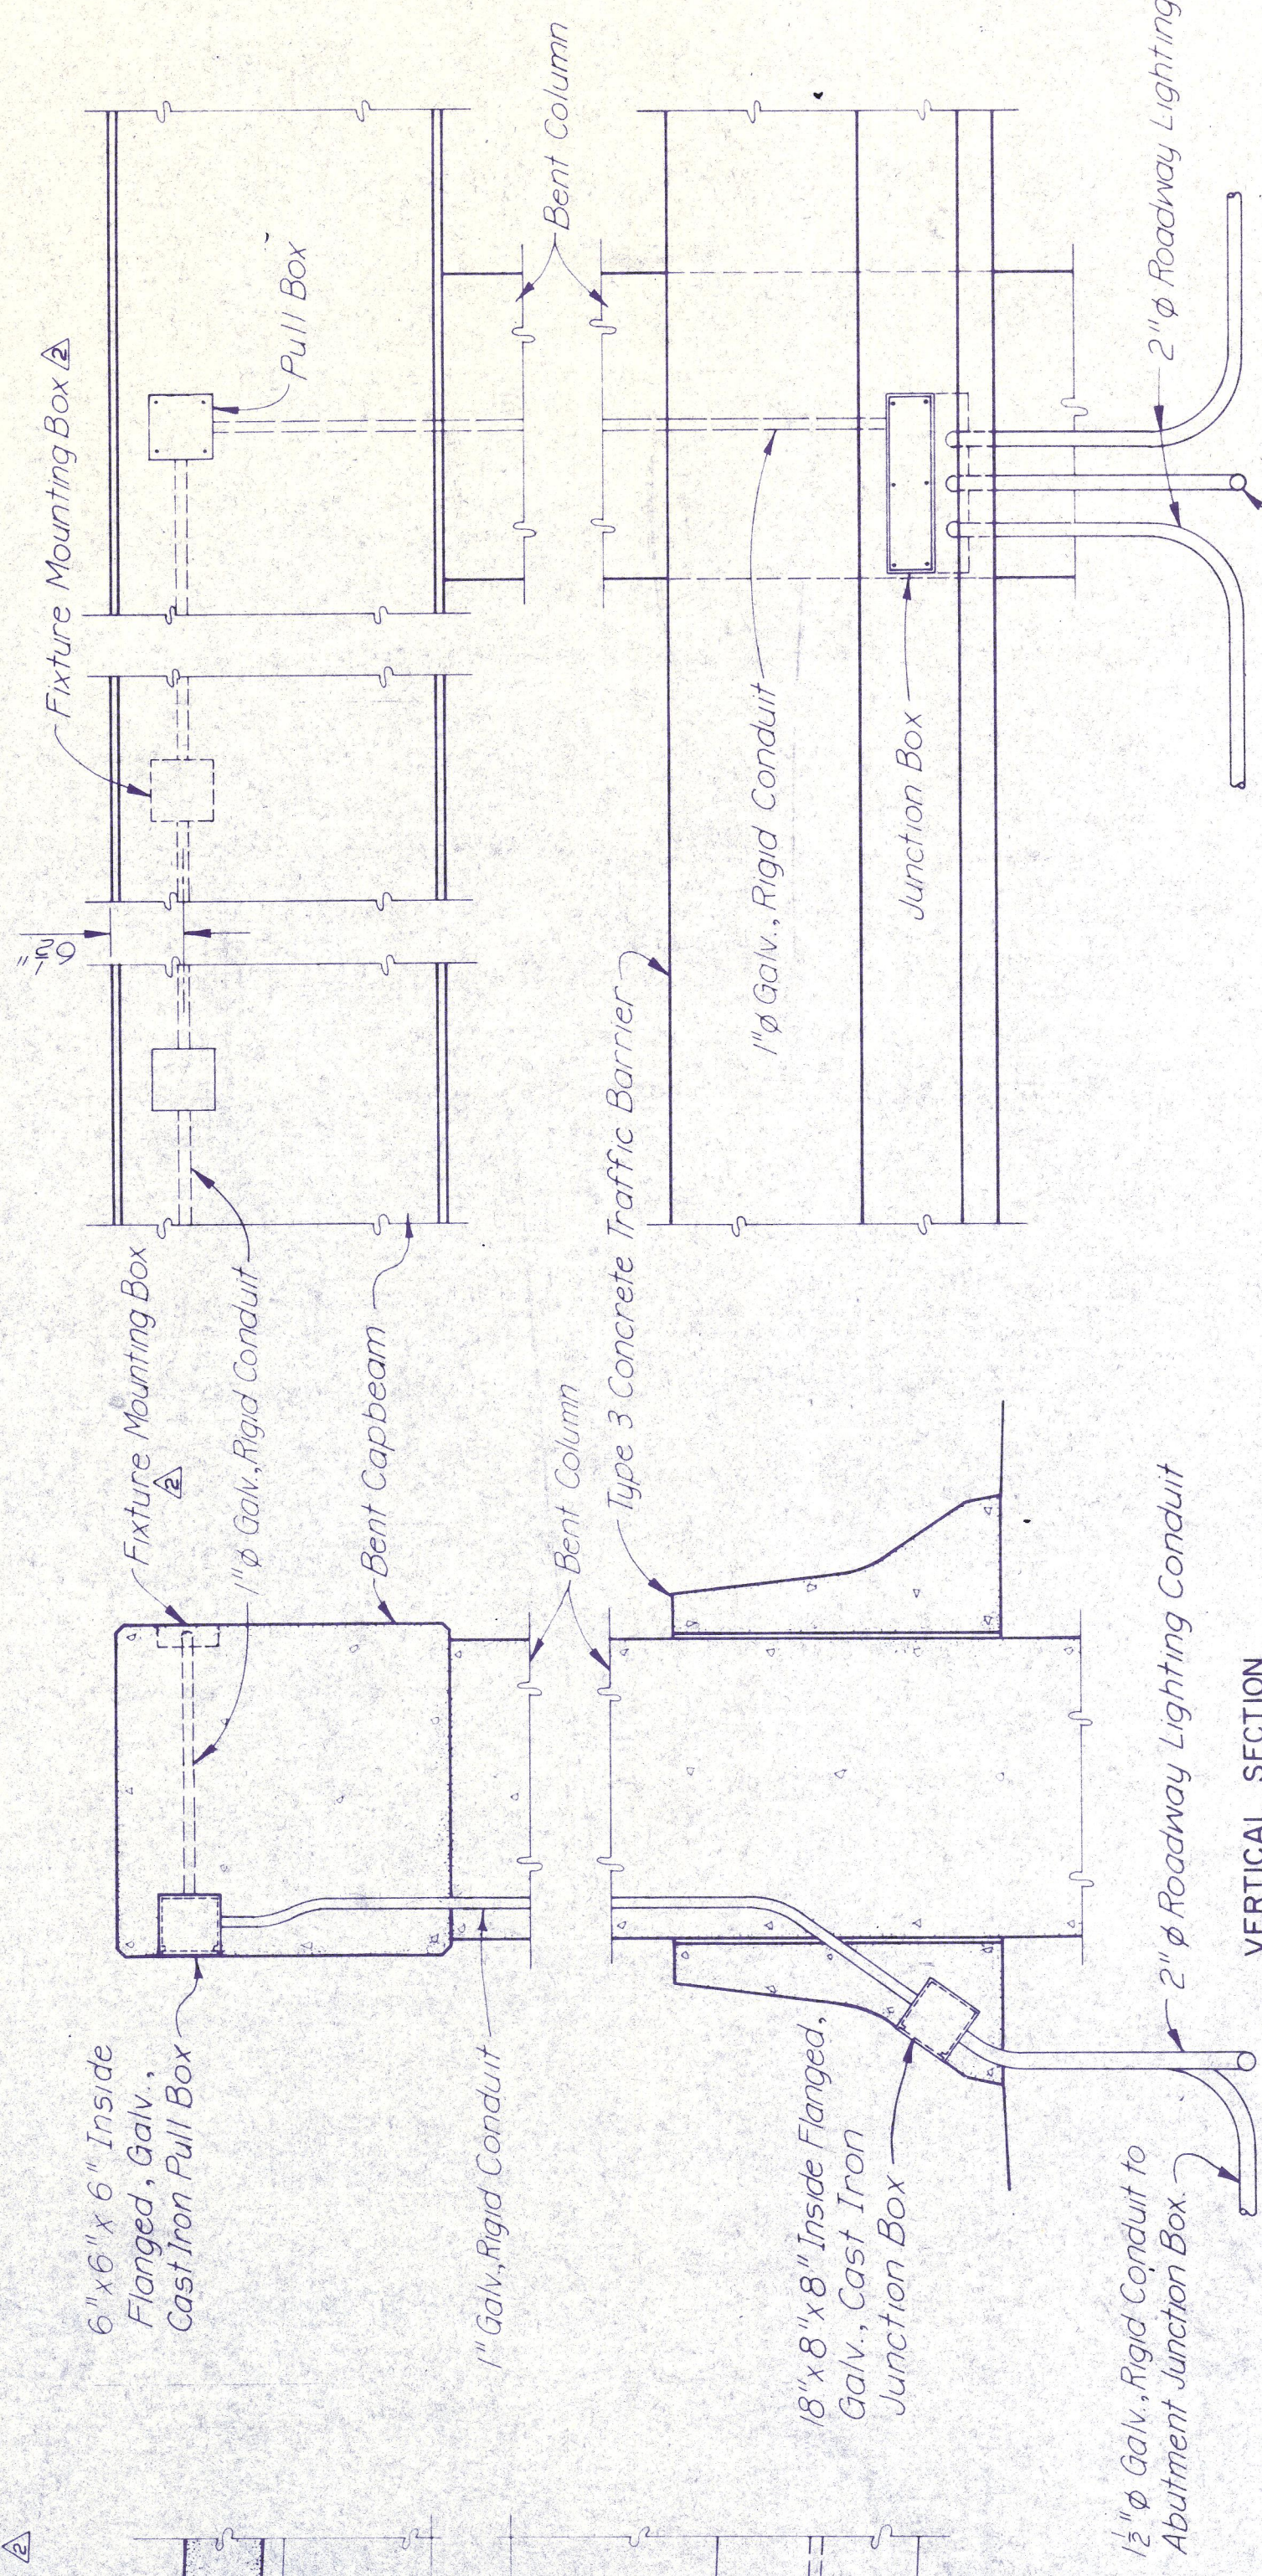

MEDIAN CONDUIT JUNCTION DETAIL

ELEVATION

VERTICAL SECTION

UNDERPASS BRIDGE UNDERBRIDGE LIGHTING - BENT MOUNTING

JUNCTION & FIXTURE MOUNTING BOXES		J/K	8-15-84
CONDUIT JUNCTION DETAIL		J/K	1-5-84
NO.	REVISION	BY	DATE
TEXAS TURNPIKE AUTHORITY			
DALLAS NORTH TOLLWAY			
MISCELLANEOUS ELECTRICAL DETAILS			
HOWARD NEEDLES TAMMEN & BERENSON		SECTION VII	
DRAWN	CHECKED	DATE	DATE
J.P.K.	G.D.T.	8-15-84	8-25-84
9577	0779-82	JOSE	
STANDARD DRAWING NO. 36			