


FOUNDATION PLAN  
SCALE: 1"=20'-0"

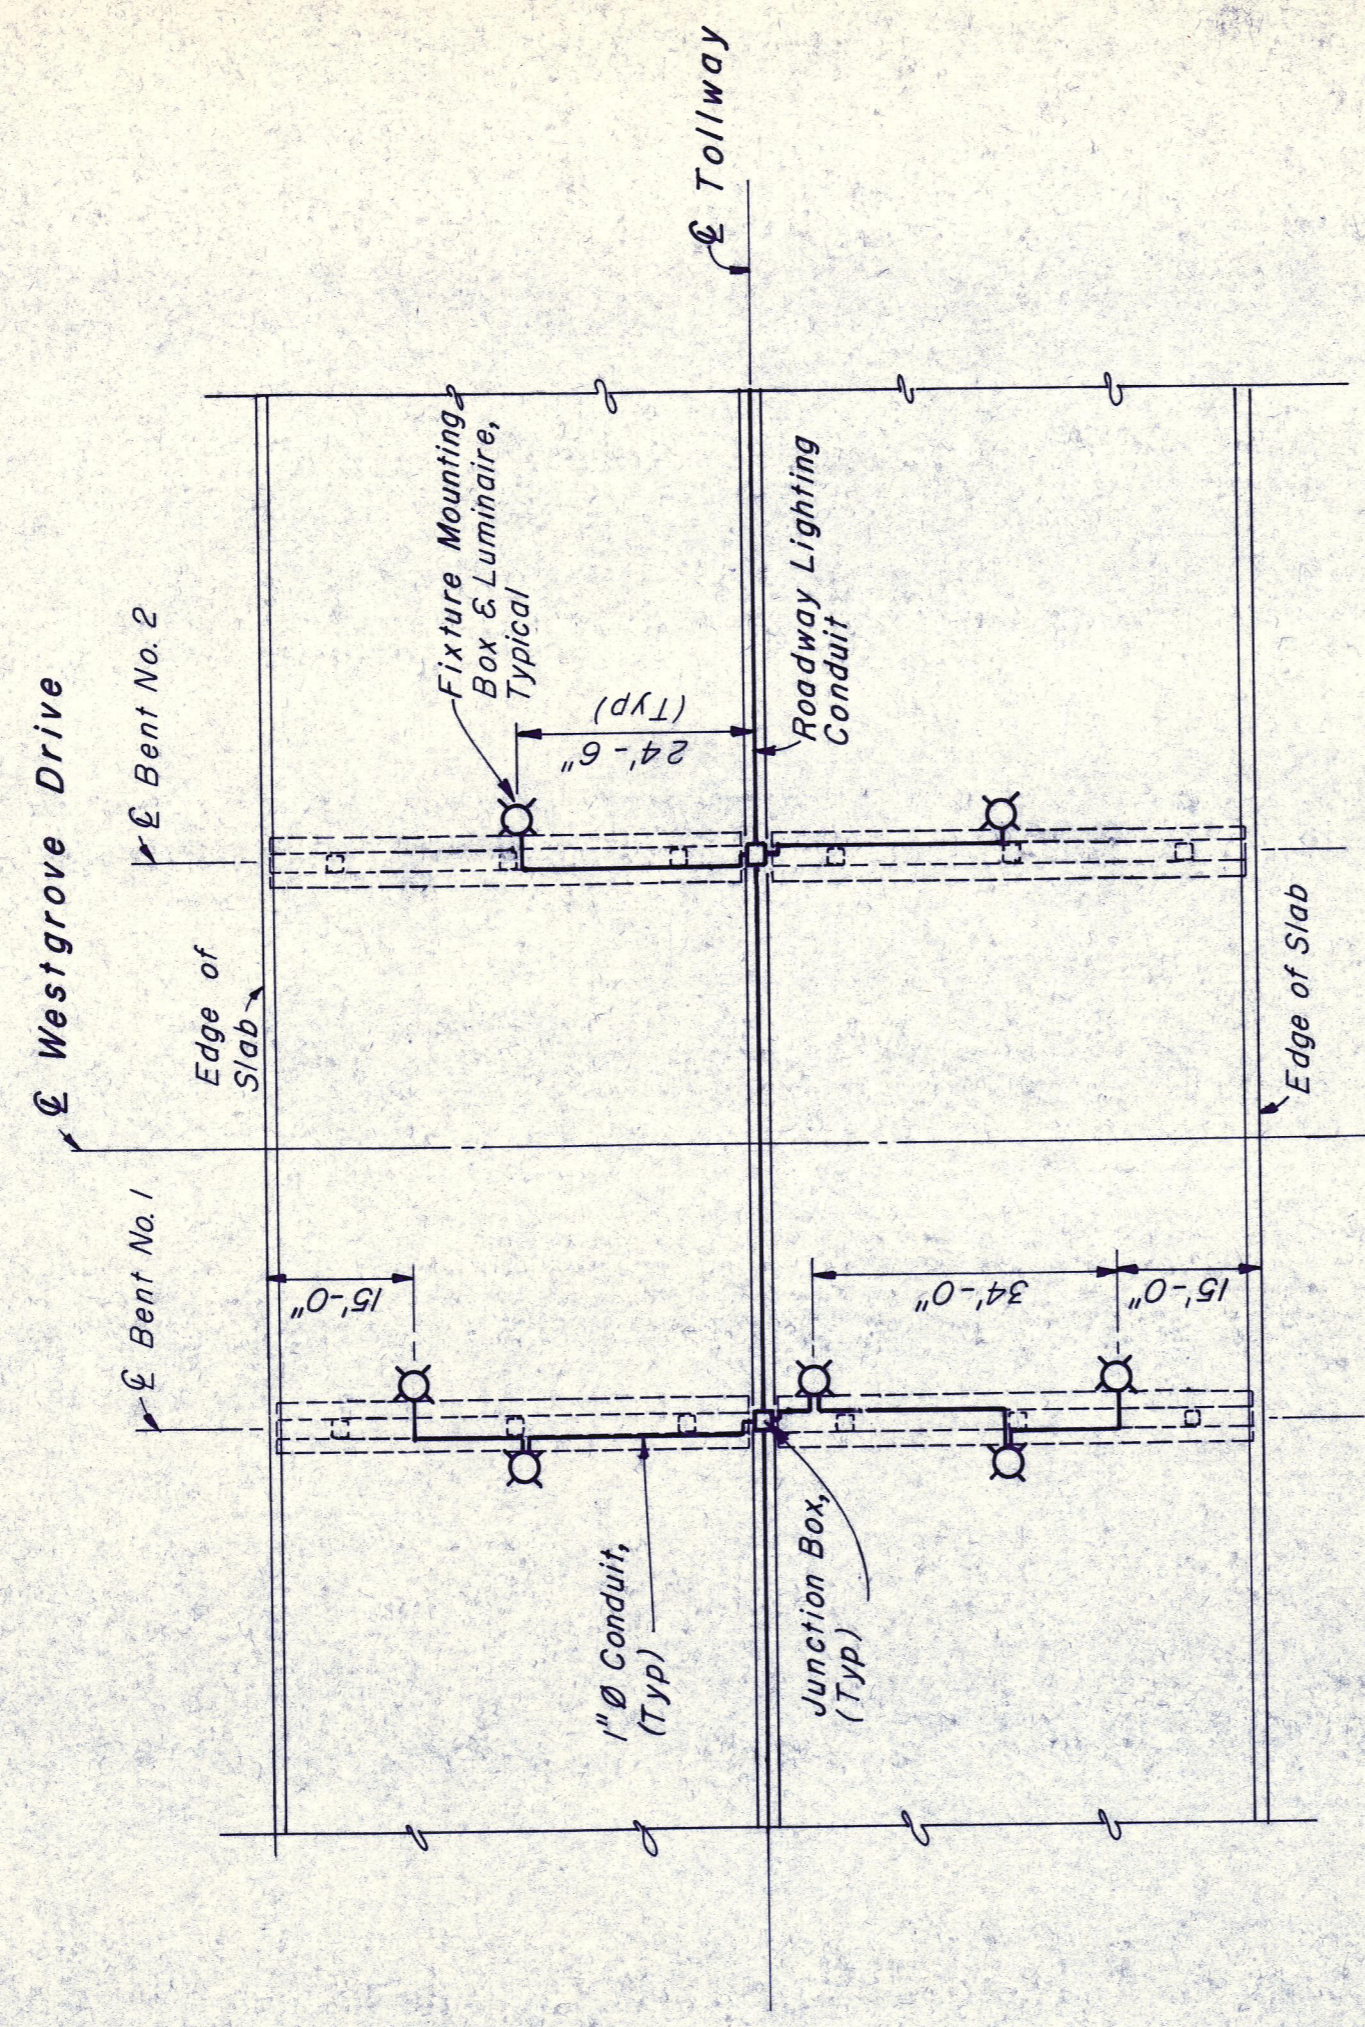

NOTE: For Miscellaneous Electrical Details & General Notes  
See Std Dwg No. 36 & 37.  
Only Embedded Materials Shall Be Paid For In This Contract.

UNDERBRIDGE LIGHTING PLAN  
SCALE: 1"=20'-0"

NO.	REVISION	BY	DATE
TEXAS TURNPIKE AUTHORITY <b>DALLAS NORTH TOLLWAY</b> WESTGROVE DRIVE OVERPASS FOUNDATION PLAN			
<b>Gibbs &amp; Hill, Inc.</b> ENGINEERS DESIGNERS CONSTRUCTORS DALLAS			SECTION VII
DRAWN	VER	DATE	DESIGNED
CHECKED	REF	DATE	SCALE
		8-4-83	8-3-83
		8-4-83	As Shown
CONTRACT NO. DNT-115			SHEET 11 OF 21