

INDEX OF SHEETS

SHEET No.	TITLE
1	TITLE SHEET
C1 - C3	GEOMETRIC CONTROLS & TRAVERSE TIES
R1 - R2	TYPICAL SECTION
R3 - R4	ESTIMATED QUANTITY SUMMARY
R5 - R14	PAVING & GRADING - DALLAS PARKWAY
R15 - R24	PAVING & GRADING - TOLLWAY
R25	RAMP PROFILES
R26 - R28	PAVING PLAN - TOLL PLAZA AREA
R29 - R33	PAVING PLAN - INTERSECTIONS AND RAMP
R34 - R40	SUGGESTED CONSTRUCTION SEQUENCE AND TRAFFIC CONTROL
R41 - R43	DRAINAGE AREA MAP
R44 - R48	DRAINAGE SUMMARY
R49 - R67	STORM SEWER PROFILES
R68 - R69	BOX CULVERT - STATION 642+50
R70 - R72	BOX CULVERT - STATION 678+20
R73	PIPE HEADWALL AND RIPRAP DETAILS - STATION 737+50
R74	MISCELLANEOUS DETAILS
R75 - R84	EXISTING UTILITIES
R85	MISCELLANEOUS DETAILS - SIGNING & STRIPING
RETAINING WALLS	
W1	SSW RAILWAY UNDERPASS
W2 - W5	KELLER SPRINGS ROAD OVERPASS
W6 - W10	WESTGROVE DRIVE OVERPASS
W11 - W12	STATION 669+50 TO STATION 714+50
KELLER SPRINGS ROAD OVERPASS	
S1	GENERAL PLAN AND ELEVATION
S2	FOUNDATION PLAN
S3	SOUTH ABUTMENT DETAILS
S4	NORTH ABUTMENT DETAILS
S5 - S6	BENT DETAILS
S7 - S8	SLAB DETAILS
S9	SLAB ELEVATIONS
WESTGROVE DRIVE OVERPASS	
S10	GENERAL PLAN AND ELEVATION
S11	FOUNDATION PLAN
S12	SOUTH ABUTMENT DETAILS
S13	NORTH ABUTMENT DETAILS
S14 - S15	BENT DETAILS
S16 - S17	SLAB DETAILS
S18 - S20	SLAB ELEVATIONS
S21	PRESTRESSED CONCRETE BEAMS - DESIGN DETAILS

TEXAS TURNPIKE AUTHORITY

CONTRACT NO. DNT 115
GRADING, DRAINAGE,
PAVING AND STRUCTURES


SECTION VII
VOLUME 1

STANDARD DRAWINGS

STD. No.	TITLE
1	TOLLWAY INLET TYPE "C"
2	TOLLWAY MEDIAN INLET TYPE "M"
3	TOLLWAY GUTTER INLET TYPE "G"
4	STANDARD INLET TYPE "CDR" - 3', 4' & 5'
5	STANDARD INLET TYPE "CDR" - 6', 8' & 10'
6	STANDARD INLET TYPE "CDR" - 14'
7	RECESSED AND "V" INLET DETAILS
8	STANDARD TOLLWAY MANHOLES TYPE I, II & III
9	MANHOLE DETAILS
10	STANDARD UNDERDRAINS
11	MISCELLANEOUS DETAILS - TOLLWAY
12	TOLLWAY PAVEMENT DETAILS - JOINTED REINFORCED
13	CONCRETE PAVING DETAILS - JOINT SEALS
14 & 15	MISCELLANEOUS DETAILS - SERVICE ROADS
16	CONCRETE RIPRAP SLOPE PROTECTION WITH WALLS
17	APPROACH SLAB DETAILS
18	PRESTRESSED CONCRETE BEAMS - BEAM DETAILS
19	PRESTRESSED CONCRETE BEAMS - BEAM ENDS & BEARINGS
20	PRESTRESSED CONCRETE BEAMS - MINIMUM ERECTION AND BRACING REQUIREMENTS - TYPE "C" BEAMS
21	INTERIOR DIAPHRAGM AND PRECAST RAIL ANCHORAGE DETAILS
22	ARMOR JOINT DETAILS
23	BRIDGE PROTECTIVE ASSEMBLY
24	CONCRETE TRAFFIC RAIL TYPE T5
25	CONCRETE TRAFFIC BARRIER - TYPE 1
26	CONCRETE TRAFFIC BARRIER TYPE 2 & 3
27	MISCELLANEOUS ELECTRICAL DETAILS
28	ELEVATED ROADWAY SECTION - CAST-IN-PLACE CONCRETE
29	RETAINING WALL DETAILS
30	DEPRESSED ROADWAY SECTION - CAST-IN-PLACE CONCRETE
31	RETAINING WALL DETAILS
32	BARRICADES AND CONSTRUCTION STANDARDS
33	CONCRETE BARRIER RAIL (PORTABLE & PRECAST)
34	MULTIPLE BOX CULVERTS - MC 8-3
35	MULTIPLE BOX CULVERTS - MC 10-2
36-37	MULTIPLE BOX CULVERTS - MC 10-3
38	PRECAST CONCRETE BOX CULVERTS - PC-3
39	FLARED WINGWALLS FOR MULTIPLE CULVERTS - MCW-F2
40	PARALLEL WINGS FOR MULTIPLE BOX CULVERTS - MCW-P-45
41	MULTIPLE BOX CULVERT - 45 DEGREE SKEW

DALLAS NORTH TOLLWAY

VOLUME 2
1 - 95 CROSS SECTIONS

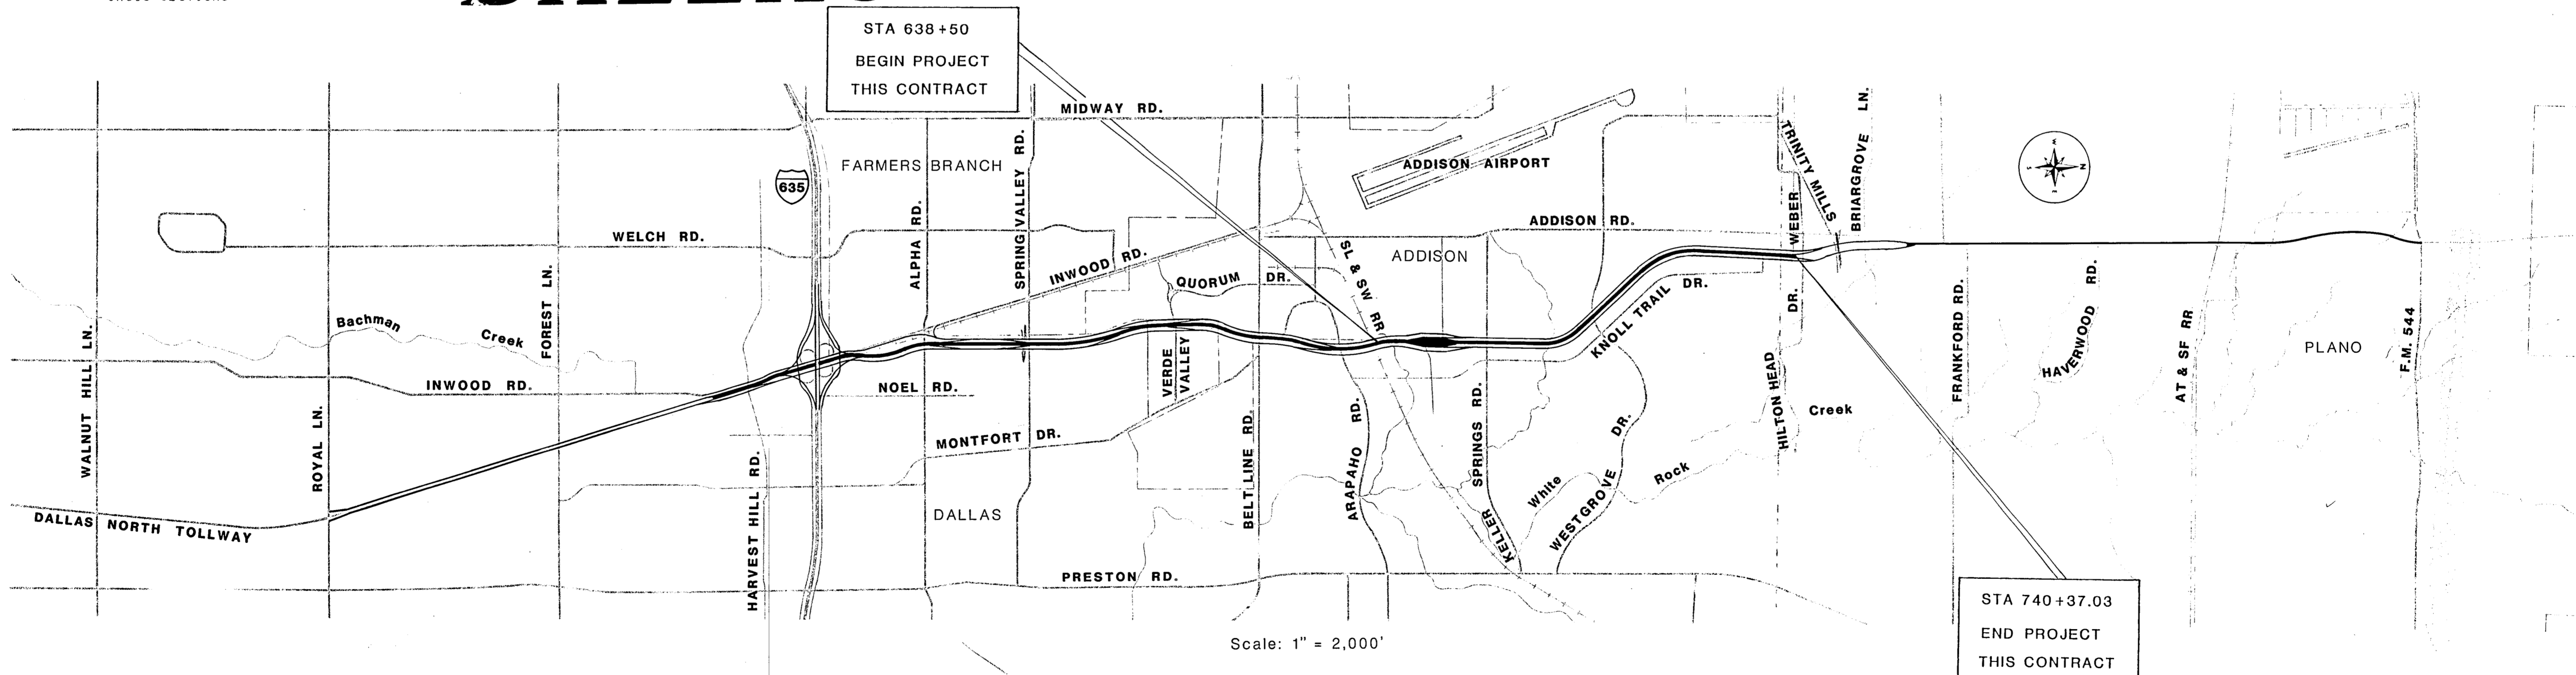

APPROVED by:
CITY of DALLAS

DIRECTOR of PUBLIC WORKS
DATE: _____

APPROVED by:
TOWN of ADDISON

DATE: _____

Prepared by:
GIBBS & HILL, INC./BRIDGEFARMER & ASSOCIATES, INC.
David W. Clary

Date: September 6, 1984



Recommended by:
HOWARD, NEEDLES, TAMMEN & BERGENDOFF
David L. Becker

Engineer in Charge
Date: Sept 6, 1984



Recommended by:
TEXAS TURNPIKE AUTHORITY
James W. Griffin

Director, Engineering & Maintenance
Date: Sept. 6, 1984

Approved by:
TEXAS TURNPIKE AUTHORITY
Tom Wiley

Engineer Manager
Date: 9-7-84

