

INDEX OF SHEETS

| SHEET No. | TITLE |
|-------------------------------------|-----------------------------------------------------------------------|
| 1 | TITLE SHEET |
| C1 - C3 | GEOMETRIC CONTROLS & TRAVERSE TIES |
| R1 - R2 | TYPICAL SECTION |
| R3 - R4 | ESTIMATED QUANTITY SUMMARY |
| R5 - R14 | PAVING & GRADING - DALLAS PARKWAY |
| R15 - R24 | PAVING & GRADING - TOLLWAY |
| R25 | RAMP PROFILES |
| R26 - R28 | PAVING PLAN - TOLL PLAZA AREA |
| R29 - R33 | PAVING PLAN - INTERSECTIONS AND RAMPS |
| R34 - R40 | SUGGESTED CONSTRUCTION SEQUENCE AND TRAFFIC CONTROL |
| R41 - R43 | DRAINAGE AREA MAP |
| R44 - R48 | DRAINAGE SUMMARY |
| R49 - R67 | STORM SEWER PROFILES |
| R68 - R69 | BOX CULVERT - STATION 642+50 |
| R70 - R72 | BOX CULVERT - STATION 678+20 |
| R73 | PIPE HEADWALL AND RIPRAP DETAILS - STATION 737+50 |
| R74 | MISCELLANEOUS DETAILS |
| R75 - R84 | EXISTING UTILITIES |
| R85 | MISCELLANEOUS DETAILS - SIGNING & STRIPING |
| RETAINING WALLS | |
| W1 - W5 | SSW RAILWAY UNDERPASS |
| W6 - W10 | KELLER SPRINGS ROAD OVERPASS |
| W11 - W12 | WEST GROVE DRIVE OVERPASS |
| * | STATION 669+50 TO STATION 714+50 * W13 - W22 TRINITY MILLS/BRIARGROVE |
| KELLER SPRINGS ROAD OVERPASS | |
| S1 | GENERAL PLAN AND ELEVATION |
| S2 | FOUNDATION PLAN |
| S3 | SOUTH ABUTMENT DETAILS |
| S4 | NORTH ABUTMENT DETAILS |
| S5 - S6 | BENT DETAILS |
| S7 - S8 | SLAB DETAILS |
| S9 | SLAB ELEVATIONS |
| WEST GROVE DRIVE OVERPASS | |
| S10 | GENERAL PLAN AND ELEVATION |
| S11 | FOUNDATION PLAN |
| S12 | SOUTH ABUTMENT DETAILS |
| S13 | NORTH ABUTMENT DETAILS |
| S14 - S15 | BENT DETAILS |
| S16 - S17 | SLAB DETAILS |
| S18 - S20 | SLAB ELEVATIONS |
| S21 | PRESTRESSED CONCRETE BEAMS - DESIGN DETAILS |

TEXAS TURNPIKE AUTHORITY

CONTRACT NO. DNT 115


**GRADING, DRAINAGE,
PAVING AND STRUCTURES**

**SECTION VII
VOLUME 1**

STANDARD DRAWINGS

| STD. No. | TITLE |
|----------|-----------------------------------------------------------------------------------------|
| 1 | TOLLWAY INLET TYPE "C" |
| 2 | TOLLWAY MEDIAN INLET TYPE "M" |
| 3 | TOLLWAY GUTTER INLET TYPE "G" |
| 4 | STANDARD INLET TYPE "CDR" - 3', 4' & 5' |
| 5 | STANDARD INLET TYPE "CDR" - 6', 8' & 10' |
| 6 | RECESSED AND "Y" INLET DETAILS |
| 7 | STANDARD TOLLWAY MANHOLES TYPE I, II & III |
| 8 | MANHOLE DETAILS |
| 9 | STANDARD UNDERDRAINS |
| 10 | MISCELLANEOUS DETAILS - TOLLWAY |
| 11 | TOLLWAY PAVEMENT DETAILS - JOINTED REINFORCED |
| 12 | CONCRETE PAVING DETAILS - JOINT SEALS |
| 13 | MISCELLANEOUS DETAILS - SERVICE ROADS |
| 14 & 15 | CONCRETE RIPRAP SLOPE PROTECTION WITH WALLS |
| 16 | APPROACH SLAB DETAILS |
| 17 | PRESTRESSED CONCRETE BEAMS - BEAM DETAILS |
| 18 | PRESTRESSED CONCRETE BEAMS - BEAM ENDS & BEARINGS |
| 19 | PRESTRESSED CONCRETE BEAMS - MINIMUM ERECTION AND BRACING REQUIREMENTS - TYPE "C" BEAMS |
| 20 | INTERIOR DIAPHRAGM AND PRECAST RAIL ANCHORAGE DETAILS |
| 21 | ARMOR JOINT DETAILS |
| 22 | BRIDGE PROTECTIVE ASSEMBLY |
| 23 | CONCRETE TRAFFIC RAIL TYPE T5 |
| 24 | CONCRETE TRAFFIC BARRIER - TYPE 1 |
| 25 | CONCRETE TRAFFIC BARRIER TYPE 2 & 3 |
| 26-27 | MISCELLANEOUS ELECTRICAL DETAILS |
| 28 | ELEVATED ROADWAY SECTION - CAST-IN-PLACE CONCRETE |
| 29 | RETAINING WALL DETAILS |
| 30 | DEPRESSED ROADWAY SECTION - CAST-IN-PLACE CONCRETE |
| 31 | RETAINING WALL DETAILS |
| 32 | BARRICADES AND CONSTRUCTION STANDARDS |
| 33 | CONCRETE BARRIER RAIL (PORTABLE & PRECAST) |
| 34 | MULTIPLE BOX CULVERTS - MC 8-3 |
| 35 | MULTIPLE BOX CULVERTS - MC 10-2 |
| 36 | MULTIPLE BOX CULVERTS - MC 10-3 |
| 37 | PRECAST CONCRETE BOX CULVERTS - PC-3 |
| 38 | FLARED WINGWALLS FOR MULTIPLE CULVERTS - MCW-F2 |
| 39 | PARALLEL WINGS FOR MULTIPLE BOX CULVERTS - MCW-P-45 |
| 40 | MULTIPLE BOX CULVERT - 45 DEGREE SKEW |

DALLAS NORTH TOLLWAY

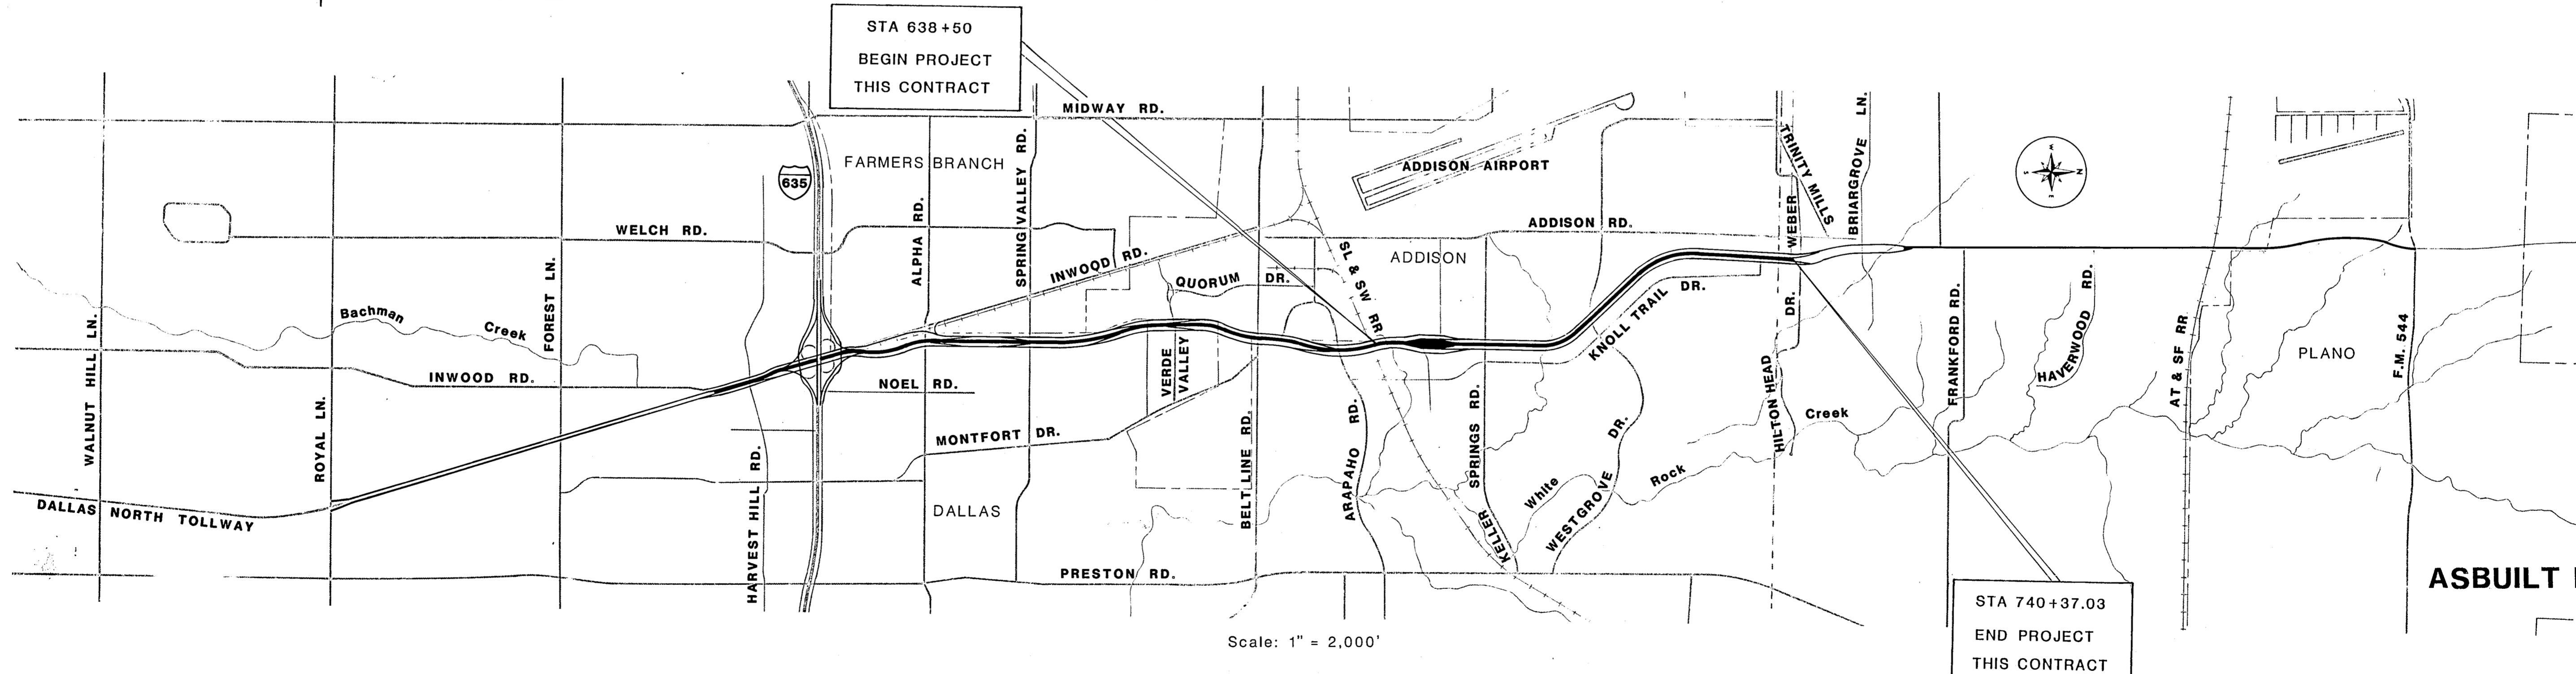

APPROVED by:
CITY of DALLAS
Clifford J. Kelly
DIRECTOR of PUBLIC WORKS

APPROVED by:
[Signature]

Prepared by:
GIBBS & HILL, INC./BRIDGEFARMER & ASSOCIATES, INC.
David W. Clay

Recommended by:
HOWARD, NEEDLES, TAMMEN & BERGENDOFF
Daniel F. Becker
Engineer in Charge

Recommended by:
TEXAS TURNPIKE AUTHORITY
James W. Duffin
Director, Engineering & Maintenance

Approved by:
TEXAS TURNPIKE AUTHORITY
[Signature]
Engineer Manager

DATE: 3/20/84

DATE:

Date: September 6, 1984

Date: Sept 6, 1984

Date: Sept. 6, 1984

Date: 9-7-84



FF-13

FF-13