


NOTE:
See Landscape Plans For Perforated
Pipe Drains For Parking Subgrade
And Water Feature Drains By
Utility Contractor

STORM SEWER CURVE DATA

① Δ = 51°00'00"	② Δ = 77°45'00"	③ Δ = 66°30'00"
R = 70.00'	R = 70.00'	R = 70.00'
T = 33.33'	T = 56.43'	T = 45.89'
L = 62.31'	L = 94.99'	L = 81.24'

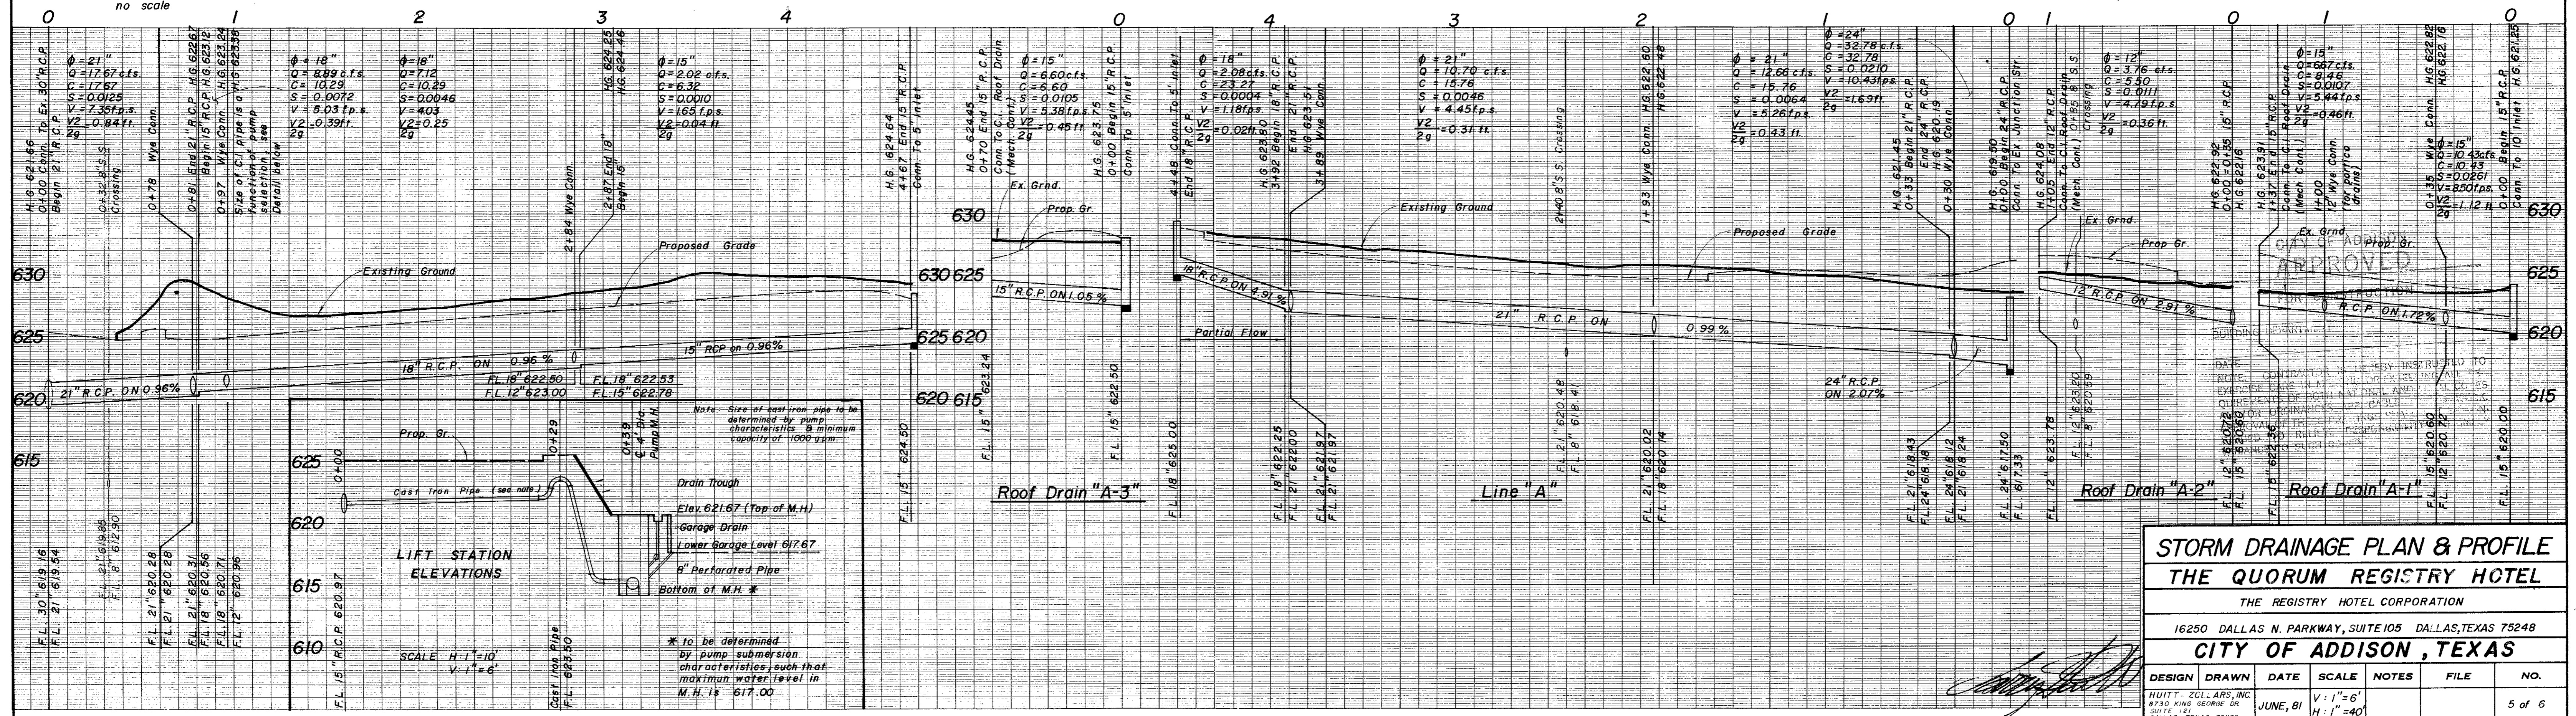

STORM DRAINAGE PLAN & PROFILE
THE QUORUM REGISTRY HOTEL
THE REGISTRY HOTEL CORPORATION
16250 DALLAS N. PARKWAY, SUITE 105 DALLAS, TEXAS 75248
CITY OF ADDISON, TEXAS

DESIGN	DRAWN	DATE	SCALE	NOTES	FILE	NO.
HUTTY	ZOLLARS, INC.	JUNE, 81	V: 1"=6' H: 1"=40'			5 of 6

Project N 2. 81145