



FUTURE SPECTRUM DRIVE


AREA E
50,125 S.F.

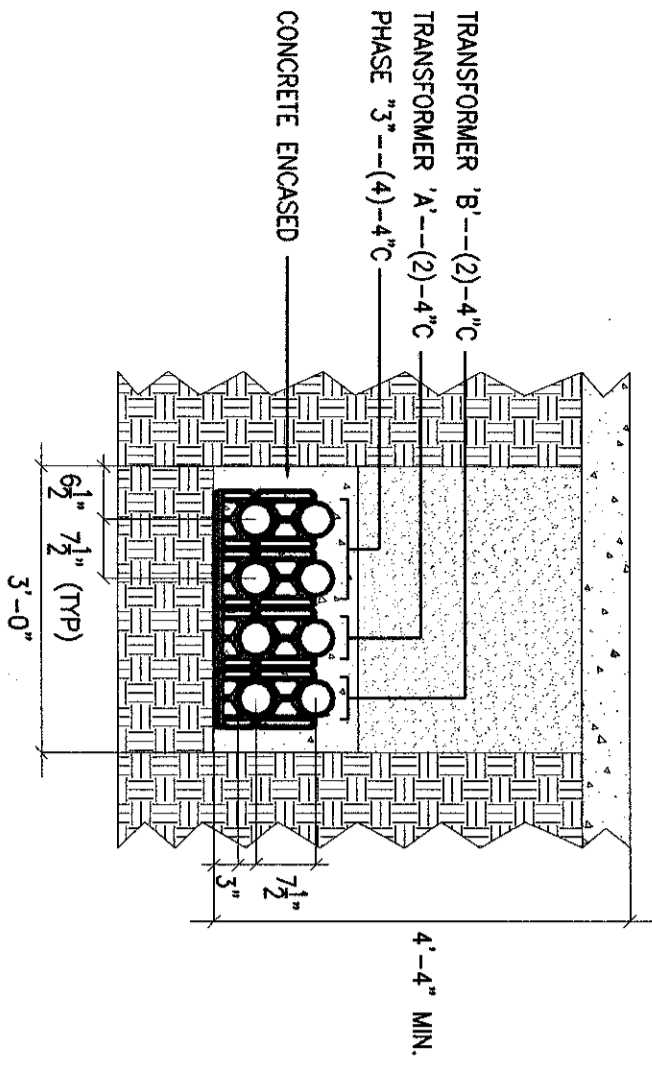

2 SECTION CUT A-A
SCALE: 1/2"=1'-0"
SITUATIONS

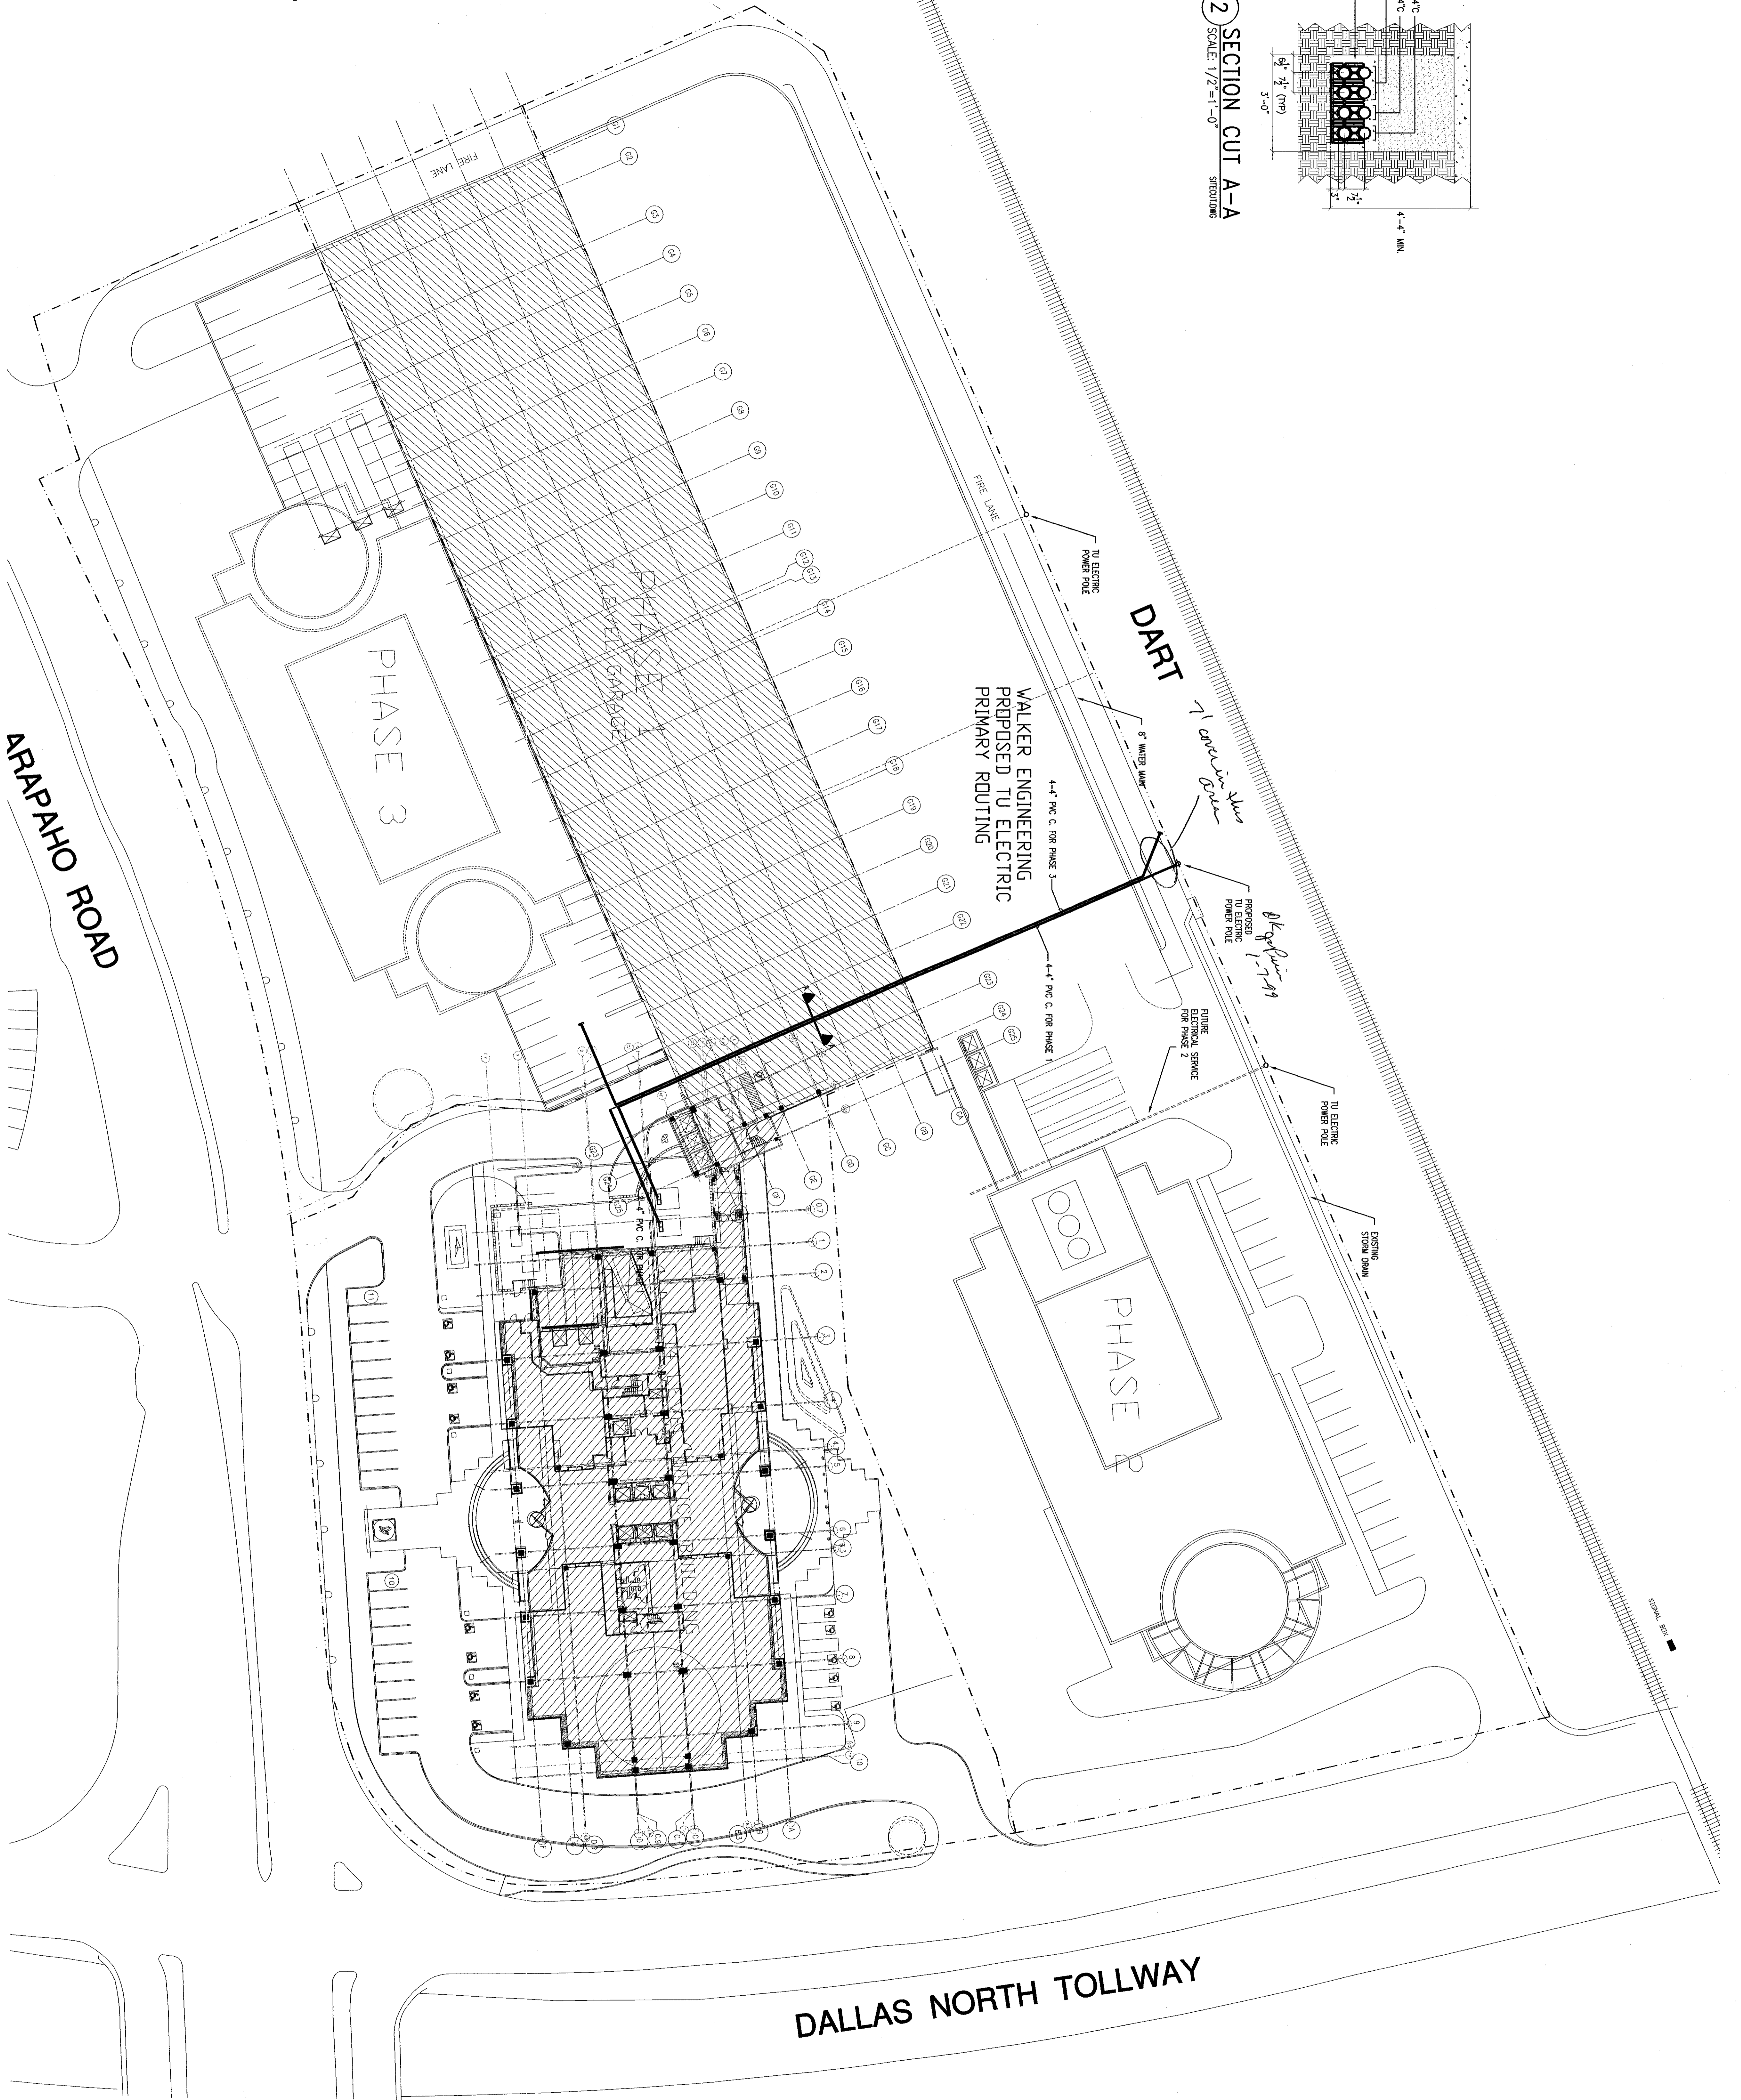

1 ELECTRICAL SITE PLAN
SCALE: 1"=30'
MILLENNIUM

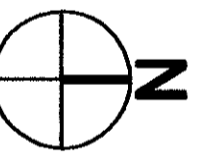

DALLAS NORTH TOLLWAY



WALKER ENGINEERING, INC.
ELECTRICAL CONTRACTORS
DALLAS - FT. WORTH - AUSTIN - SAN ANTONIO - HOUSTON

The information contained on this drawing is the property and trade secret of Walker Engineering, Inc. and may not be reproduced without the express written permission of Walker Engineering, Inc. © Walker Engineering, Inc. 1999

DESIGNER	LAND POWER POLE 1 1/7/99
CHECKED BY	0888
FILE NAME	AS NOTED
DWG NO.	8814
DATE	1/6/99
SCALE	AS NOTED
SHEET NO.	WE2.01