


Hallmark Center Expansion

MBNA
AMERICASM

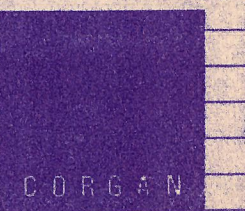


CORGAN ASSOCIATES, INC.

DALLAS
FORT WORTH
MIAMI
NEW YORK

JOB # 295329

ccrd partners

Professional and consulting engineers
DALLAS - HOUSTON
4311 OAK LAWN AVENUE
SUITE 400, LB 11
DALLAS, TEXAS 75219
(214) 521-1664
FAX (214) 521-1664

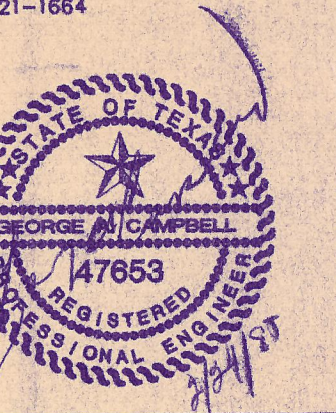


ISSUES

ISSUE NO. 4 FEBRUARY 24, 1997

REVISIONS

KEY PLAN

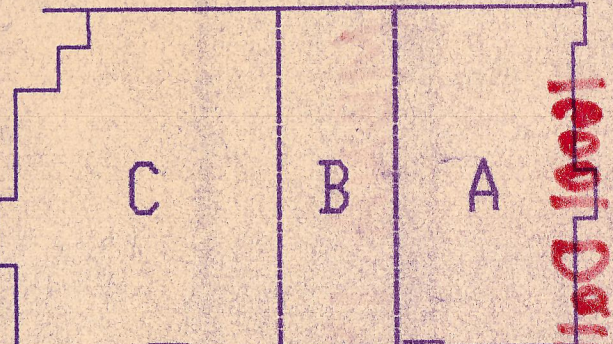


DATE:
PROJECT NUMBER: 95091.00
DRAWN BY:
CHECKED BY:
PLOT FILE:

E12

LEGEND NOTES

- ① 3-4" GRC CONDUITS FOR DATA CABLING. ROUTE CONDUITS UNDERGROUND TO CRAWL SPACE OF NEW BUILDING. ROUTE THROUGH CRAWL SPACE TO EAST LAN ROOM IN BUILDING AS SHOWN.
- ② 3-4" GRC CONDUITS FOR DATA CABLING. ROUTE CONDUITS UNDERGROUND TO CRAWL SPACE OF NEW BUILDING. ROUTE THROUGH CRAWL SPACE TO WEST LAN ROOM IN BUILDING AS SHOWN.
- ③ 3-4" GRC CONDUITS TO SOUTHWESTERN BELL MANHOLE.

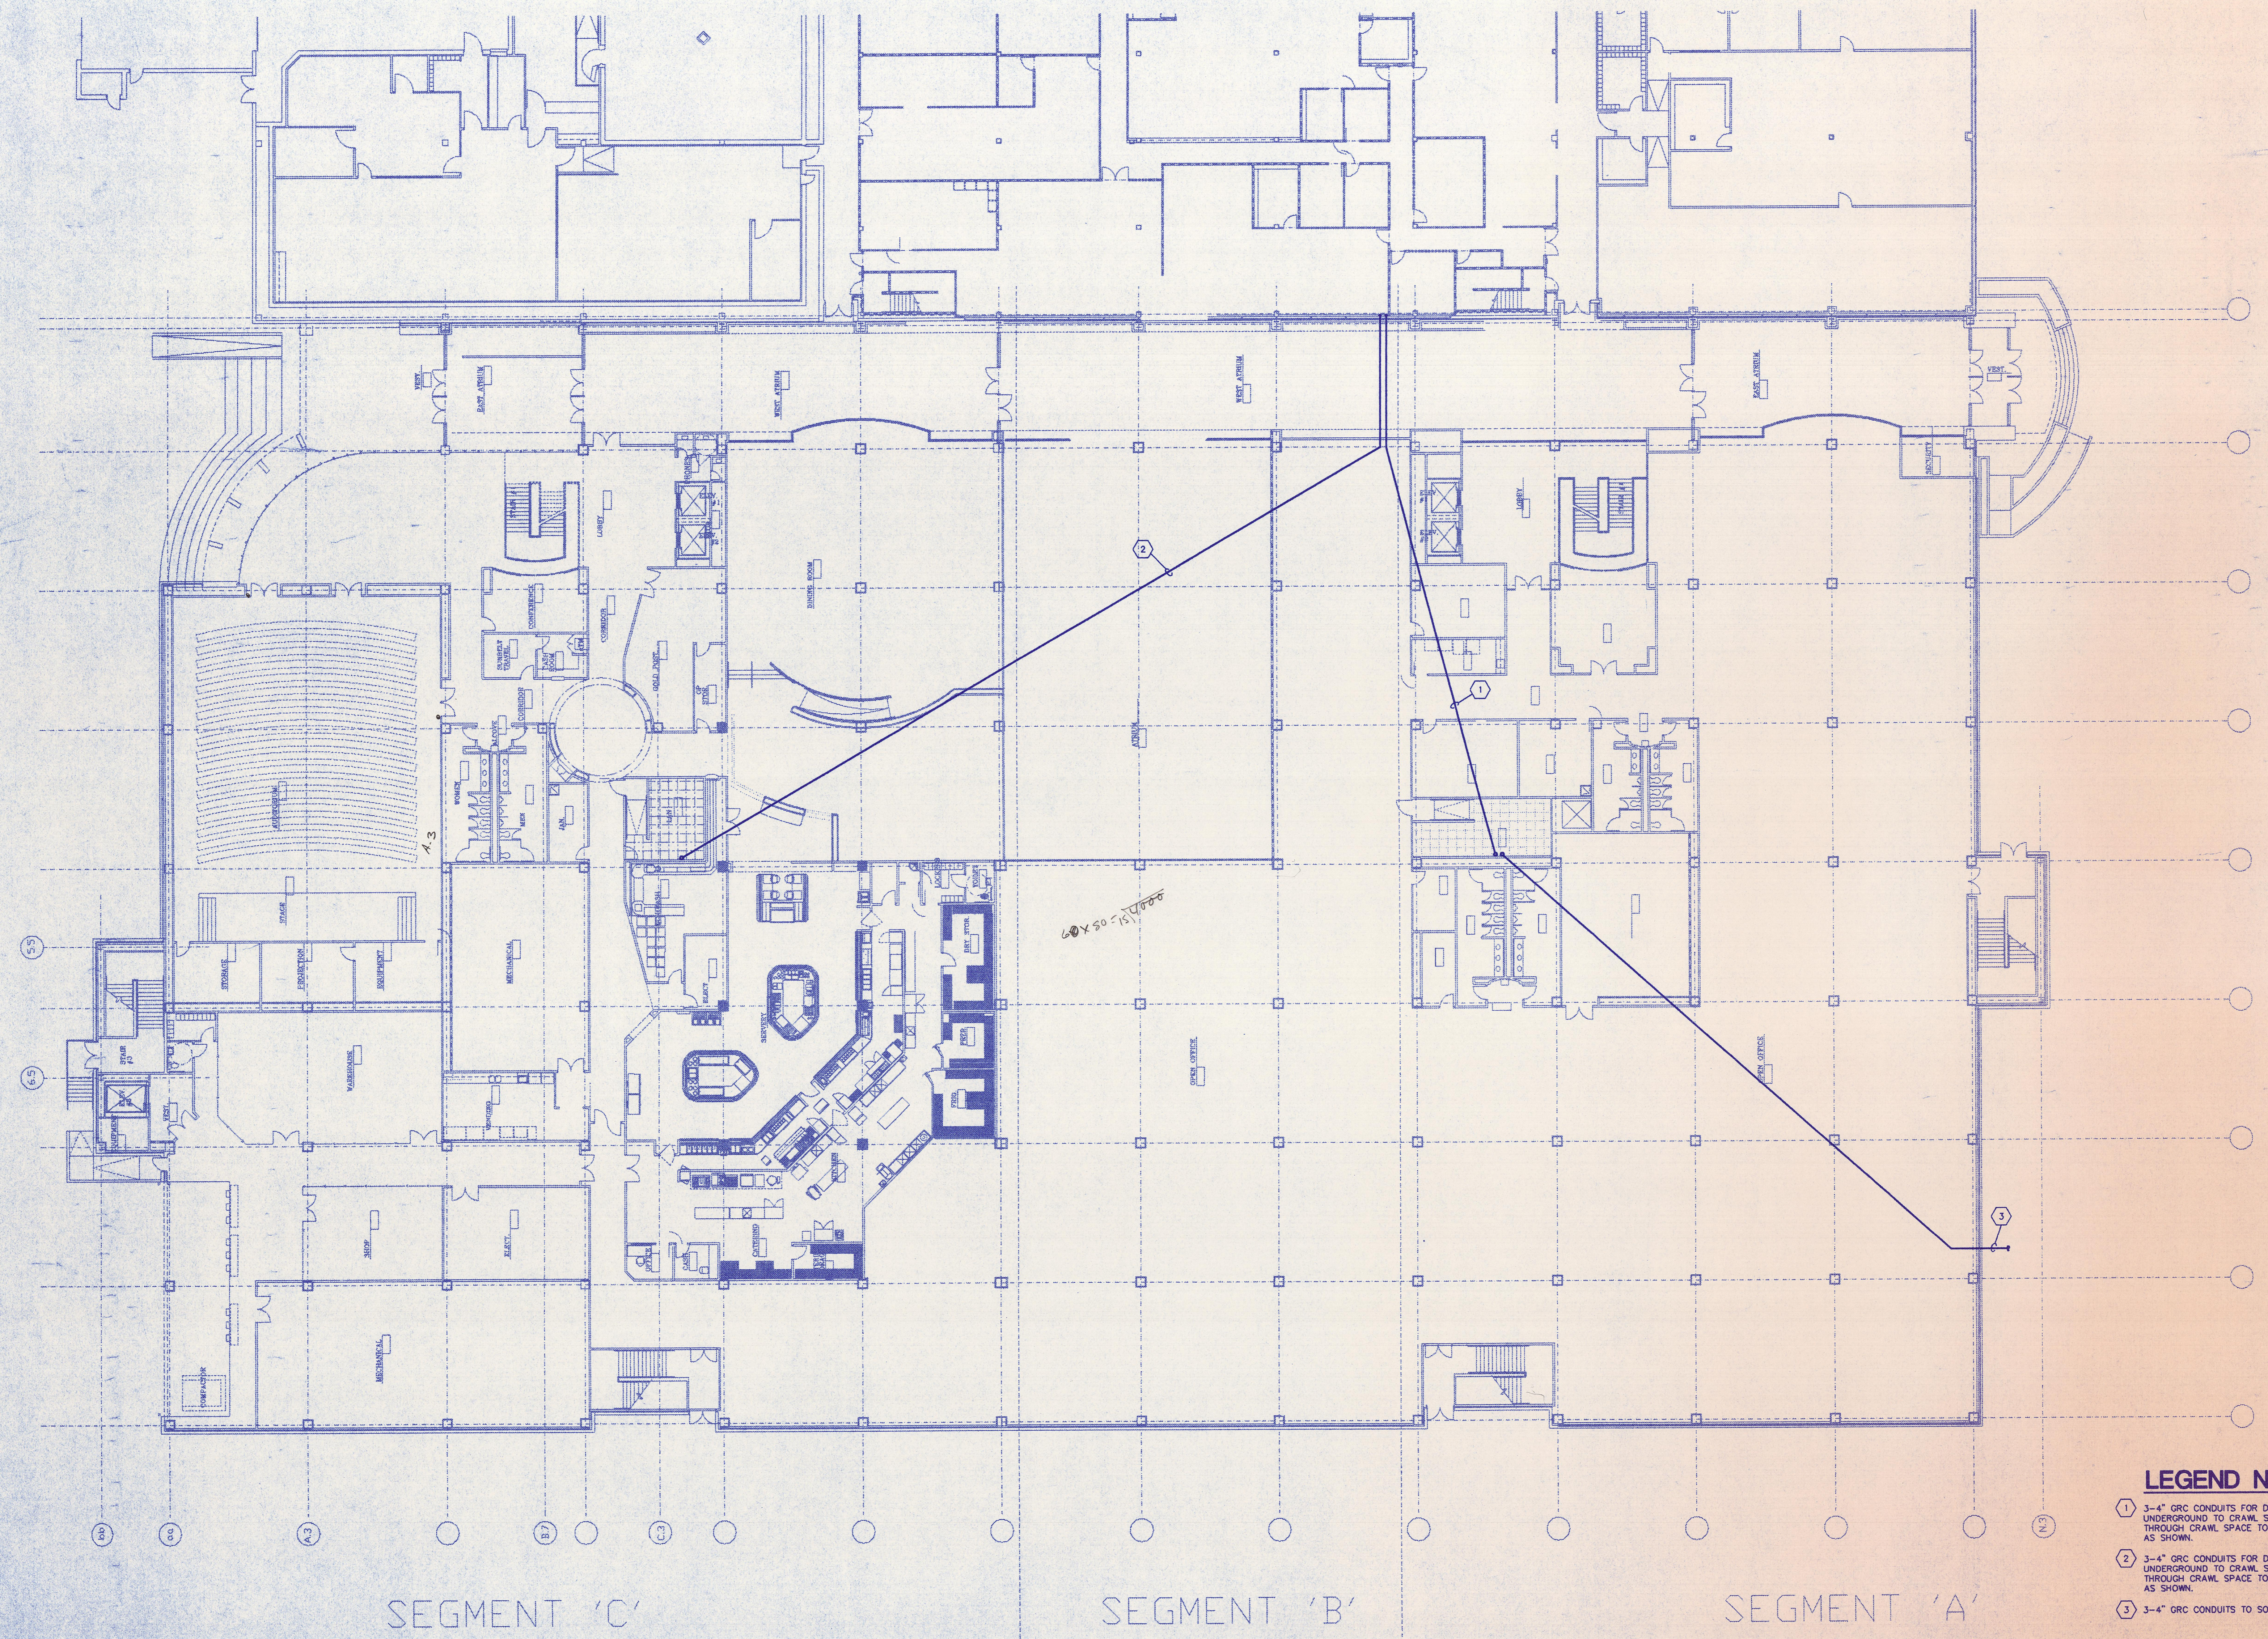

SEGMENT 'C'

SEGMENT 'B'

SEGMENT 'A'

01 UNDERFLOOR PLAN - FIRST FLOOR ELECTRICAL

SCALE: 1/16" = 1'-0"

FILE: F:\CAD\95\MBNA\295329-1.DWG DTC
PLOTED: 02-24-97 13:00