

RESERVOIR

MATCHLINE A

PUMP ROOM


CONTROL BUILDING

NOTES:
1. WALKS TO HAVE A 1% CROSS-SLOPE TO DRAIN TO LOW SIDE OF WALK.
2. REF. 1244 FOR GENERAL NOTES AND LEGEND

SWITCHGEAR BUILDING


METER VAULT

ST. LOUIS & SOUTHWESTERN R.R.

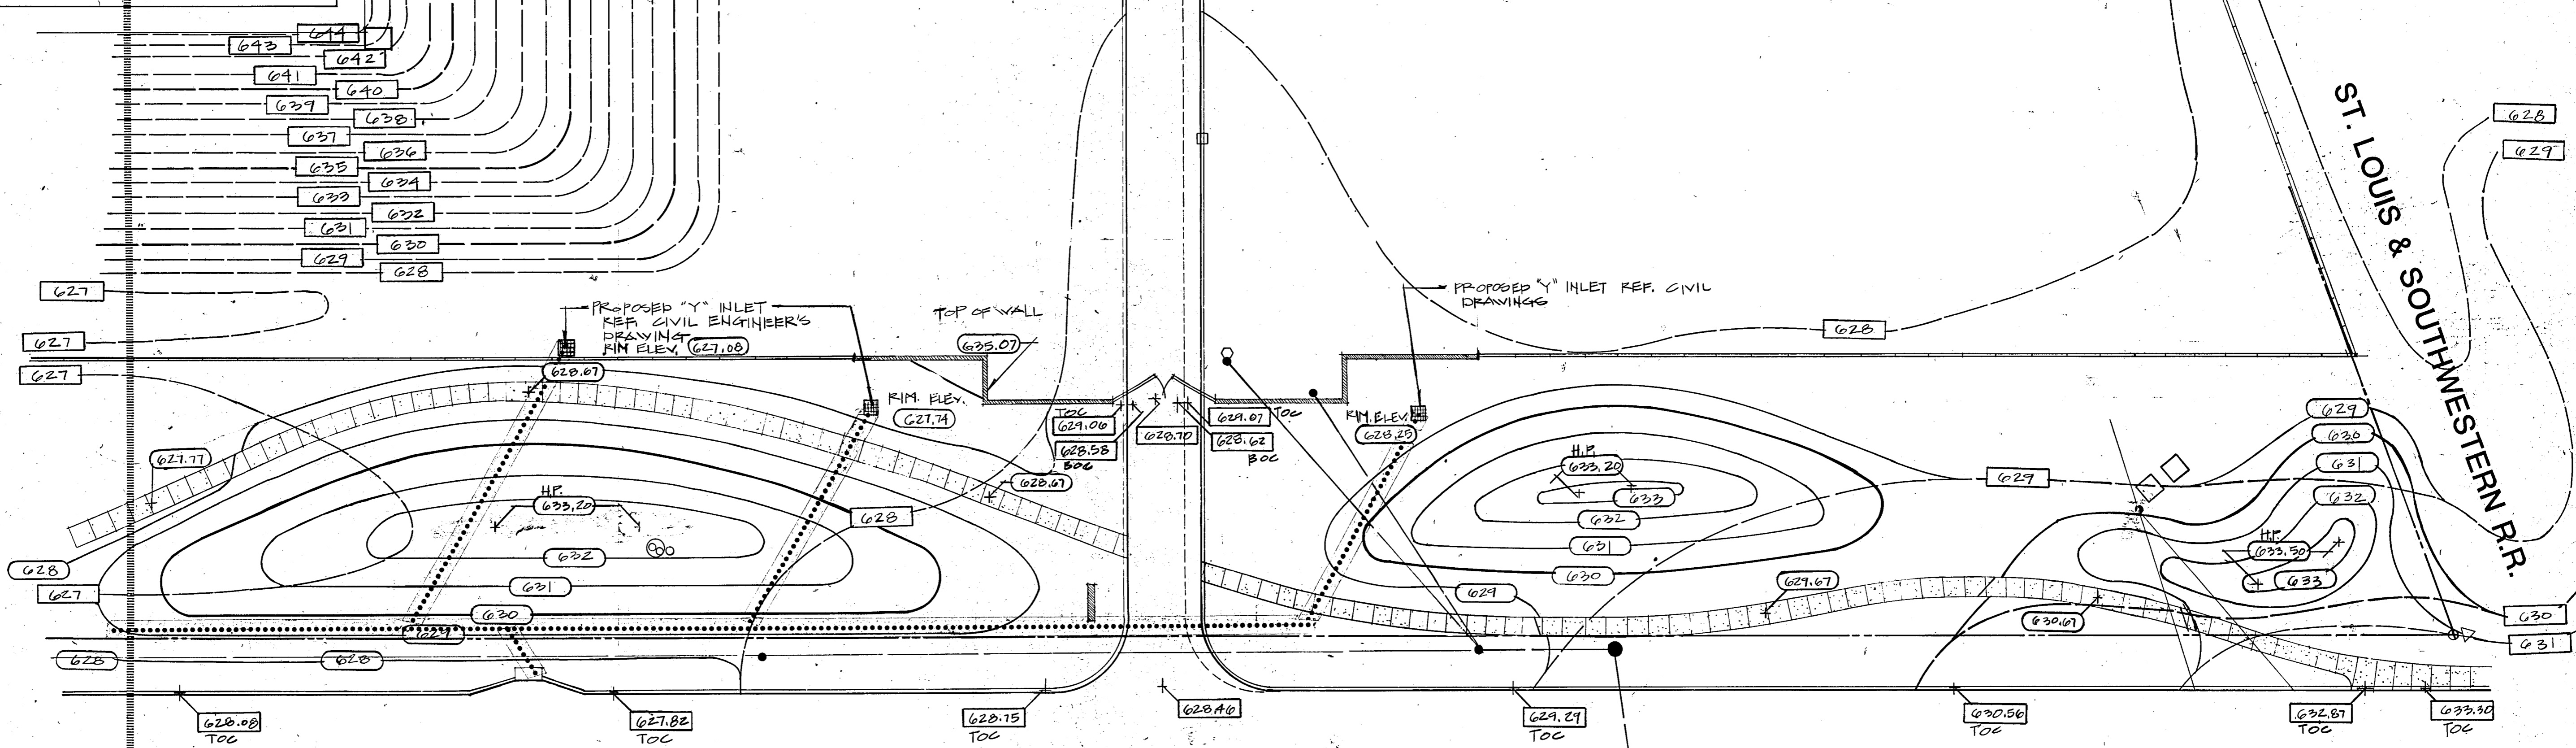

BELT LINE ROAD

GRADING PLAN
SCALE: 1"=20'-0"

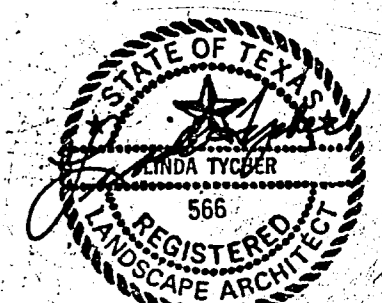

14
44

NO.	DATE	REVISION	APPROVED
BELTWOOD RESERVOIR EXPANSION			
GRADING PLAN			
DALLAS WATER UTILITIES CITY OF DALLAS, TEXAS			
Turner Collier & Braden Inc.			
DESIGN	CONTRACT NO.	89-79	SHEET NO.
DRAWN	FILE NO.	630 Q700 F	14
CHECKED			44
DATE			

LINDA TYLER landscape architecture
11111 N. CENTRAL EXPRESSWAY SUITE 101
DALLAS, TEXAS 75244 PHONE 754-1214