


THIS DRAWING PRODUCED ON THE SOUTHWEST REGION MICROSTATION SYSTEM

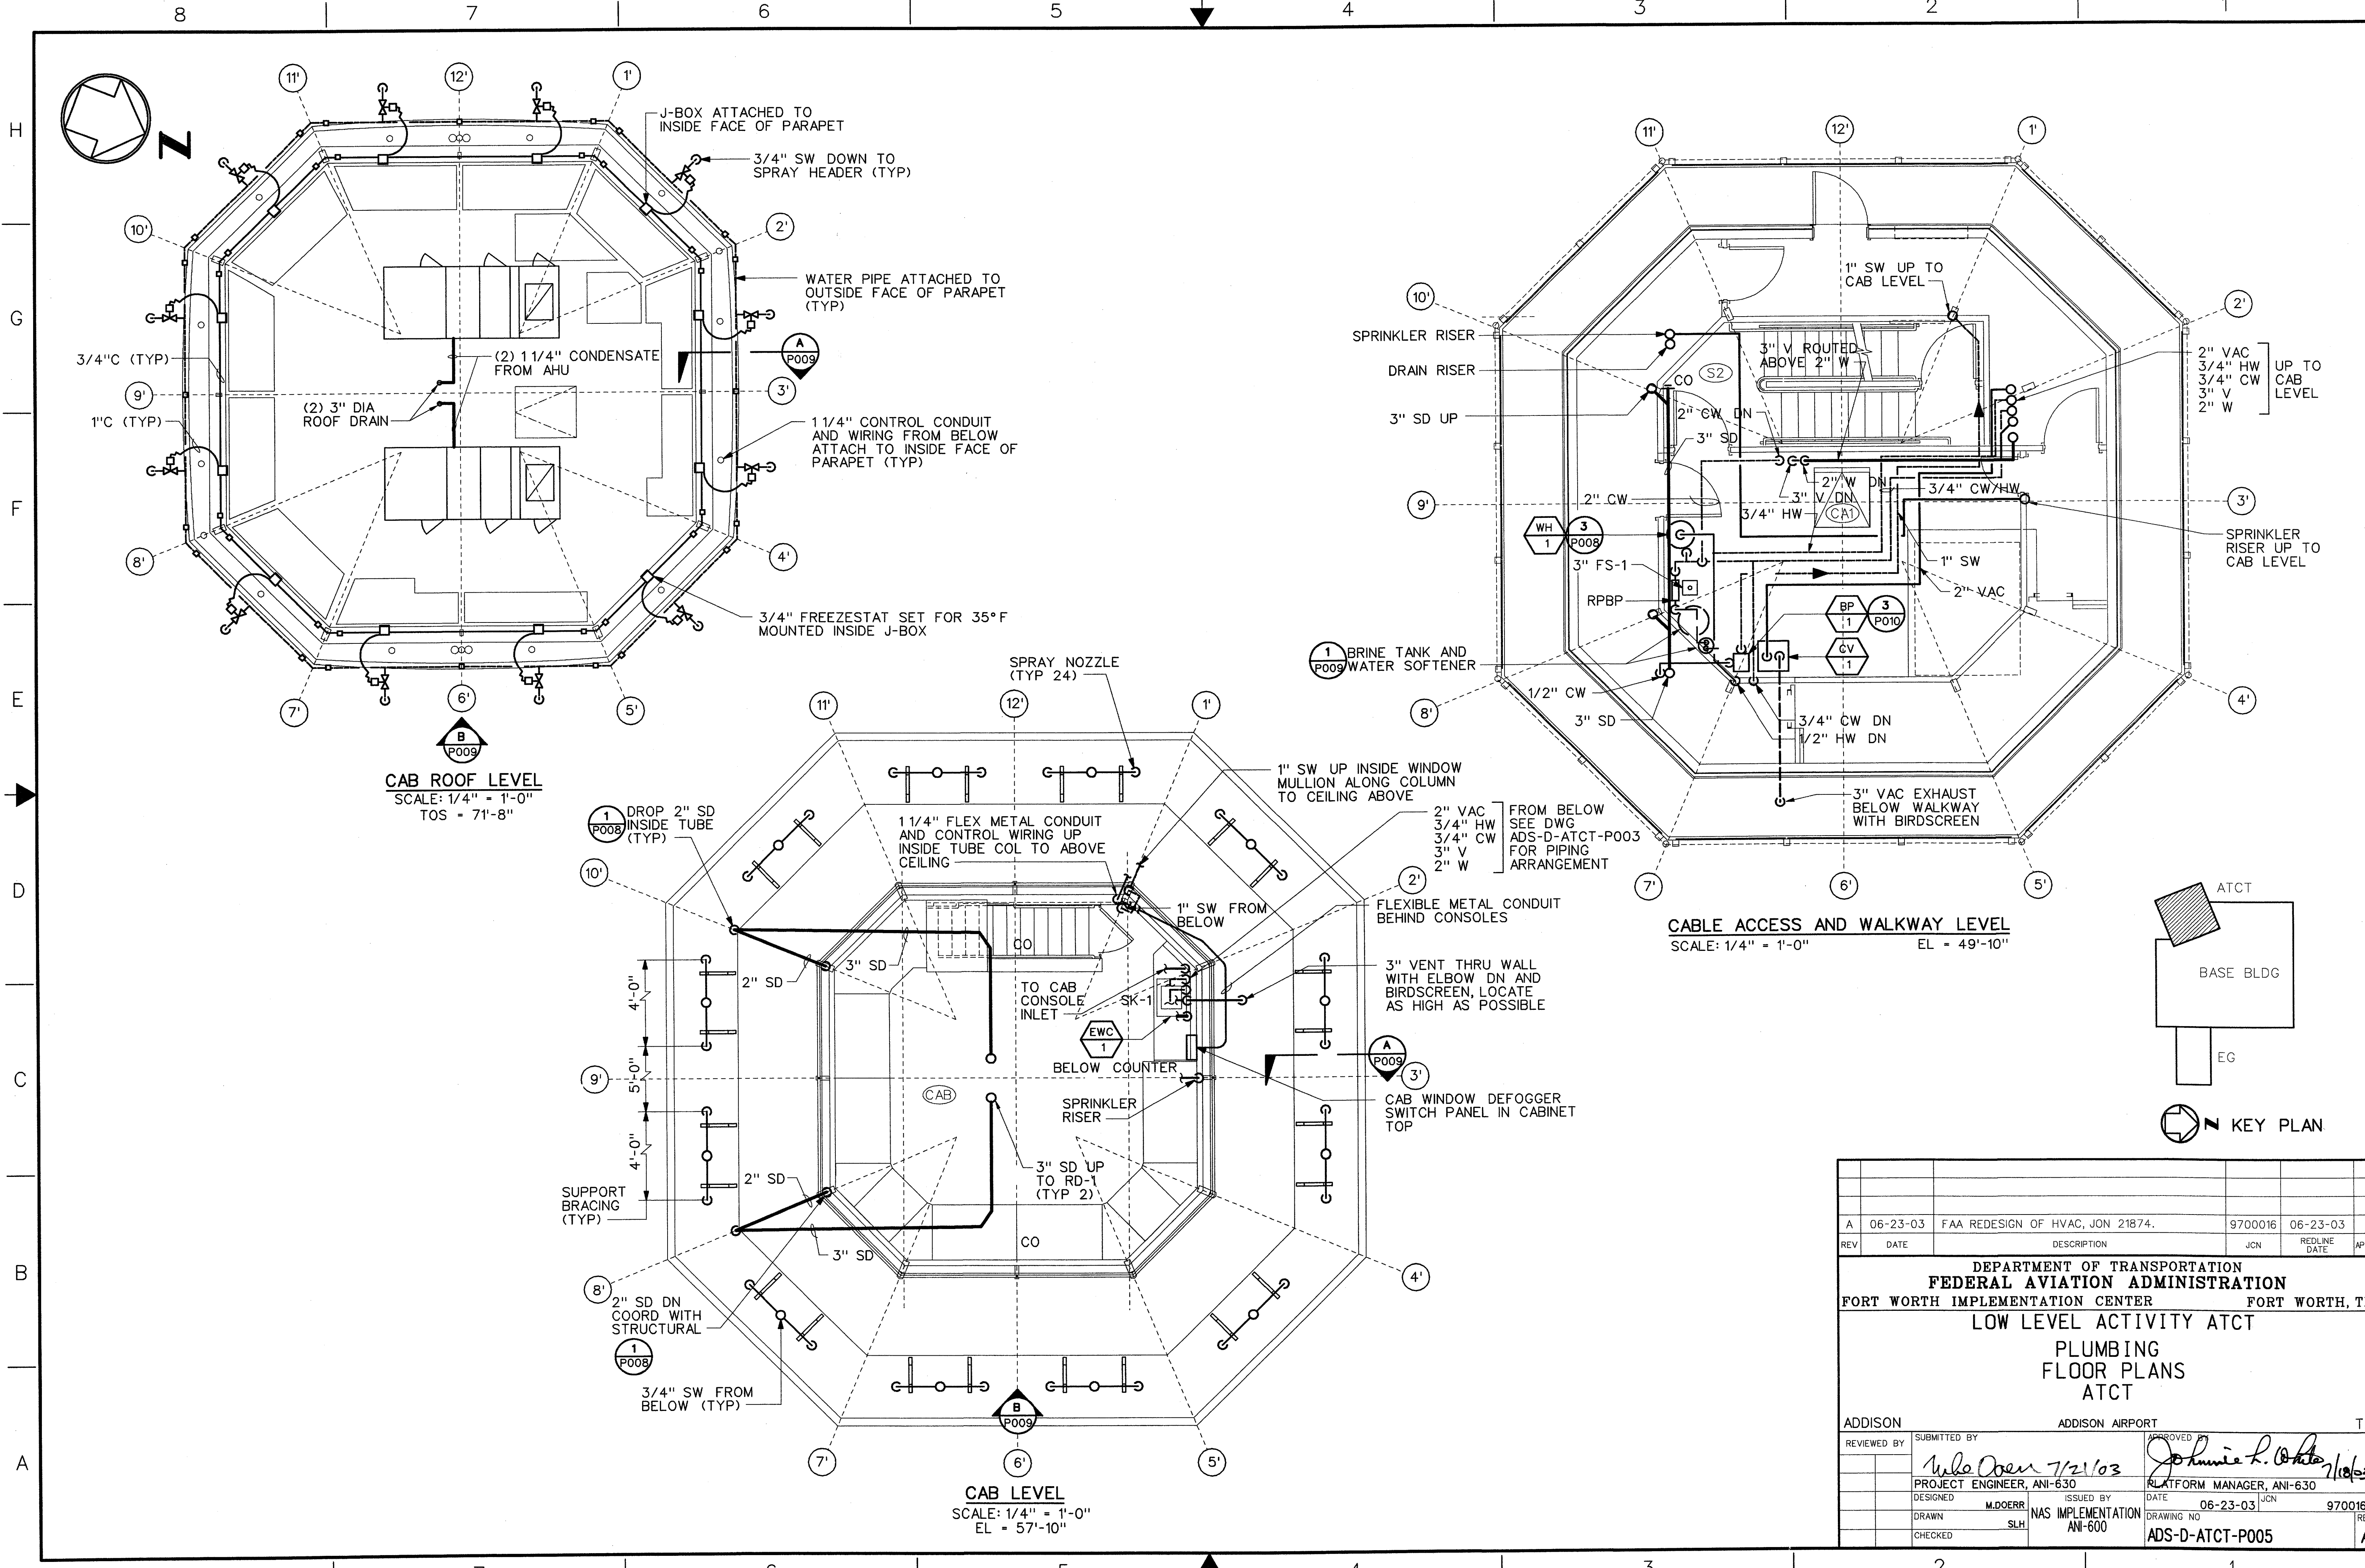

REV	DATE	DESCRIPTION	JCN	REDLINE DATE	APVD
A	06-23-03	FAA REDESIGN OF HVAC, JON 21874.	9700016	06-23-03	
DEPARTMENT OF TRANSPORTATION FEDERAL AVIATION ADMINISTRATION FORT WORTH IMPLEMENTATION CENTER FORT WORTH, TX LOW LEVEL ACTIVITY ATCT PLUMBING FLOOR PLANS ATCT					
ADDISON		ADDISON AIRPORT		TX	
REVIEWED BY	SUBMITTED BY	APPROVED			
	<i>Mike Owen</i>	<i>Johnnie L. White</i>			
DESIGNED	PROJECT ENGINEER, ANI-630	DATE	PLATFORM MANAGER, ANI-630		
DRAWN	M.DDERR	ISSUED BY	DATE	06-23-03	JCN
CHECKED	SLH	NAS IMPLEMENTATION ANI-600	DRAWING NO	9700164	REV
			ADS-D-ATCT-P005		A

m:\add\mach\active\add-d-act-p005-a.dgn
07/17/2003 04:54:27 PM kasm