

FLOOR PLAN  
SCALE: 1/8" = 1'-0"

ROOM SCHEDULE	
RM NO.	ROOM NAME
101	VESTIBULE
102	LOBBY
103	RECEPTION
104	AT OFFICE
105	QATS
106	TOWER MANAGER
107	MAIL/FAX/COPY ROOM
108	BREAKROOM
109	JAN CLOSET
110	CORRIDOR
111	AF OFFICE
112	RMM/LIS/MMS ROOM
113	ELECTRONIC ROOM
114	TELCO
115	MATERIAL STORAGE
116	AT/AR/CBI TRAINING RM
117	AT/AF STORAGE
118	CORRIDOR
119	ESU SHOP
120	MEN'S TOILET
121	WOMEN'S TOILET
122	LINK
123	AT/AF CONFERENCE RM
124	MECH/ELEC ROOM
125	TOILET/SHOWER
126	E/G ROOM
127	WORKROOM
128	UPS
129	CABLE ACCESS ROOM



**GENERAL NOTES:**

- SEE DETAILS 5 AND 6, DRAWING E66 FOR VIDEO AND SECURITY SYSTEM BLOCK DIAGRAM
- SEE DRAWING E011 AND E012 FOR FIRE ALARM AND SECURITY SYSTEMS IN TOWER.

**SPECIAL NOTES:**

- PROVIDE VENTED NEMA 1 ENCLOSURE, FOR POWER SUPPLY, ABOVE CEILING WITH (2) 100 VA, 120-24 VAC, TRANSFORMERS (ONE FOR CAMERA HOUSING, ONE FOR CAMERA). PROVIDE PRIMARY FUSE (2 1/4 AMP) AND SECONDARY FUSE (6 AMP) FOR EACH TRANSFORMER. PROVIDE LITTLEFUSE TYPE FLA FUSES WITH L60030M FUSE BLOCKS, DISCONNECT SWITCH, AND PILOT LIGHT. SEE 1 E68 2 E68
- 3/4" C-4 NO.12, NO.12 G.
- MOUNT AT WALKWAY LEVEL. SEE 2 A07

(1) TWISTED SHIELDED PR NO.16 AWG IN 1/2" C (TYP)  
DEMARC CABINETS 5 E61

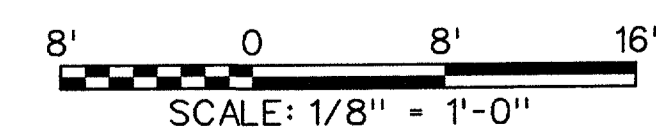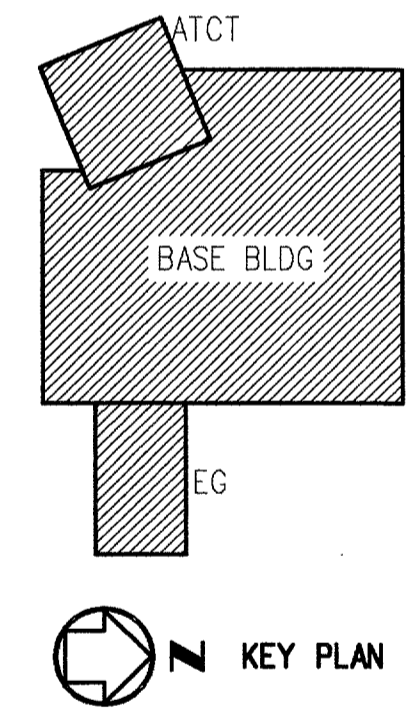

A	06-23-03	FAA REDESIGN OF HVAC, JON 21874.	9700164	06-23-03	
REV	DATE	DESCRIPTION	JCN	REDLINE DATE	APVD
DEPARTMENT OF TRANSPORTATION <b>FEDERAL AVIATION ADMINISTRATION</b> FORT WORTH IMPLEMENTATION CENTER FORT WORTH, TX LOW ACTIVITY LEVEL ATCT FIRE ALARM AND SECURITY PLAN BASE-EG BUILDING					
ADDISON	SUBMITTED BY		ADDISON AIRPORT		TX
REVIEWED BY	<i>M.A. Lebeck</i> 7/18/03		APPROVED BY		<i>Johnnie L. White</i> 7/18/03
DESIGNED	M. WAHEED	ISSUED BY	DATE	06-23-03	JCN
DRAWN	KS	NAS IMPLEMENTATION ANI-600	DRAWING NO	9700164	REV
CHECKED			ADS-D-ATCT-E015		A