




**TOP INTERMEDIATE LEVEL**  
1/4" = 1'-0" EL = 30'-0"

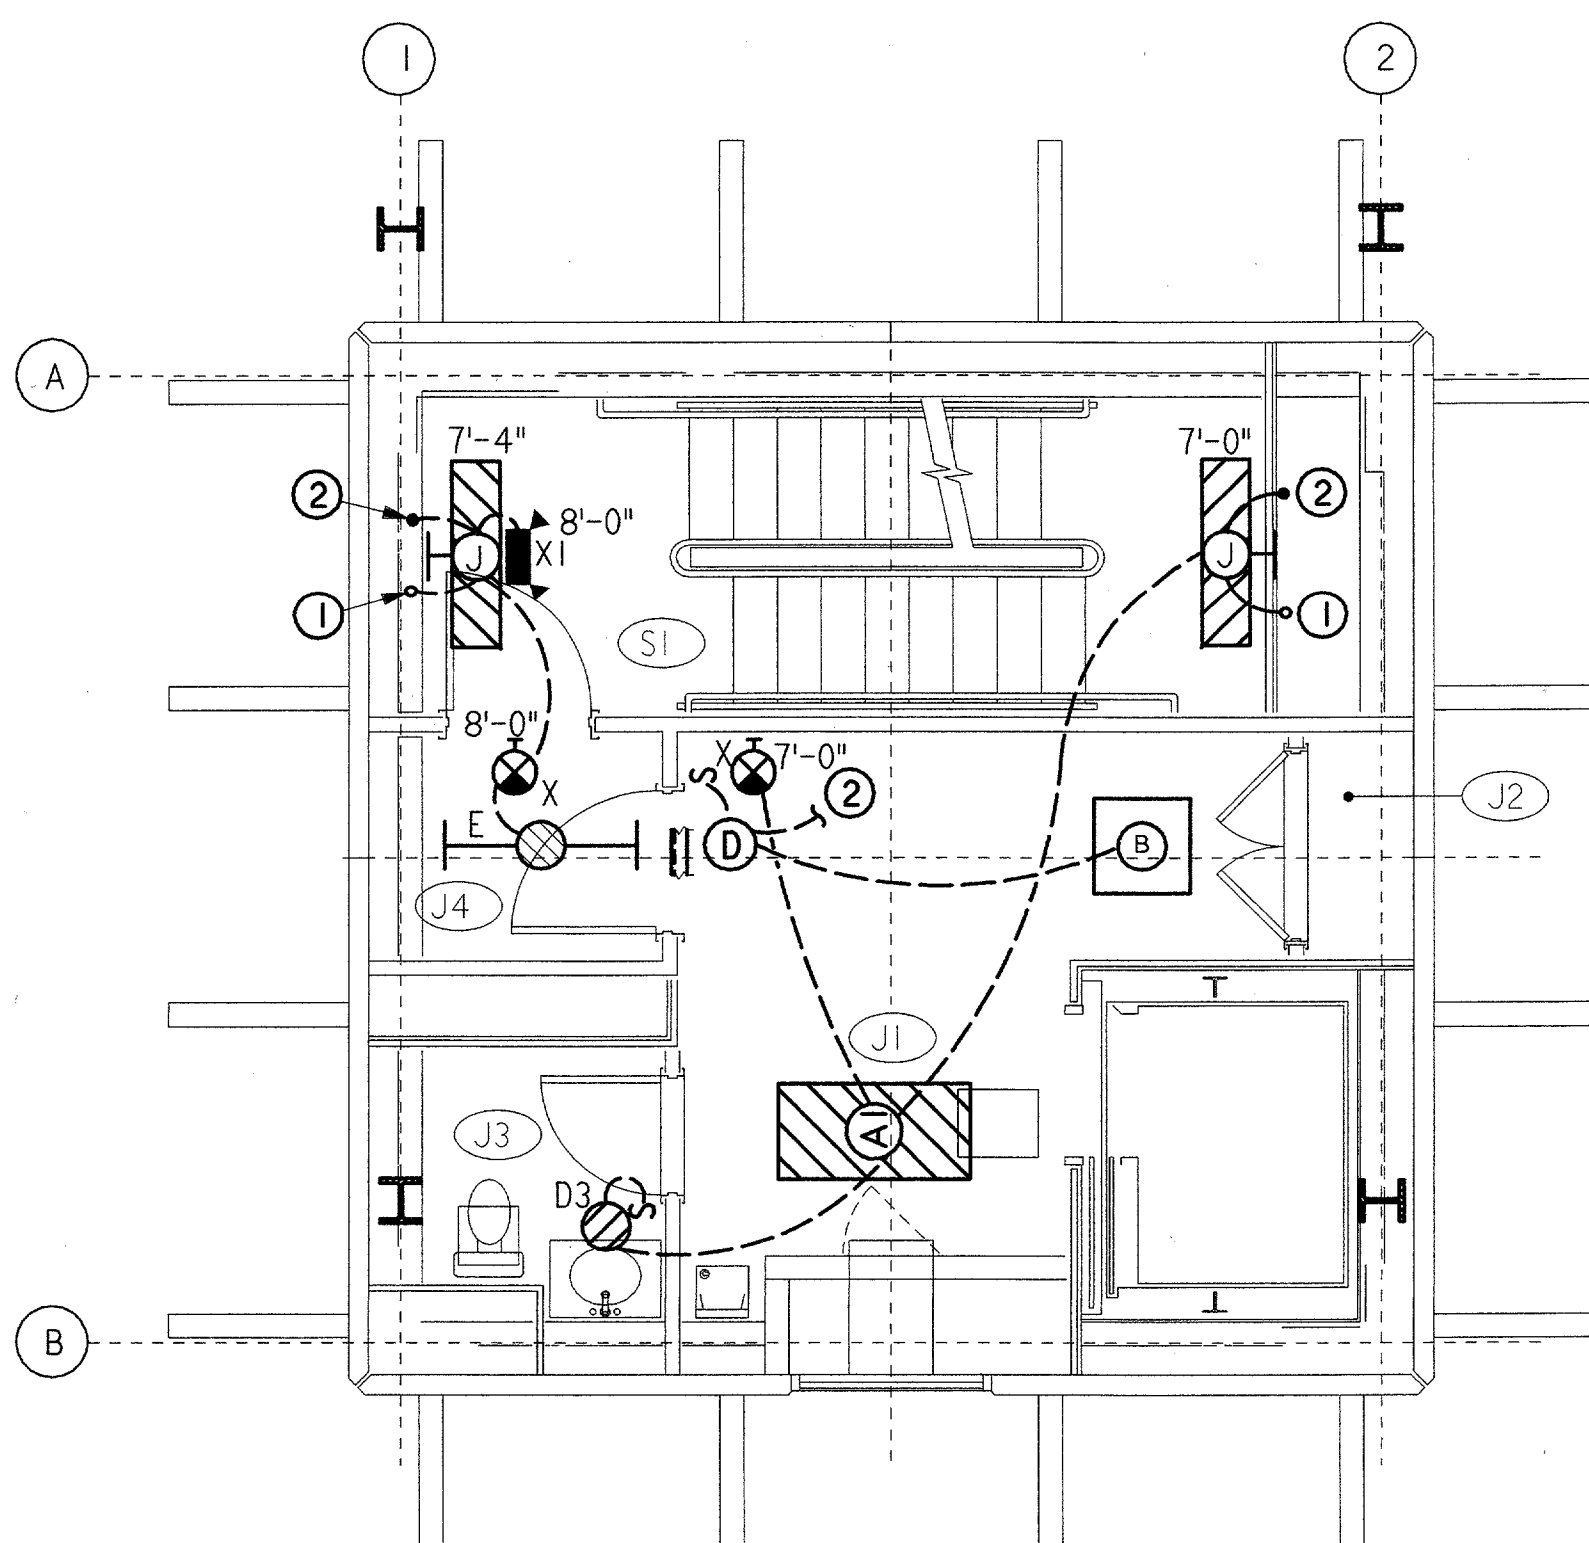


**JUNCTION LEVEL**  
1/4" = 1'-0" EL = 40'-0"

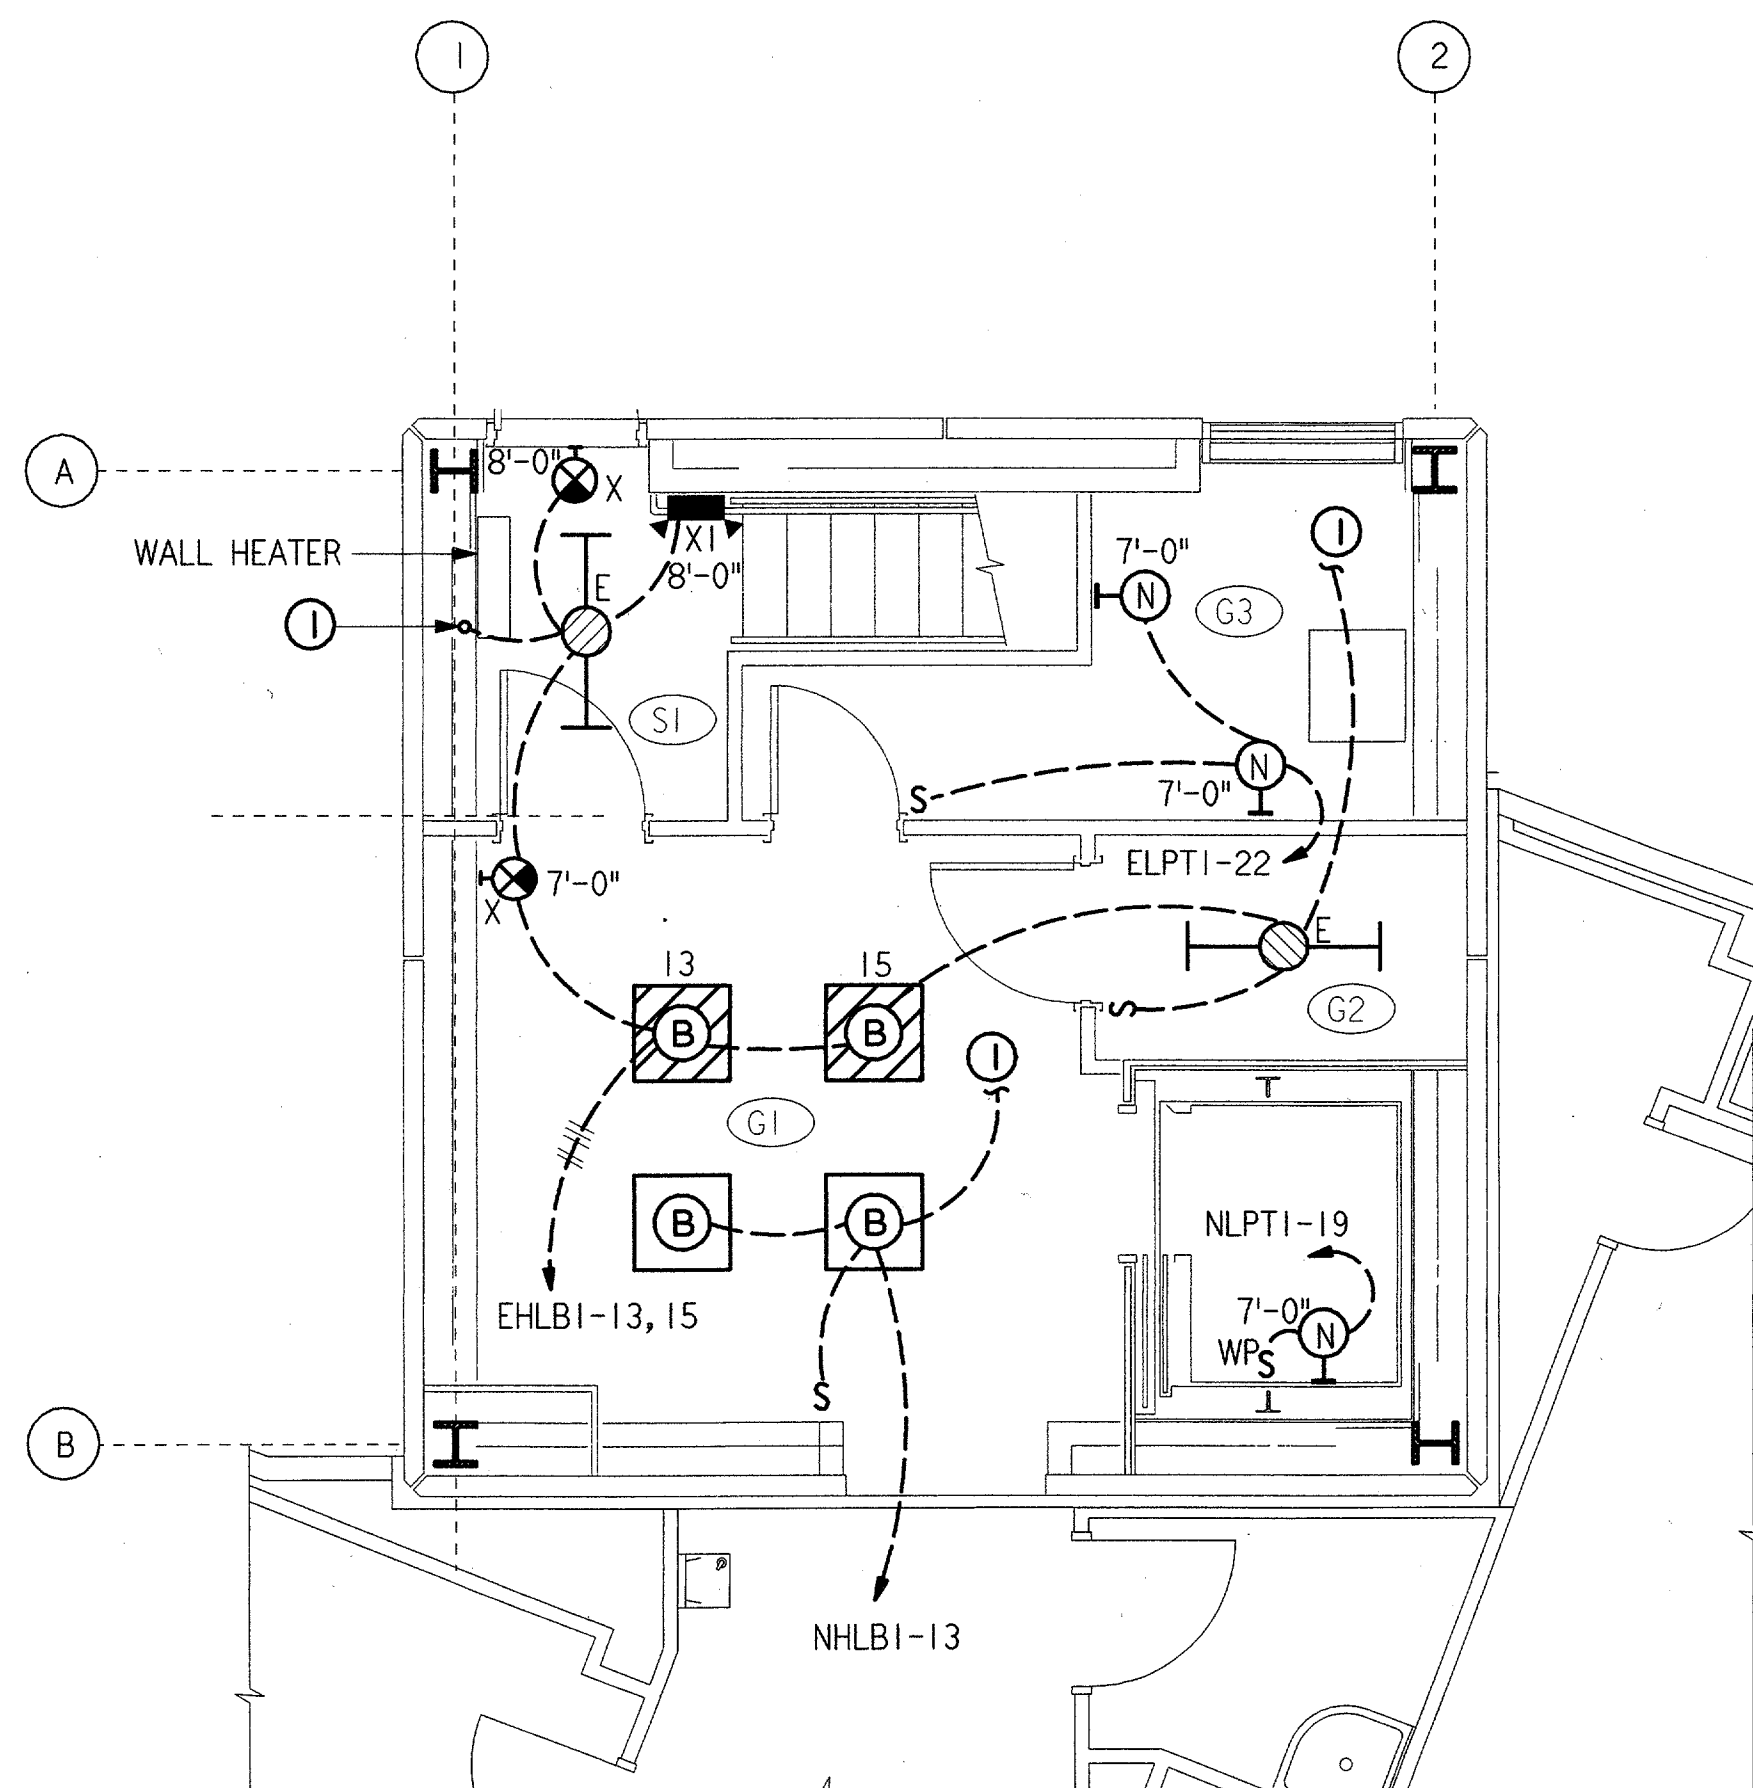

**GROUND LEVEL**  
1/4" = 1'-0" EL = 0'-0"

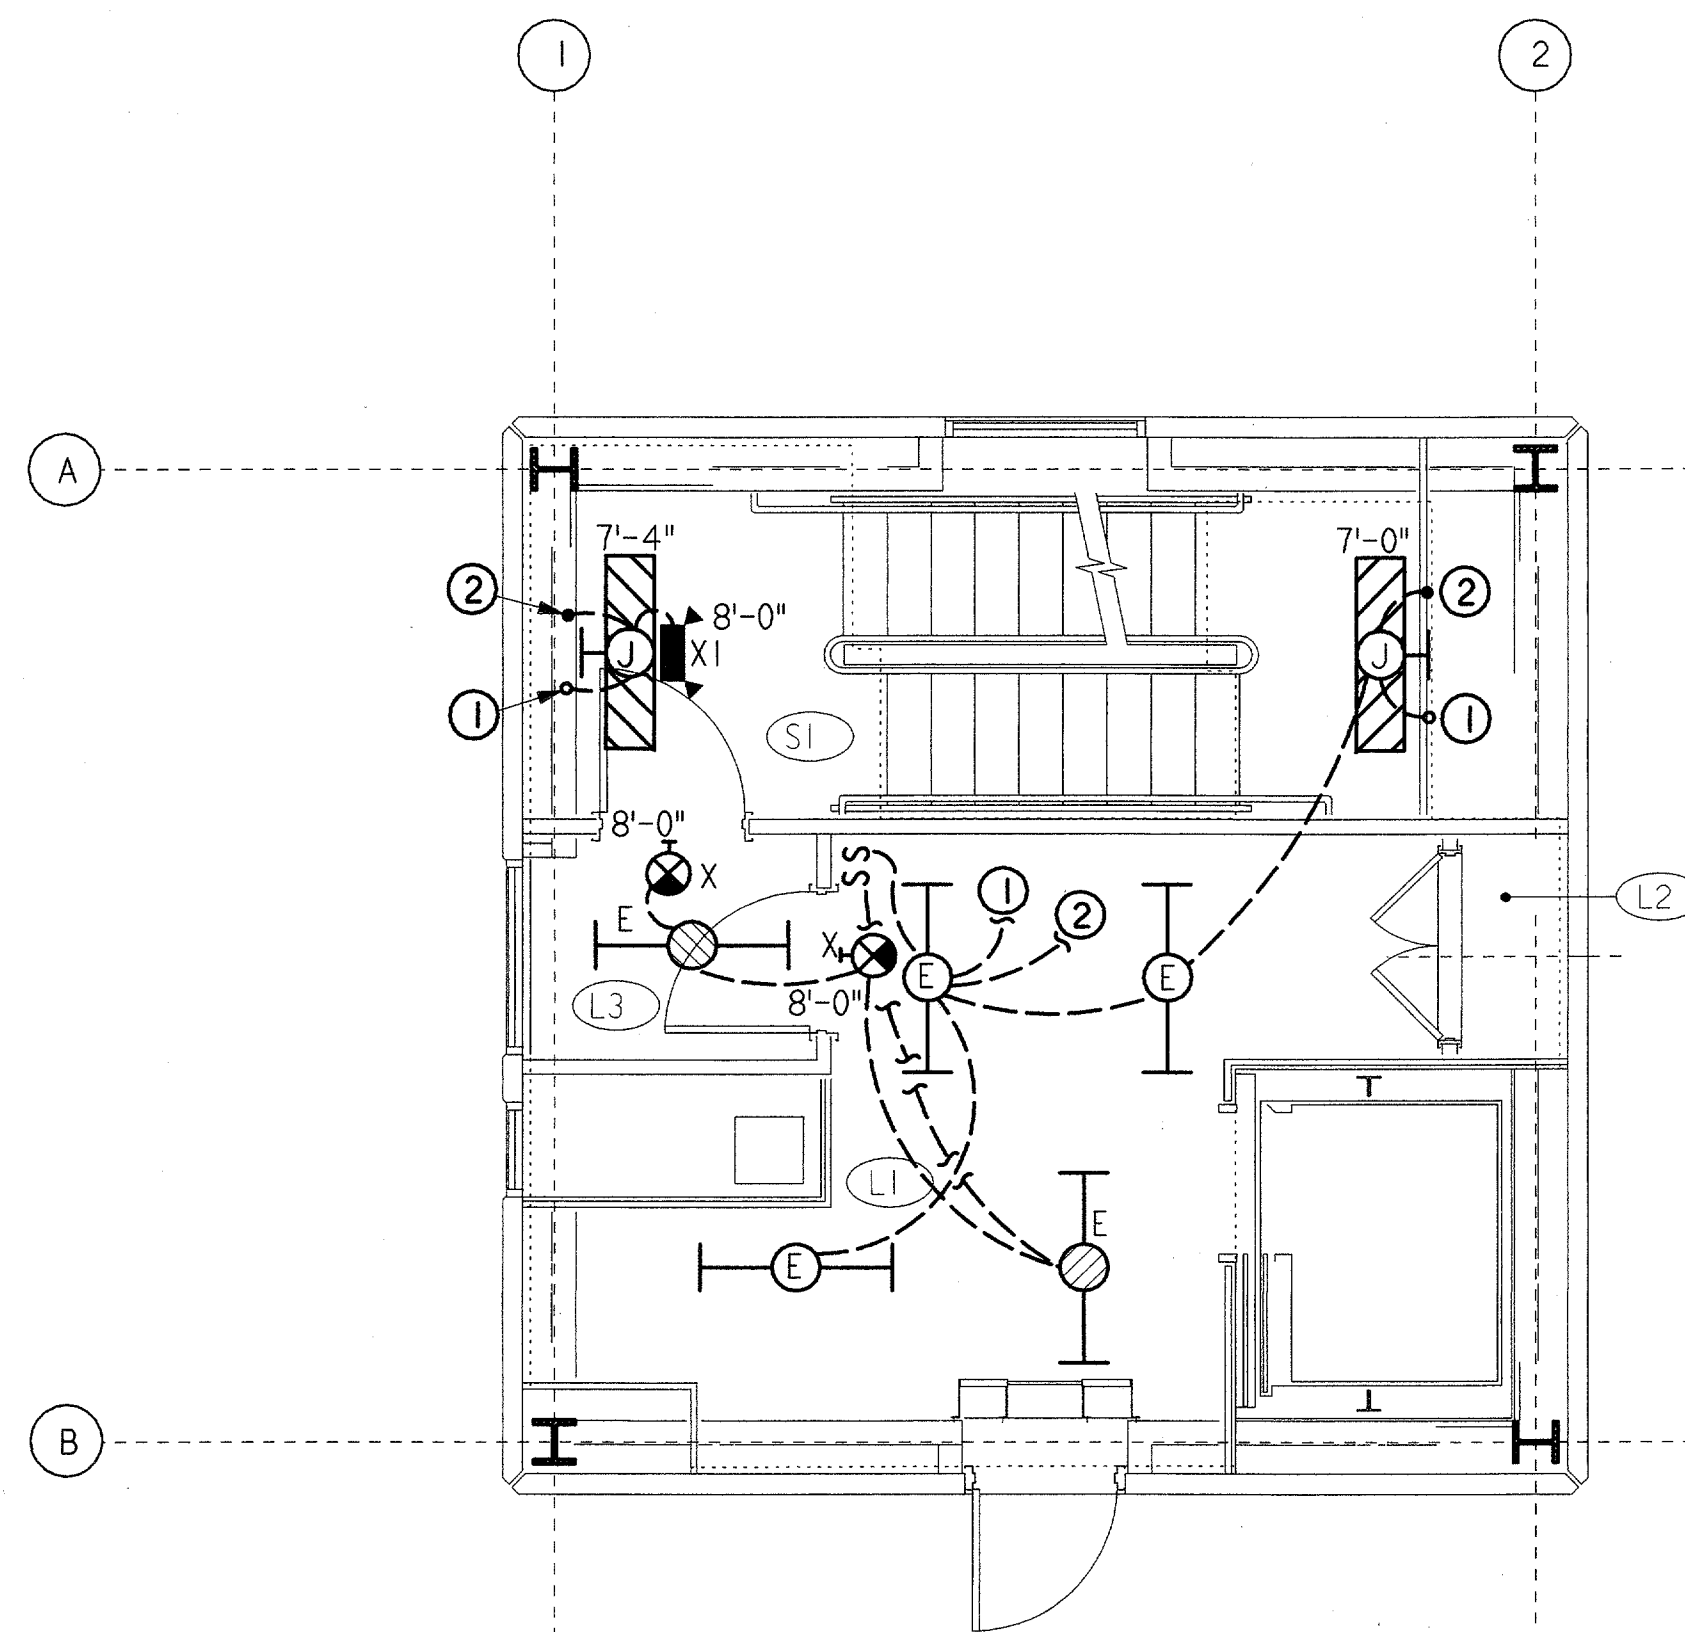

 
**LOWER INTERMEDIATE LEVEL**  
1/4" = 1'-0" EL = 10'-0"




ROOM SCHEDULE	
RM NO	ROOM NAME
G1	LOBBY
G2	ELEVATOR MACHINE ROOM
G3	STAIR PRESSURIZATION
L1	UNASSIGNED
L2	CABLE CHASE
L3	VESTIBULE
M1	ELECTRICAL EQUIPMENT
M2	CABLE CHASE
M3	VESTIBULE
T1	ELECTRONIC EQUIPMENT
T2	CABLE CHASE
T3	VESTIBULE
J1	CORRIDOR
J2	CABLE CHASE
J3	WOMEN'S RESTROOM
J4	VESTIBULE
SI	STAIR

**SPECIAL NOTES:**

- ① TO SIMILAR FIXTURE ABOVE.
- ② TO SIMILAR FIXTURE BELOW.
- ③ SUSPEND BENEATH HVAC UNIT.

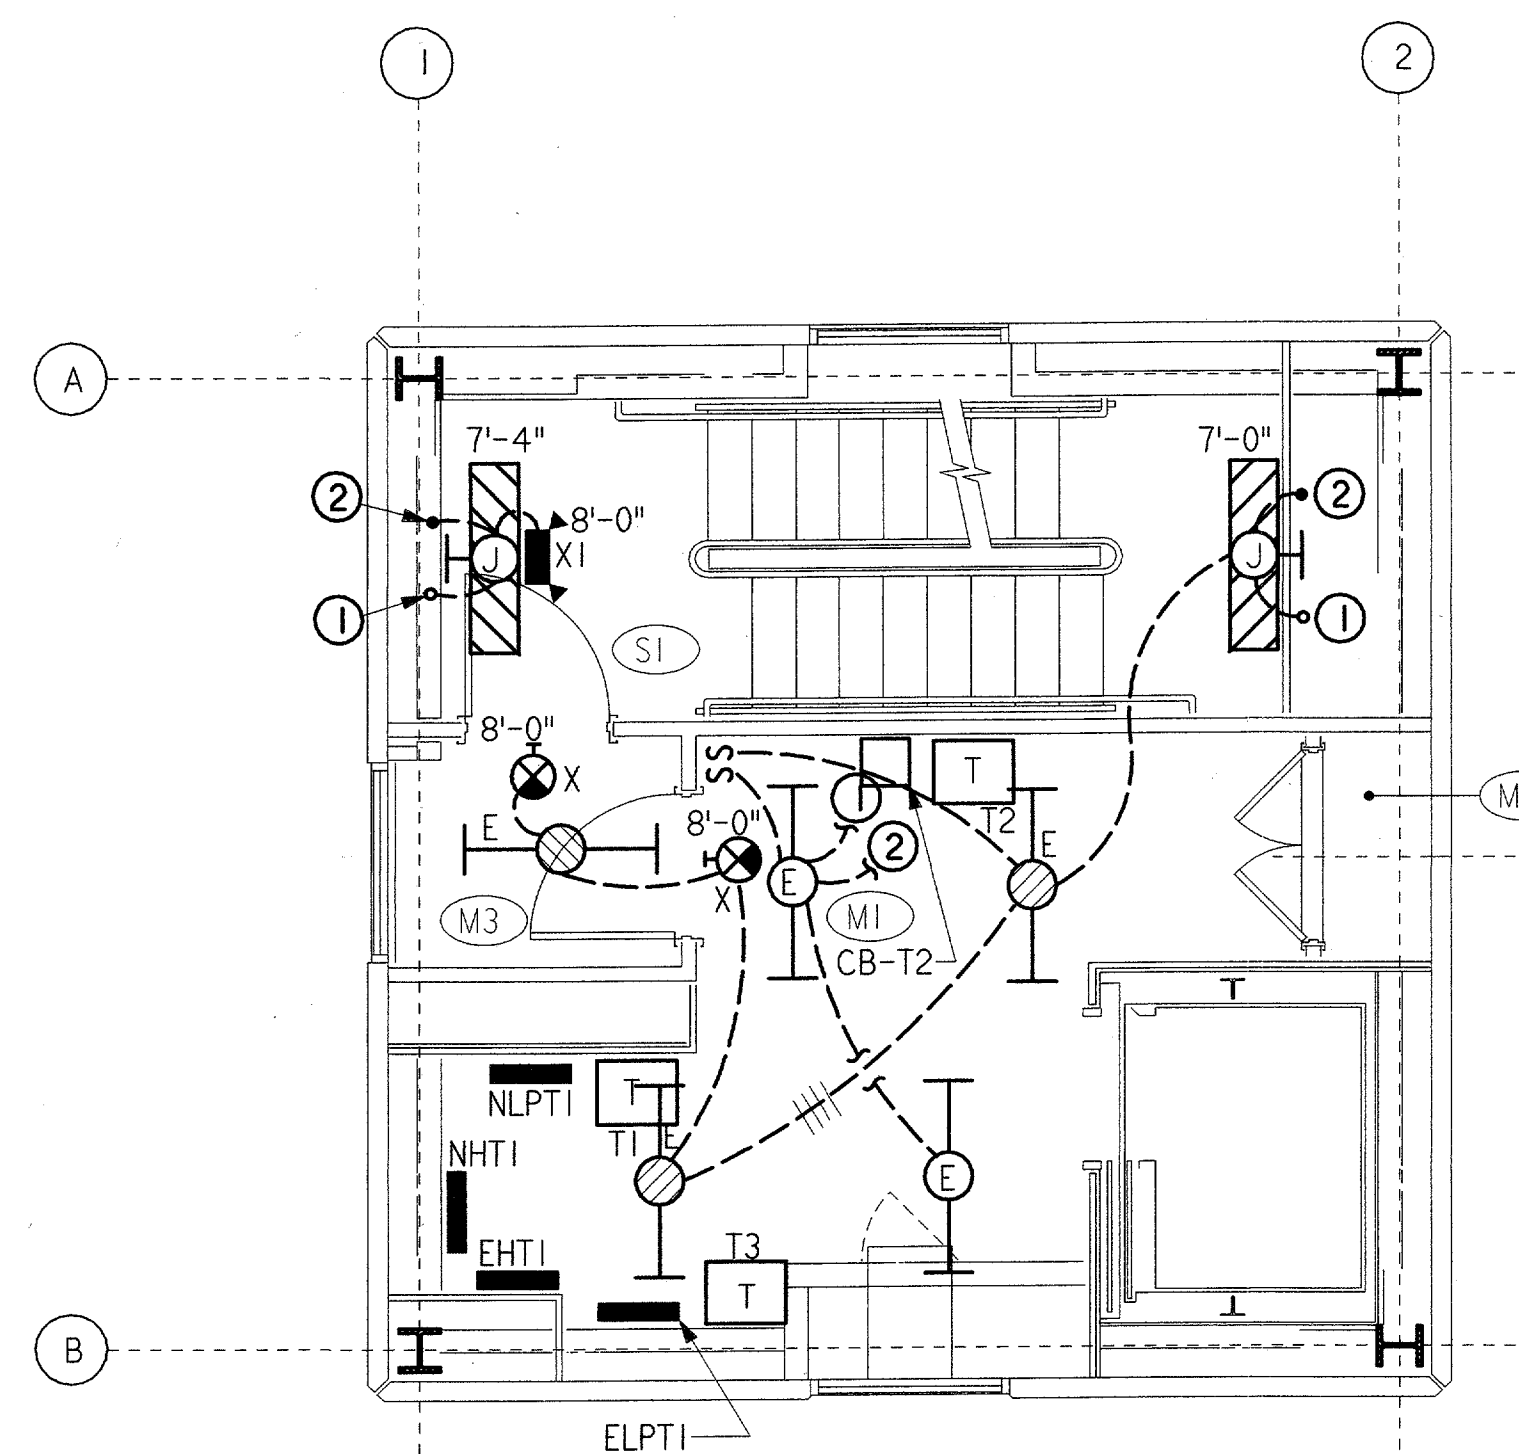

**MIDDLE INTERMEDIATE LEVEL**  
1/4" = 1'-0" EL = 20'-0"

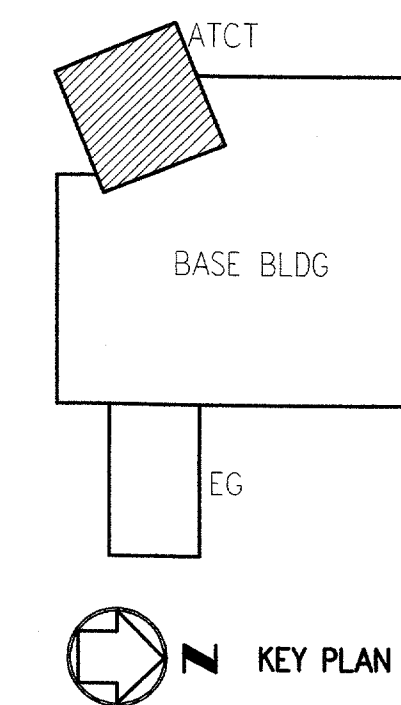

REV.	DATE	DESCRIPTION	DRG.	CHECKED
DALLAS, TX				

DEPARTMENT OF TRANSPORTATION  
FEDERAL AVIATION ADMINISTRATION  
SOUTHWEST REGION FORT WORTH, TEXAS

LOW ACTIVITY LEVEL  
AIRPORT TRAFFIC CONTROL TOWER

LIGHTING PLANS  
ATCT

ADDISON (ADDISON AIRPORT) TEXAS

APPROVED: *Johnnie L. White*  
MANAGER INFRASTRUCTURE PLATFORM, ANI-630

DESIGNED: A. SMITH  
REVIEWED: B. EISENRICH  
ORIG. DFT.: R. RUTGER  
FACILITY:

ISSUED BY: AIRWAY FACILITIES DIVISION

DATE: 06-22-01  
DRAWING NUMBER: ADS-ATCT-E21

E21