

8

7

6

5

4


3

2

1

H
G
F
E
D
C
B
A

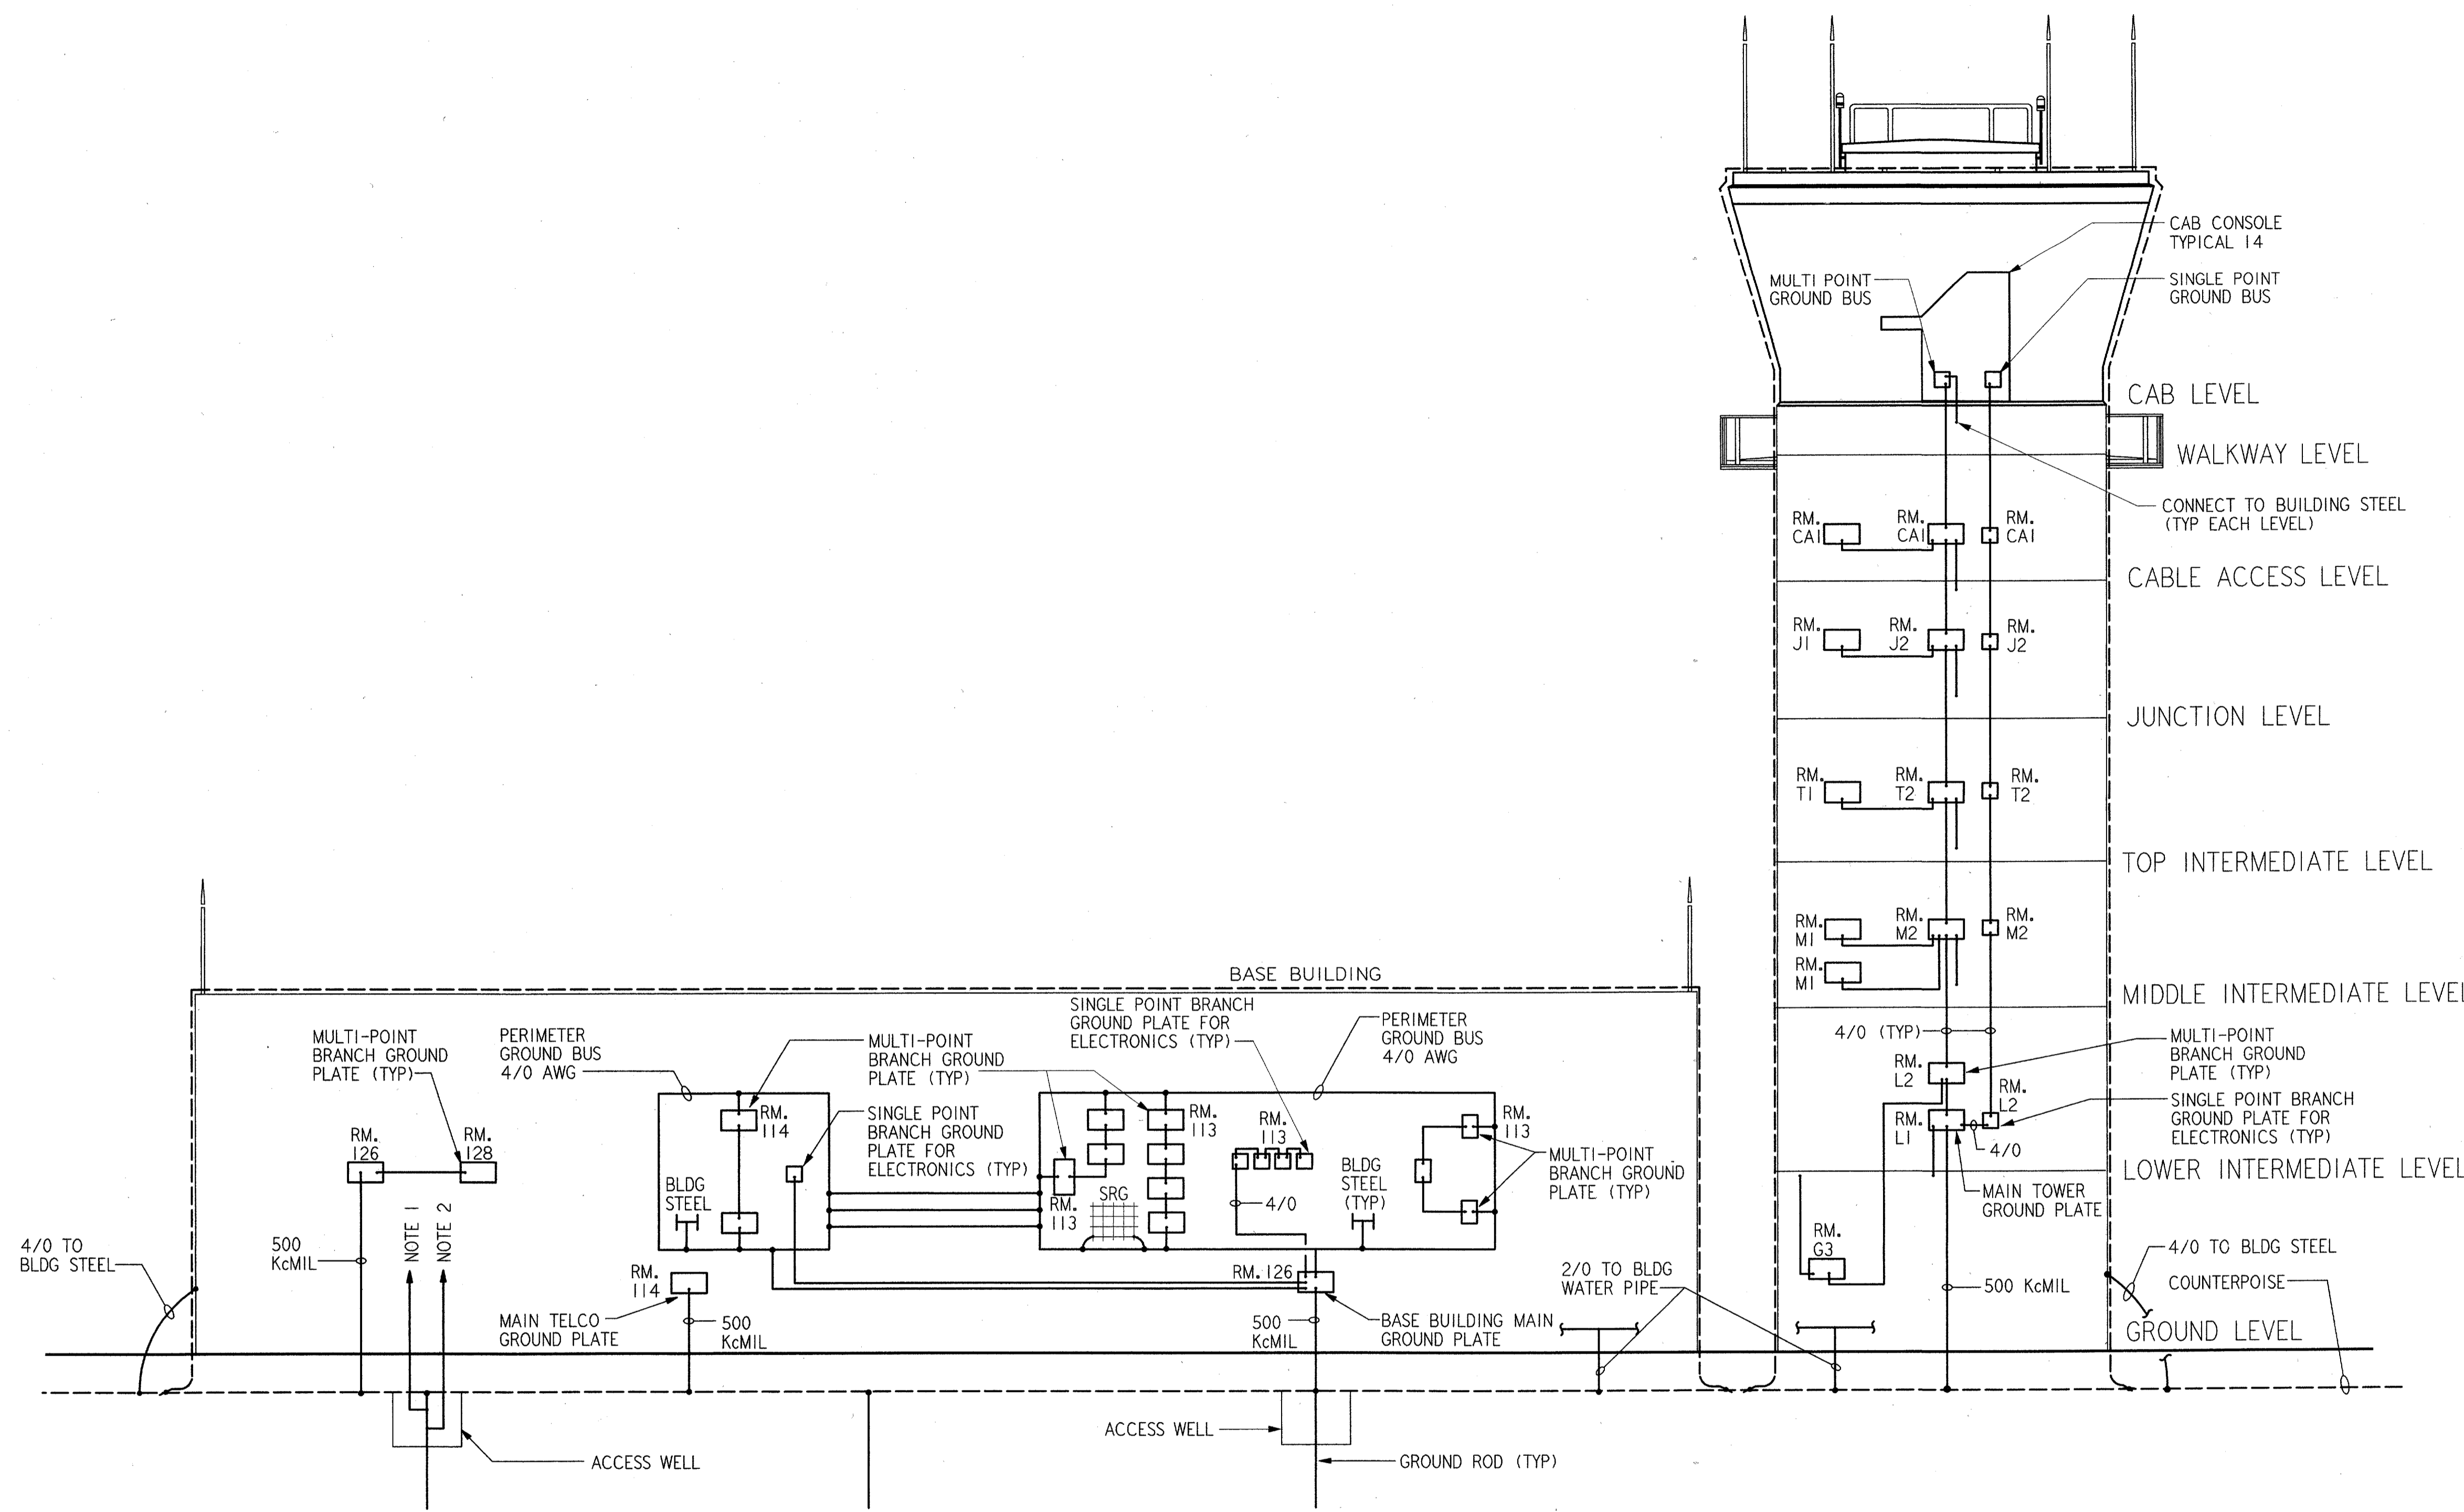

- NOTES:**
- 4/0 AWG TO ENGINE GENERATOR
 - 4/0 AWG TO MDPNH.



LIGHTNING PROTECTION AND GROUNDING RISER DIAGRAM

NTS

REV.	DATE	DESCRIPTION	DFTG.	CHECKED

DALLAS, TX

E33

**DEPARTMENT OF TRANSPORTATION
FEDERAL AVIATION ADMINISTRATION**

SOUTHWEST REGION FORT WORTH, TEXAS

LOW ACTIVITY LEVEL
AIRPORT TRAFFIC CONTROL TOWER

**LIGHTNING PROTECTION AND GROUNDING
RISER DIAGRAM**

ADDISON (ADDISON AIRPORT) TEXAS

SUBMITTED BY: <i>[Signature]</i> 10/15/01 SYSTEMS ENGINEER, ANI-630	APPROVED BY: <i>[Signature]</i> 10/15/01 MANAGER, INFRASTRUCTURE PLATFORM, ANI-630
DESIGNED: A. SMITH REVIEWED: B. EISENRICH ORIG. DFT.: R. RUTGER FACILITY:	ISSUED BY: AIRWAY FACILITIES DIVISION

DATE: 06-22-01
DRAWING NUMBER:
ADS-ATCT-E33