


PRINTS ISSUED table with columns: NO., DATE, PURPOSE

FOR CONSTRUCTION table with columns: NO., DATE, REVISIONS, ITEM

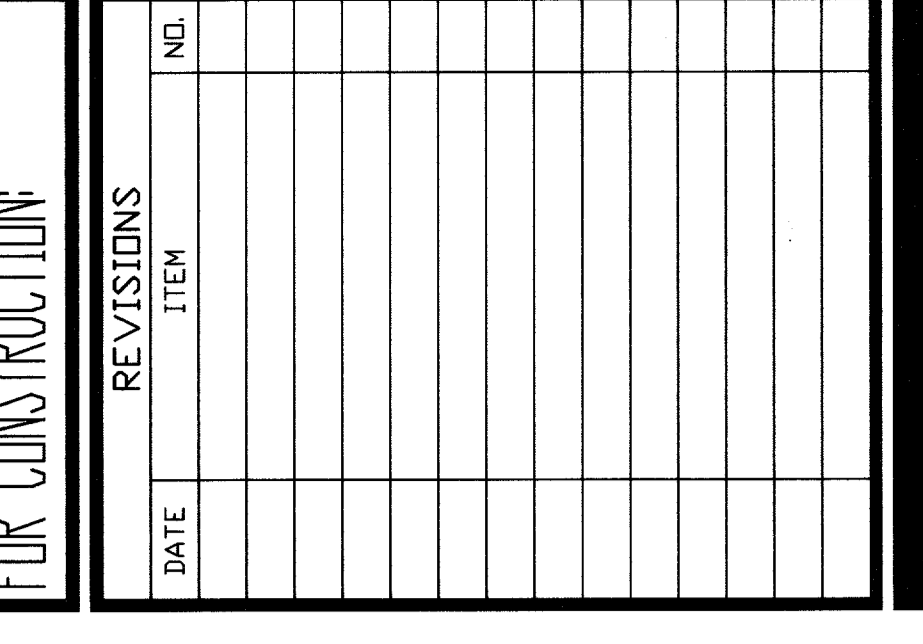


LAWSON ENGINEERING
ARCHITECTS & ENGINEERS
345 RIVERVIEW, WICHITA, KS 67203
Phone (316) 697-1981 Fax (316) 697-1982

CHECKED/JAK, RELATED DRAWINGS table


SEQUENCE NUMBER table with columns: SHELL, DETAILS, STRUCTURE, MECHANICAL, ELECTRICAL, OTHER

SUMMERFIELD SUITES HOTEL
ADDISON, TEXAS
PROJECT NUMBER 94780

DRAINAGE PLAN SHEET TITLE, SHEET NUMBER C-3, 3 OF 7 SHEETS

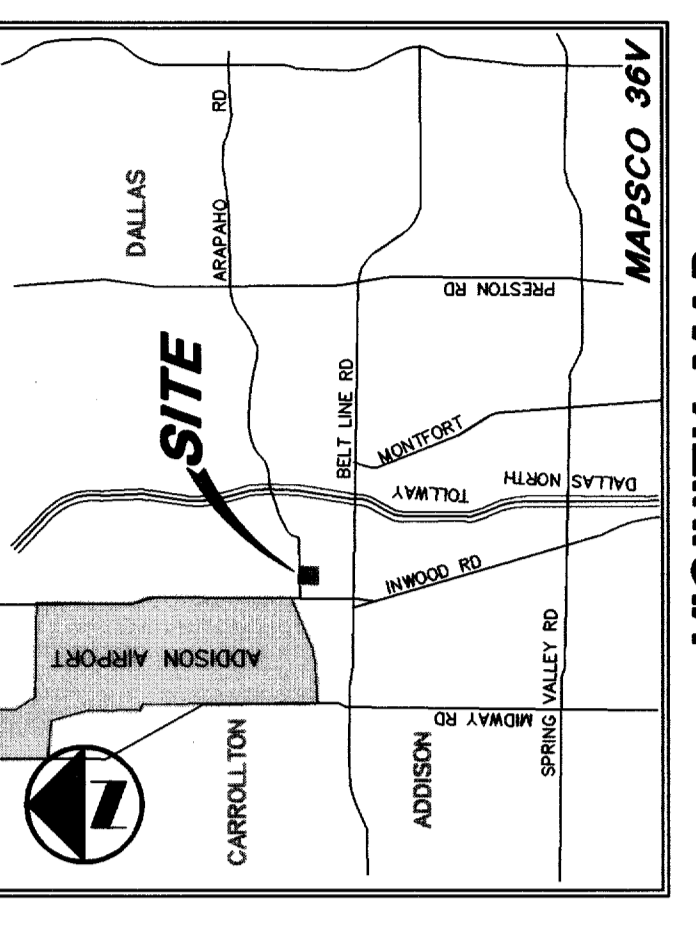


CAUTIONAL UNDERGROUND TELEPHONE AREAS... CONTACT: MR. ED KEAH... BENCH MARKS: 1. 'D' CUT ON S.E. CORNER OF SIDEWALK AT THE ENTRANCE TO 4805 ARAPAHO RD.

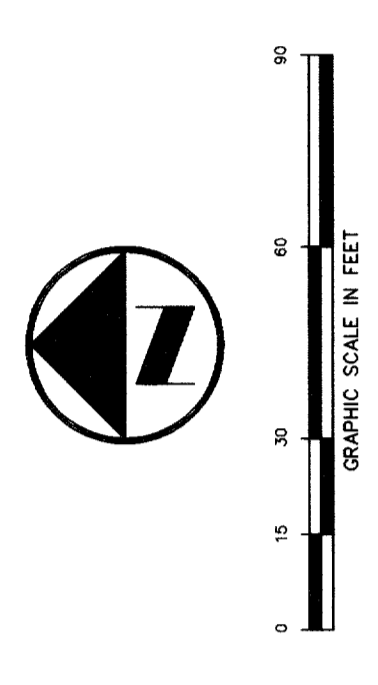


- LEGEND: FIRE HYDRANT, SANITARY MANHOLE, LIGHT STANDARD, WATER METER, WATER VALVE, CLEANOUT, MANHOLE, GAS METER, PROPERTY LINE

TABLE with columns: SECTION, PIPE DIA, SLOPE, V, V7/29, C, Sf, n, W, Qmax, n, W, Qmax

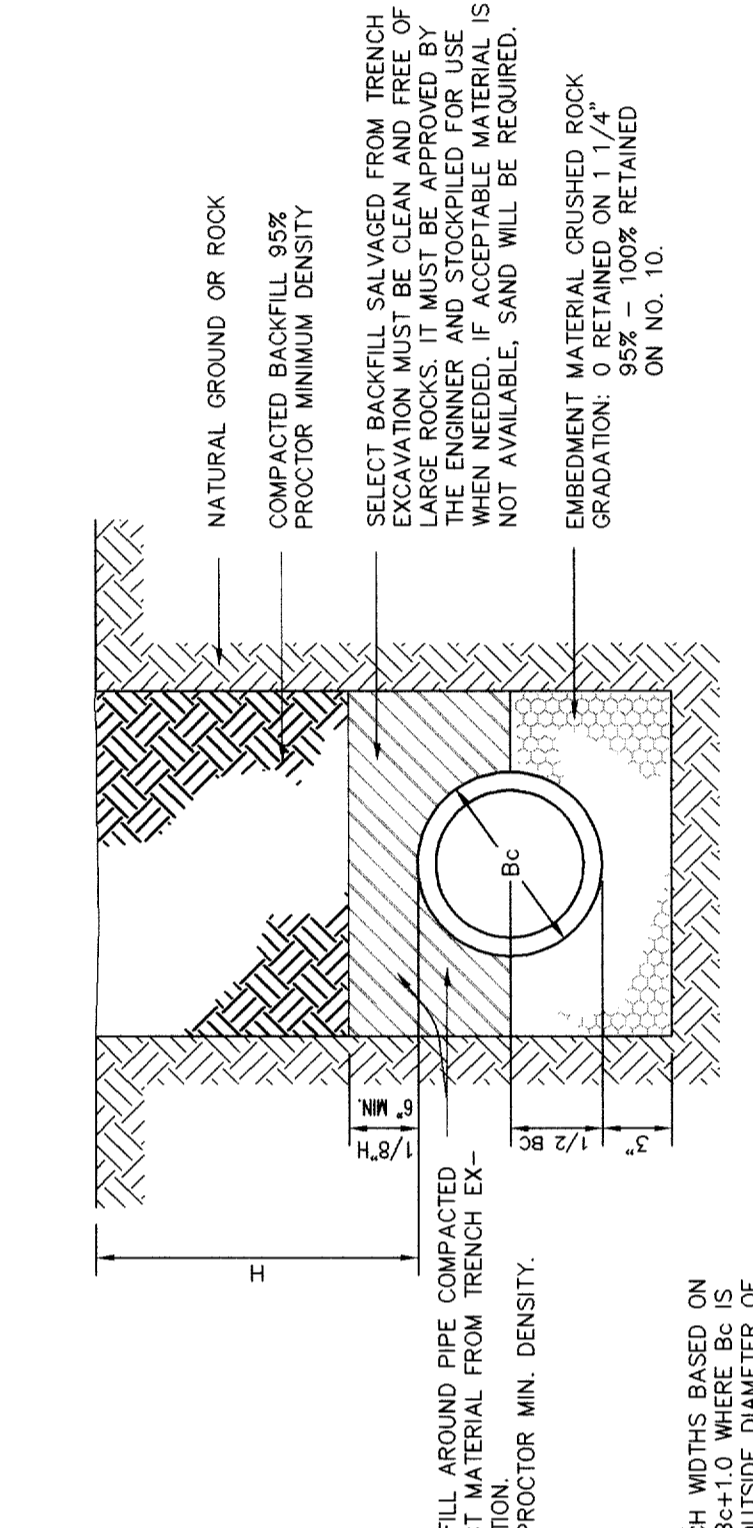

RECORD DRAWING THIS DRAWING HAS BEEN REVISED TO REFLECT CONSTRUCTION RECORDS MAINTAINED AND PROVIDED BY THE CONTRACTOR FOR THIS PROJECT. CONTRACTOR: SOUTHERN MECHANICAL PLUMBING, INC. DATE REVISED: 29 MARCH 1996

DRAINAGE PLAN SUMMERFIELD SUITES HOTEL ARAPAHO ROAD QUORUM CENTER ADDITION, TEXAS

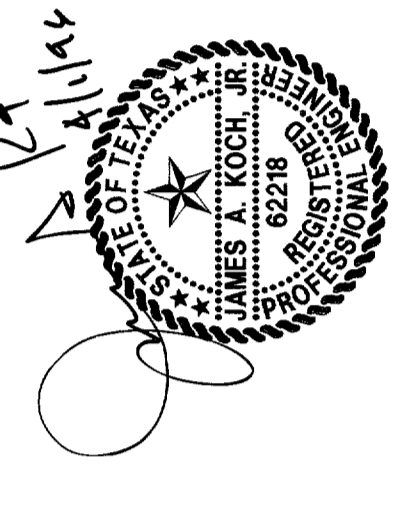

PA. No. 1467-9-001 DWG. No. 1467-702

