



Strip Lt. W/2-F96T12 R5 CW Lamp  
Typ For 24 Fix'ts. Mfg. By Rangaire Corp.  
Cat. No. S-296, Ea. W/O Ballast - Mnt. On Bottom Of 30° Laterals, 25'± Up - See Elev. To Left

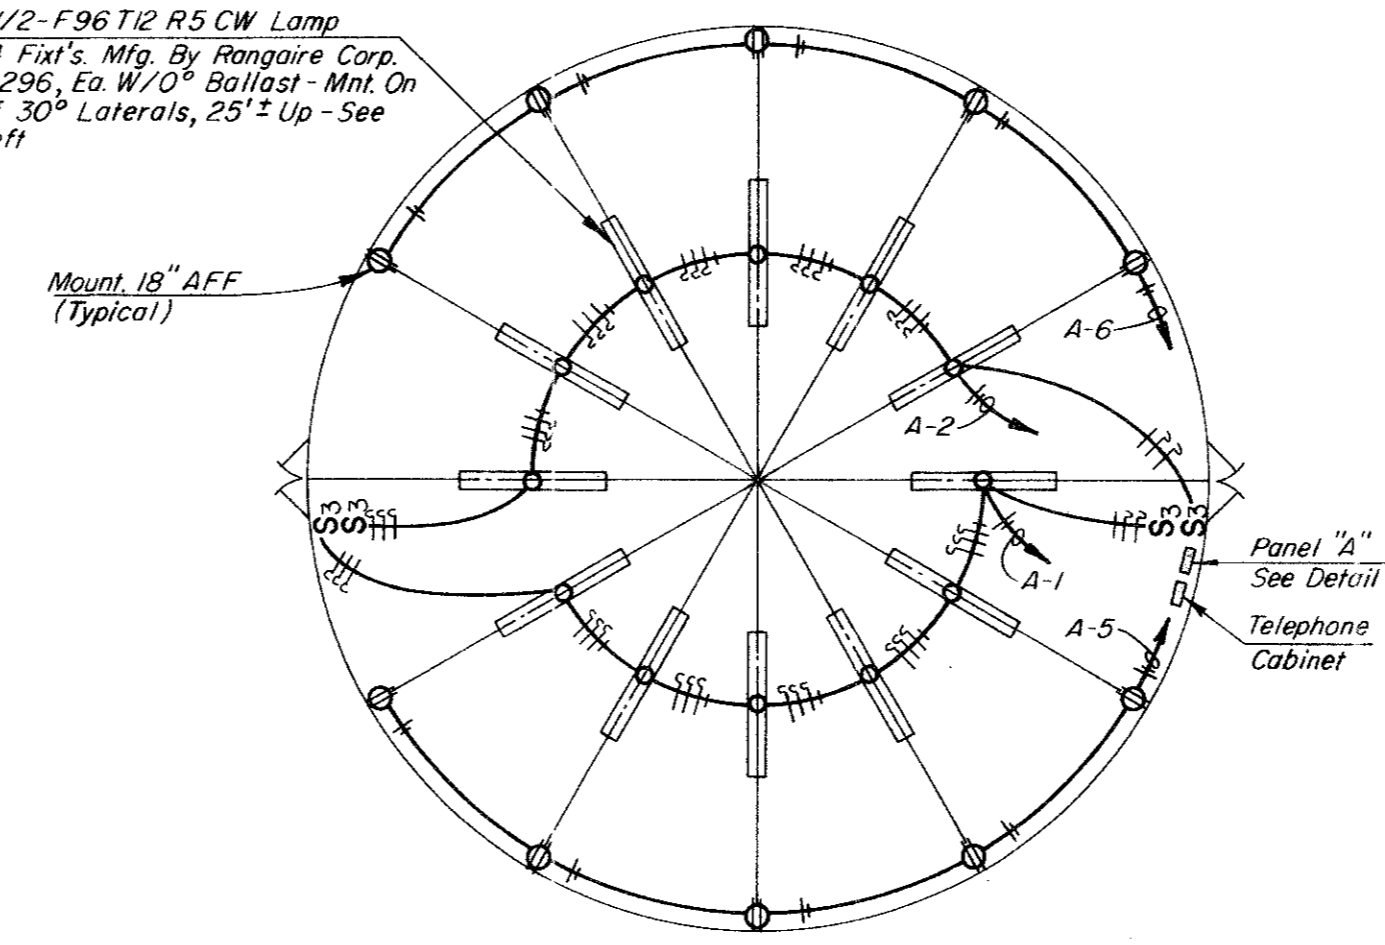


SECTION "A-A"  
No Scale

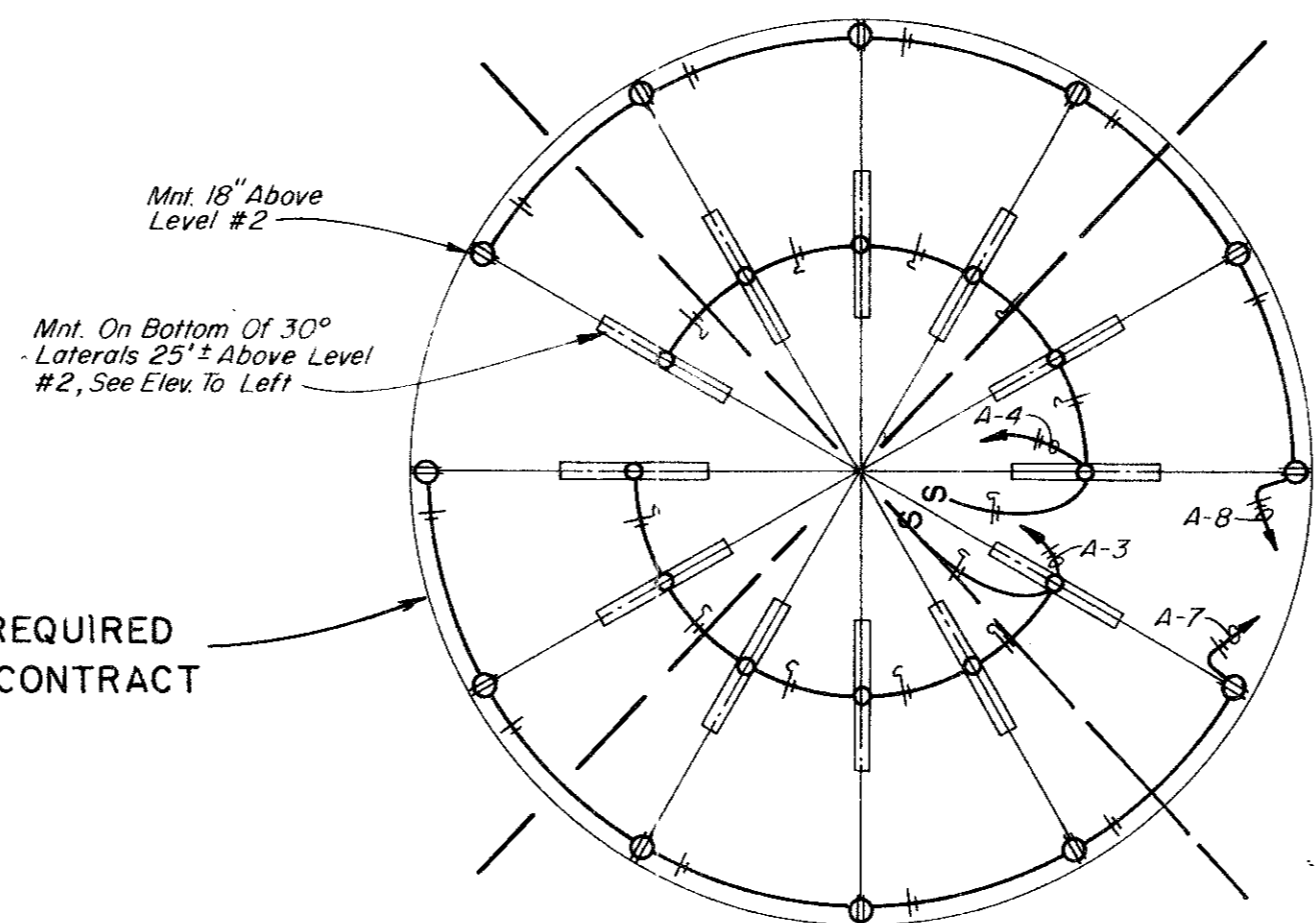


SECTION "B-B"  
No Scale

NOT REQUIRED THIS CONTRACT

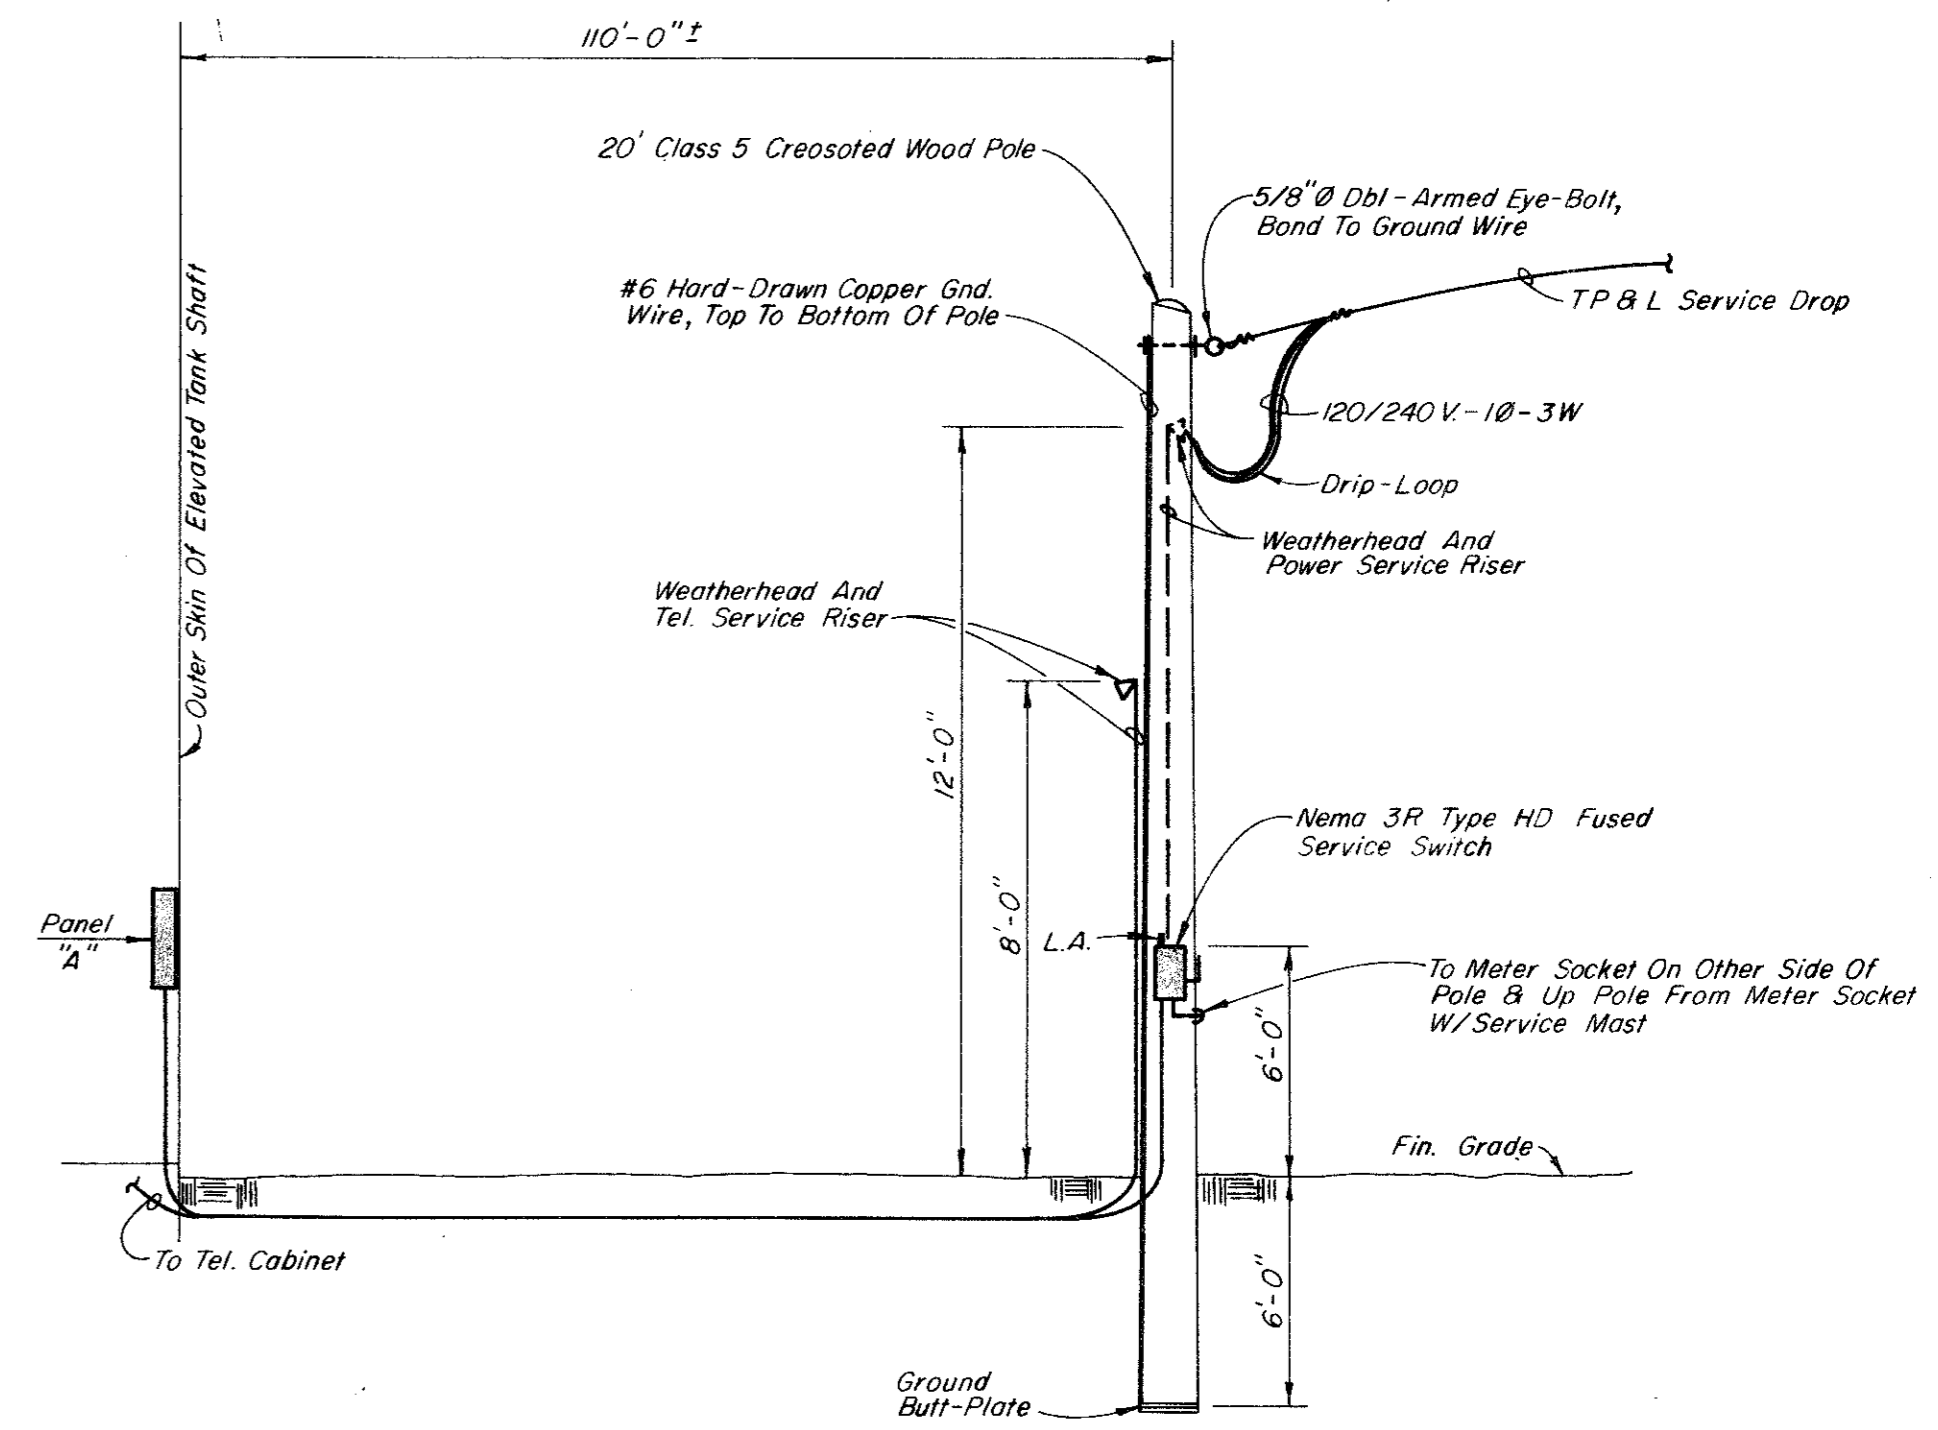


SERVICE ENTRANCE DETAIL  
No Scale

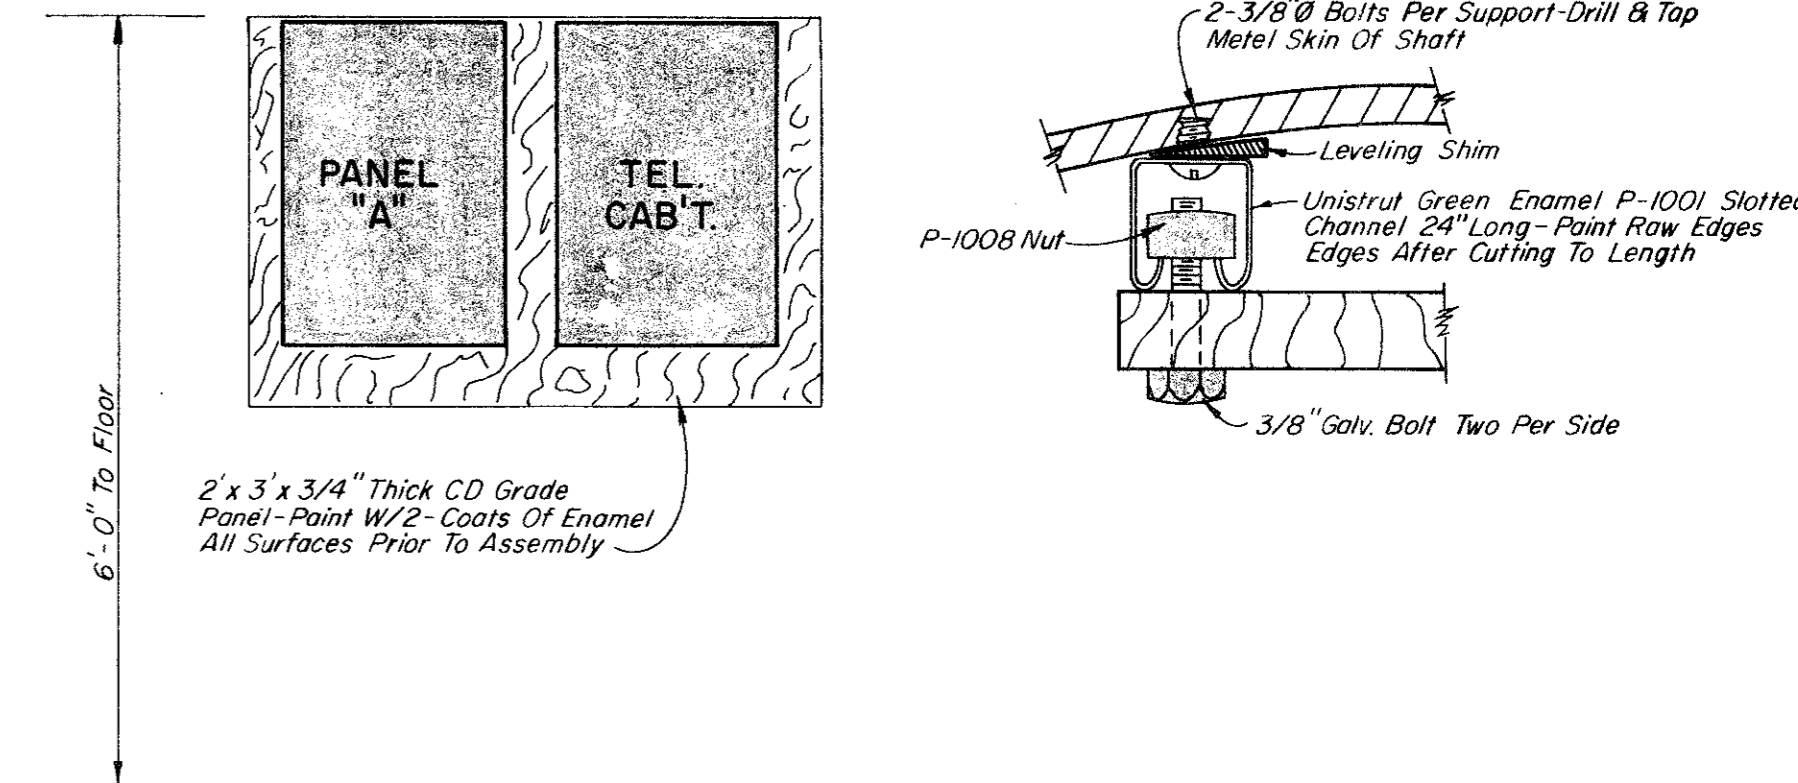


PANEL & CABINET MOUNTING DETAILS  
No Scale

- LEGEND**
- Fluorescent Lt. Fix't.
  - ⊕ Duplex Receptacle - 15A, 125V.
  - S Switch, SPST
  - S<sub>3</sub> Switch, 3-Way
  - ⊙ Junction Box
  - ⊥ Circuit Feeder, Neut., Hot & Switch Leg
  - Home Run To Panel

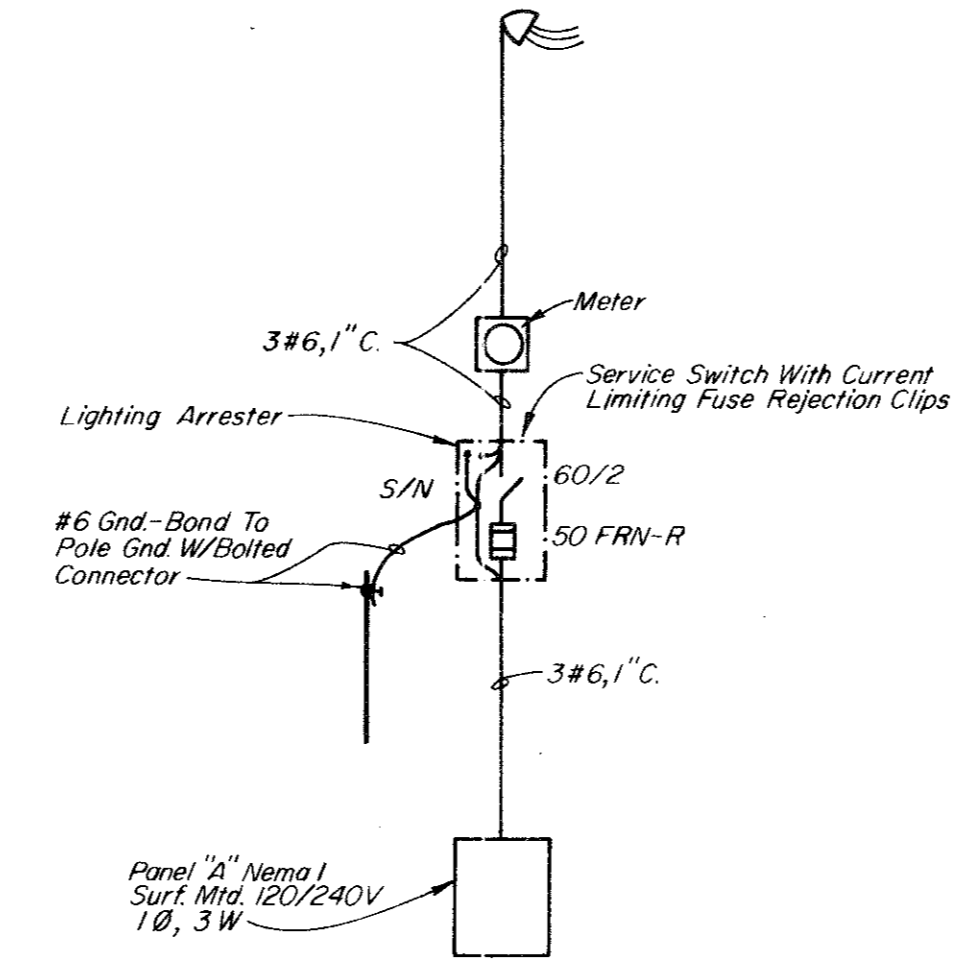

POWER RISER DIAGRAM  
No Scale

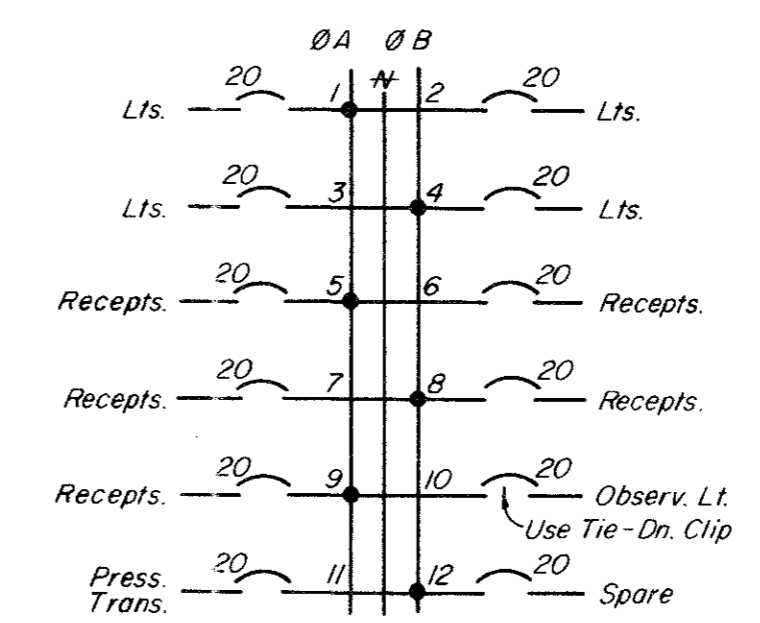

PANEL "A" - ONE LINE  
No Scale

OVERHEAD STORAGE TANK ELEVATION  
No Scale



CITY OF ADDISON  
DALLAS COUNTY, TEXAS  
WATER IMPROVEMENTS

**ELECTRICAL PLAN & DETAILS**

GINN & STACY, INC.  
CONSULTING ENGINEERS  
DALLAS, TEXAS

Designed By: C.R.M. Scale: None  
Drawn By: W.G.A. Date: 4-26-77 Sheet 4 of 4