



Handwritten notes in the top right corner, including "DATE" and "BY" fields.

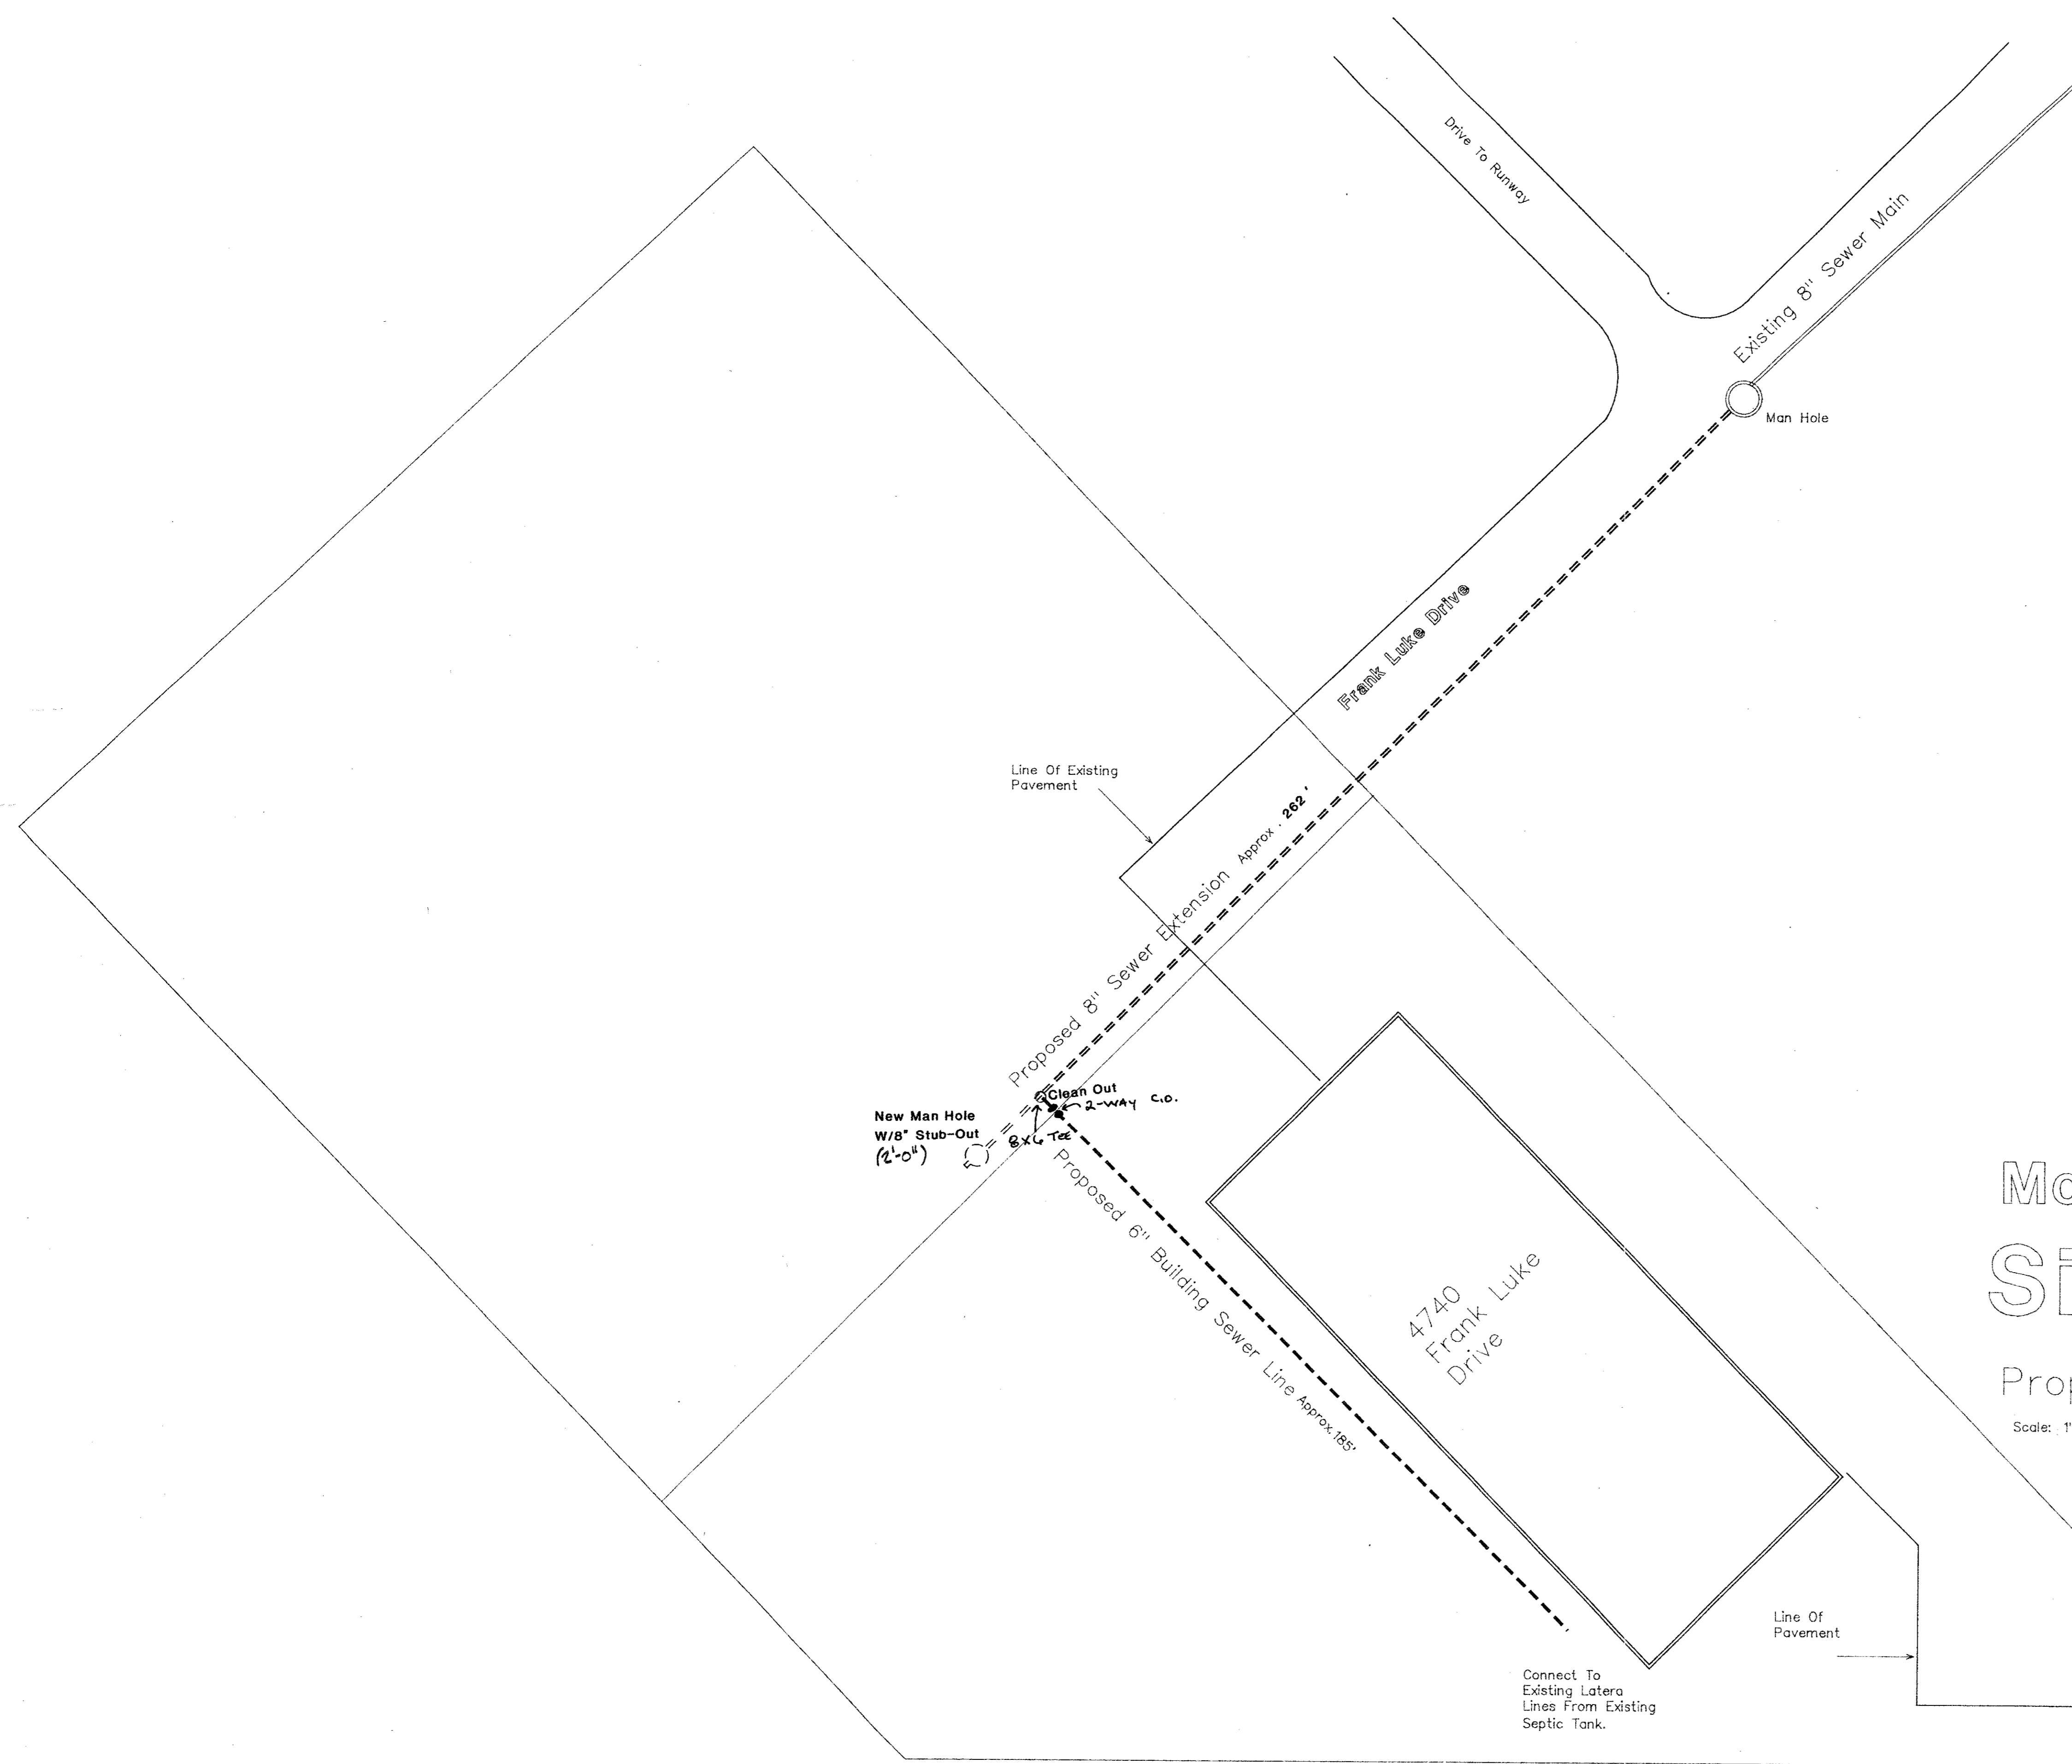

McKamy Air Site Plan

Proposed Sewer Line Extension

Scale: 1"=20'

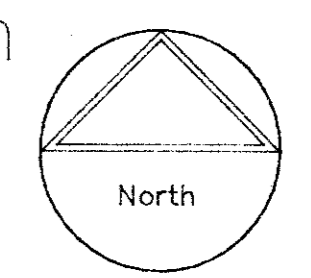

AS BUILT

Drawing Produced By

DH

DESIGNS
COMMERCIAL
SPACE PLANNING

214 985 0455
P.O. Box 86643
Plano, Texas 75086

Date: 6/1/89

Revised 6/23/89
Revised 6/28/89