 


38-12

FRANK LUKE



LEGEND

- IRON ROD FOUND
- IRON ROD SET
- ⊗ "X" FOUND IN CONCRETE
- ⊕ P.K. NAIL FOUND
- ⊕ WATER METER
- ⊕ TELEPHONE RISER
- ⊕ SANITARY SEWER MANHOLE
- CLEANOUT
- ⊕ LIGHT POLE
- () INDICATES RECORD DATA PER TITLE COMMITMENT



Scale 1" = 20 ft

TAXIWAY

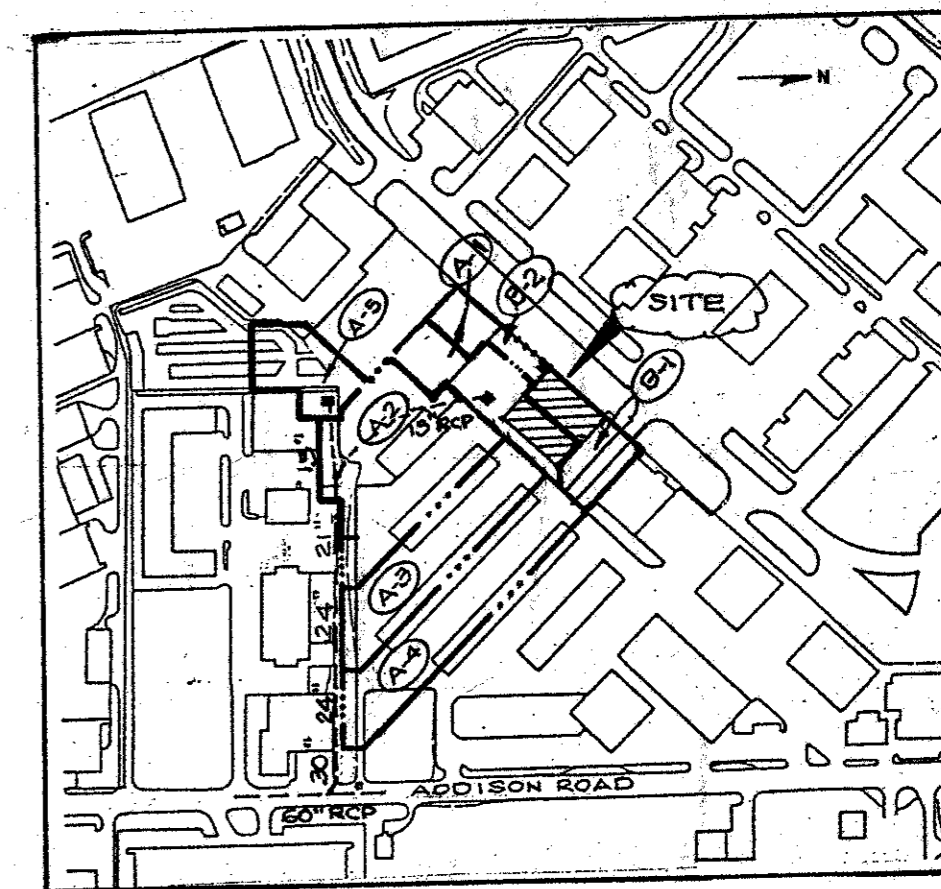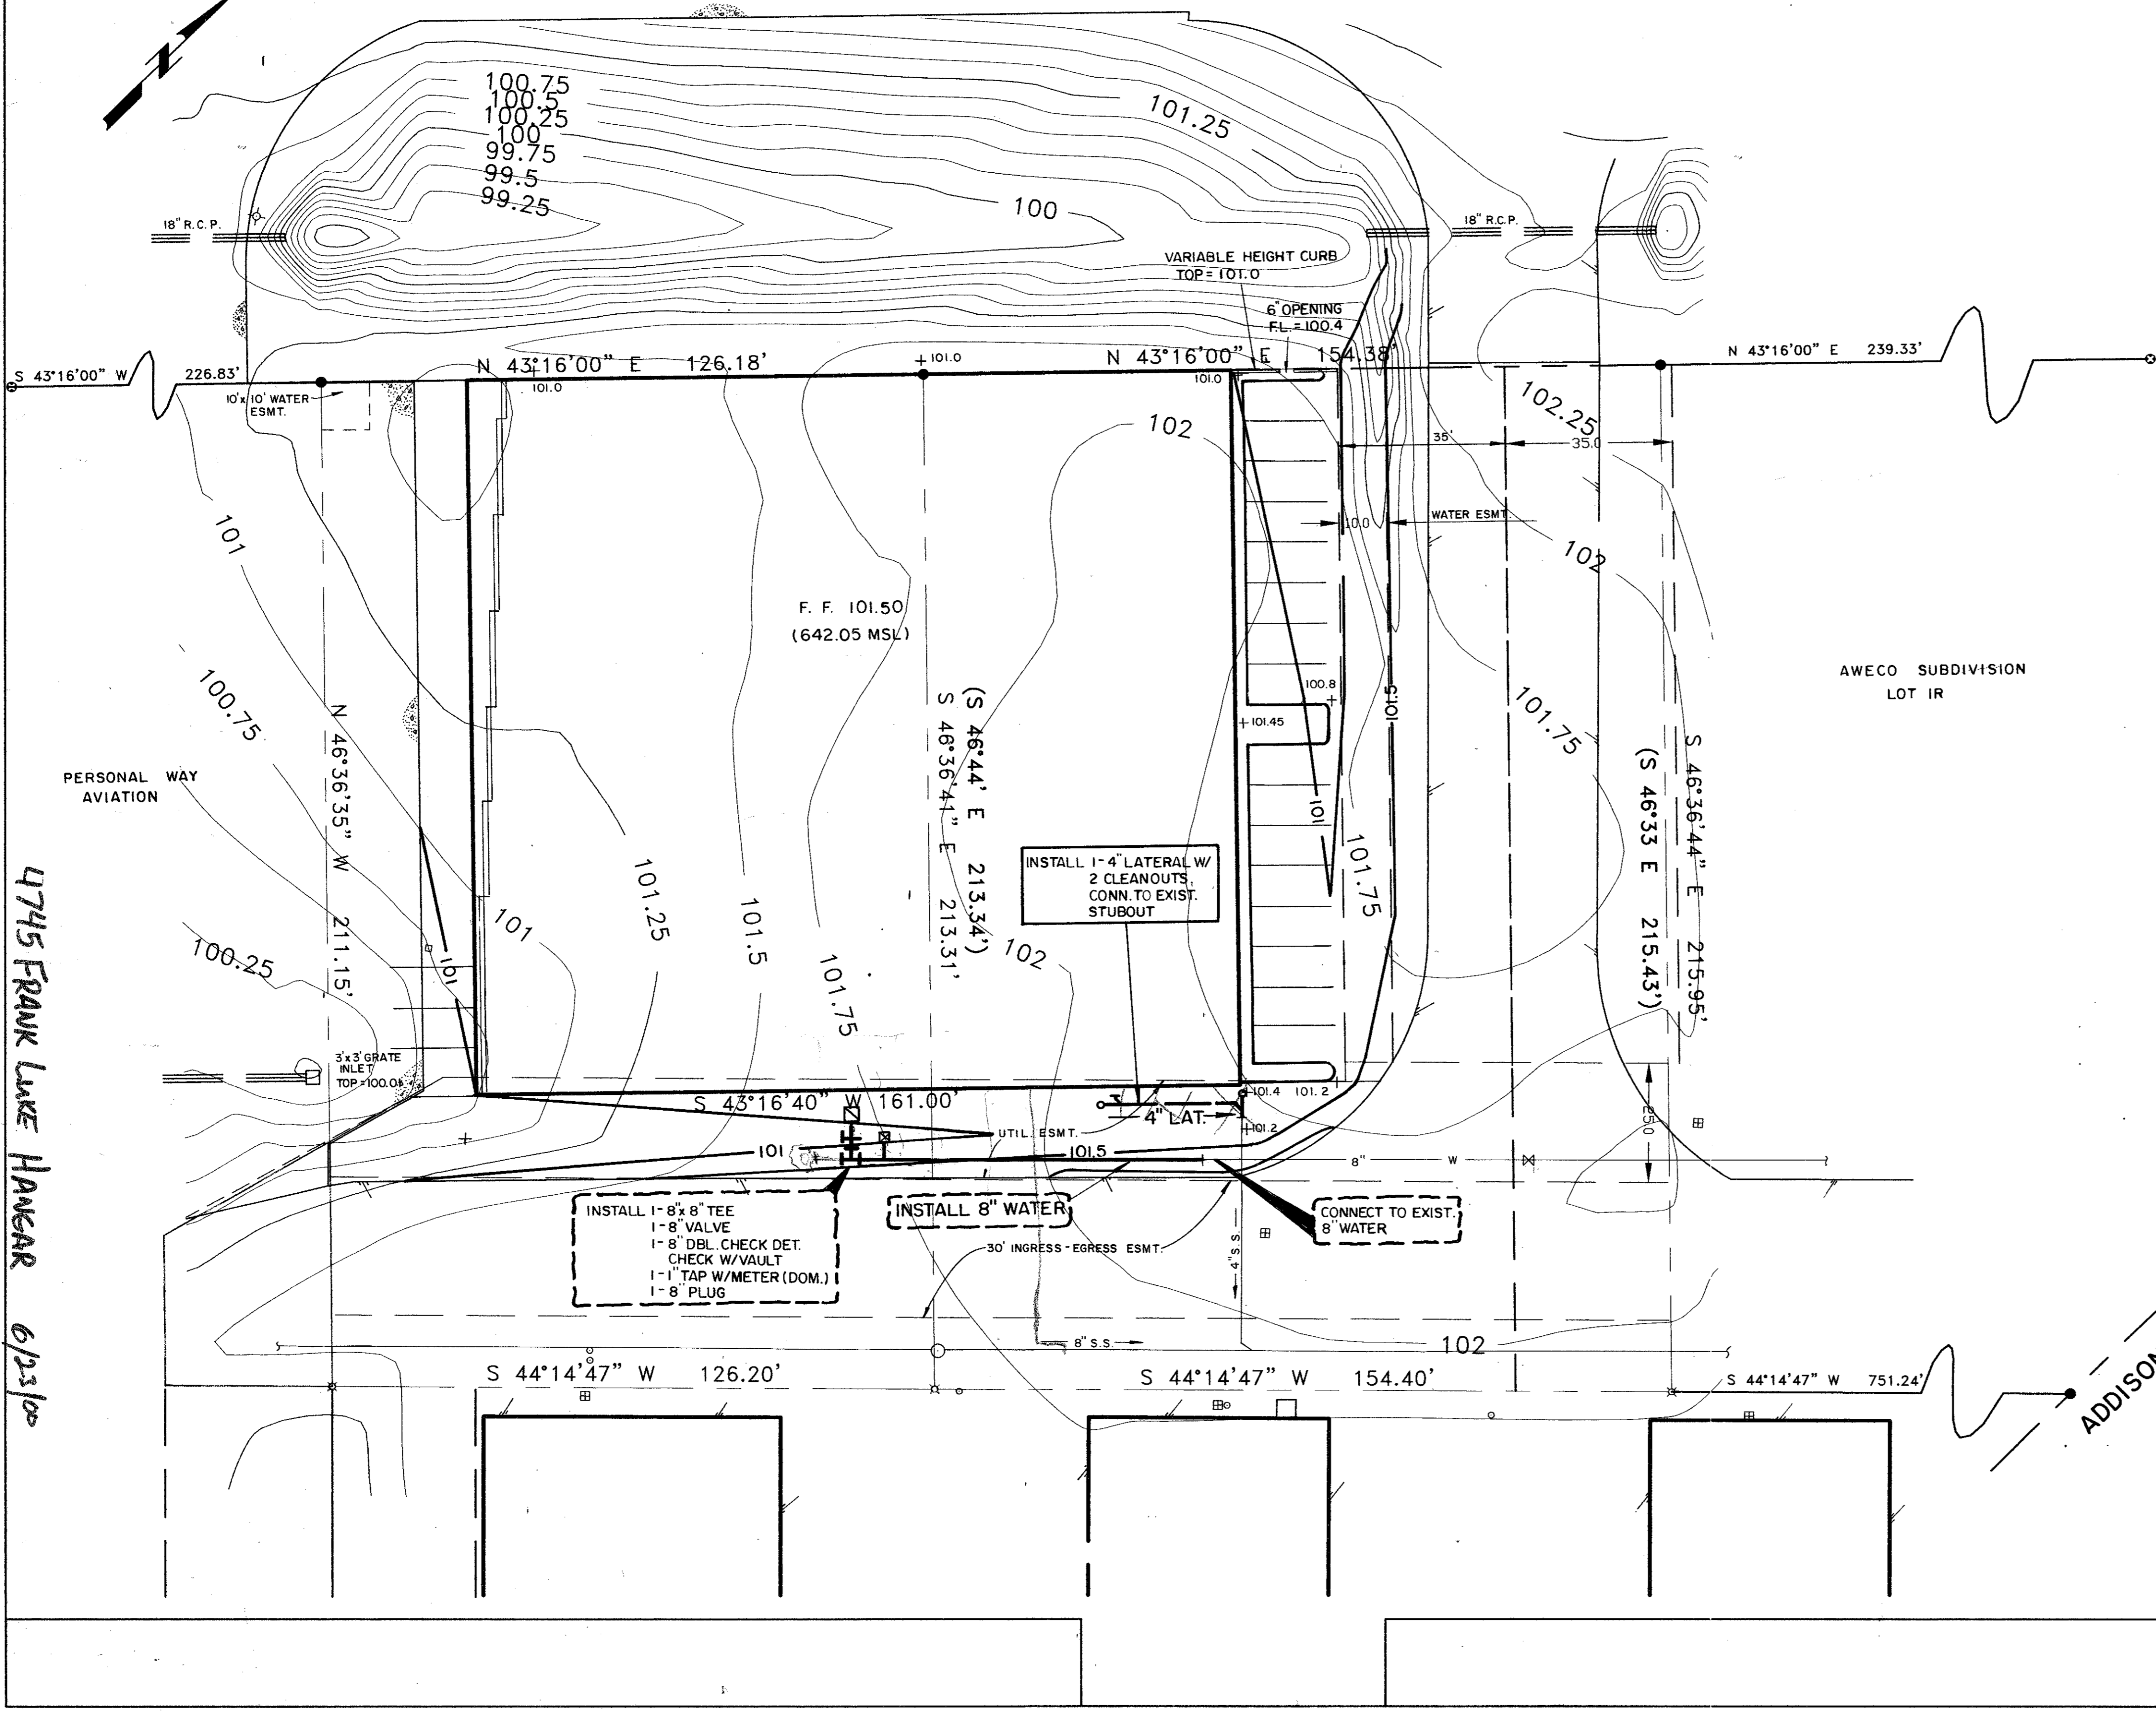

DRAINAGE AREA MAP

D.A.	AREA	C	I	Q	Comments
A-1	1.0	0.85	8.74	7.4	3x3' G.I.
A-2	2.1	0.85	8.74	15.6	3x3' G.I.
A-3	1.6	0.85	8.74	11.9	10' C.I.
A-4	1.9	0.85	8.74	14.1	10' C.I.
A-5	0.5	0.85	8.74	3.7	V-Inlet
B-1	0.57	0.85	8.74	4.2	Swale
B-2	0.36	0.85	8.74	2.7	Swale

4745 FRANK LUKE HANAKR 6/23/00

FRANK LUKE HANAKR



Robert A. Smith
6-23-00

GRADING PLAN

AWECO SUBDIVISION LOT 2R

TOWN OF ADDISON, TEXAS

NEEDHAM WRIGHT ENGINEERS
A Pate Engineers, Inc. Company
10290 MONROE DRIVE
SUITE 101
DALLAS, TEXAS, 75229
PH. (214) 357-2981
FAX (214) 357-2985

DATE: 6-20-00

SCALE: 1" = 20'

B8-12